



Addendum 1

June 16, 2025

Fort Wayne Airport JEKCC Infrastructure Improvements

Item: 1.1

Description: Modification Section P – Bid Item Schedule

- A. Reduction of Base Bid Item #8 “Service Point” quantity from 2 EA to 1 EA.
- B. Addition of Base Bid Item #9 “Seeding and Restoration”

Item: 1.2

Description: Road Crown Clarification

- A. Crown of road clarified to be 2% typical slope in Typical Cross Section on C1.2.

Item: 1.3

Description: Addition of Seeding to Plan Sheets

- A. Addition of Layout Note 1 to C1.1 and C1.2 in areas of disturbance.

Item: 1.4

Description: Addition of Electrical Detail

- A. Addition of “City Riser Assembly on Existing Pole” detail on E1.0.

Item: 1.5

Description: Electrical Service Points

- A. Change of Work Description Note #1 from “New Power Source” to “New Service” and clarification of location from AEP Pole on E1.1, E1.2, and E1.3.
- B. Removal of new power source tag at intersection of Airway Avenue and Ardmore Avenue.

ITEMIZED PROPOSAL

Project Name: JEKCC Infrastructure Improvements

Project No.: AF25-07

Supplementing the enclosed Contractor's Indiana Bid Form No. 96, latest revision, the undersigned submits the following Itemized Proposal upon which the bid is based. The undersigned further acknowledges that he is fully aware of all conditions existing regarding the project, and has full understanding of all work to be done as outlined in the plans and specifications for the project; and further agrees that any change orders to the contract authorized by the Sponsor shall be based on the following schedule of unit prices where applicable.

INDIANA LEGAL EMPLOYMENT DECLARATION

The State of Indiana has enacted a law (I.C. 22-5-1.7) requiring the Fort Wayne-Allen County Airport Authority to require the following before renewing or entering into contracts for services:

This Declaration serves as notice that all Contractors performing services must, as a term of their contract:

1. Enroll in and verify the work eligibility status of newly hired employees of the contractor through the E-Verify programs (but is not required to do this if the E-Verify program no longer exists); and
2. Verify, by signature below, that the Contractor does not knowingly employ unauthorized aliens.

By signing below, this affidavit becomes a part of and is incorporated into any contract for services that your firm currently has with the Fort Wayne-Allen County Airport Authority.

I, _____, a duly authorized agent of _____ (name of Company), declare under penalties of perjury that _____ (name of Company) does not employ unauthorized aliens to the best of its knowledge and belief.

(Name of Company)

By: _____
(Authorized Representative of Company)

Subscribed and sworn to before me on this _____ day of _____, 20____.

My Commission Expires: _____

County of Residence: _____

Notary Public – Signature

Notary Public – Printed Name

PLEASE SEE <http://www.uscis.gov/e-verify> INSTRUCTIONS AND ELECTRONIC REGISTRATION FOR E-VERIFY.

IC 5-16-13 also requires that any contractor (including subcontractors) submit, before work begins on a project, the E-verify case verification number for each individual who is required to be verified under IC 22-5-1.7.

STEEL PROCUREMENT FOR PUBLIC WORKS

If any steel or foundry products are to be used or supplied in the performance of the contract or subcontract, only steel or foundry products made in the United States shall be used or supplied in the performance of the contract or any of the subcontracts unless the Executive Director of Airports determines, in writing, that the cost of steel or foundry products is considered to be unreasonable in accordance with IC 5-16-8-2 (b).

The contractor certifies that it will utilize only steel made in the United States unless it has obtained written approval from the Executive Director of Airports due to a bid cost differential of 15% or more incurred when using steel made in the United States over steel of foreign origin.

Failure of the contractor to comply with this requirement may result in a discontinuation of payment by the public agency to the Contractor.

CERTIFICATION OF BIDDER for the above:

Bidder's Signature _____

Bidders will complete the work in accordance with the Contract Documents for the following prices:

BID ITEM SCHEDULE

Contractor Name

PROJECT NAME: JEKCC Infrastructure Improvements

PROJECT NUMBER: AF25-07

Bidder will complete the Work in accordance with the Contract Documents for the following price(s):

JEKCC Infrastructure Improvements - BASE BID					
#	DESCRIPTION	QUANTITY	UNIT	UNIT PRICE	AMOUNT
1	Maintenance and Protection of Traffic	1	LS		
2	Mobilization and Demobilization (Not to Exceed 10%)	1	LS		
3	Construction Staking	1	LS		
4	Mill 1.5" Existing Asphalt	11,100	SY		
5	HMA Surface, 9.5 mm, Type B	920	TN		
6	New Pole/Light/Single Head Assembly	26	EA		
7	Traycable in HDPE Conduit	4,000	LF		
8	Service Point	1	EA		
9	Seeding and Restoration	1	LS		
BASE BID TOTAL					

JEKCC Infrastructure Improvements - ADD ALTERNATE #1					
#	DESCRIPTION	QUANTITY	UNIT	UNIT PRICE	AMOUNT
1	Mill 1.5" Existing Asphalt	1,900	SY		
2	HMA Surface, 9.5 mm, Type B	160	TN		
ADD ALTERNATE #1 TOTAL					

JEKCC Infrastructure Improvements - ADD ALTERNATE #2					
#	DESCRIPTION	QUANTITY	UNIT	UNIT PRICE	AMOUNT
1	Mill 1.5" Existing Asphalt	1,525	SY		
2	HMA Surface, 9.5 mm, Type B	130	TN		
ADD ALTERNATE #2 TOTAL					

The undersigned further agrees to complete the work according to the terms of the entire contract in 153 calendar days.

The undersigned hereby acknowledges receipt of the following Addenda:

No. _____ dated _____

No. _____ dated _____

No. _____ dated _____

TESTIMONY WHEREOF, the bidder has hereunto set his hand this _____ day of _____.

(Individual, Firm or Corporation)


(Seal By): _____

Title: _____


ATTEST: _____

END OF ITEMIZED PROPOSAL


June 6, 2025 11:03 AM
S:\Projects\Projects (6000-6999)\Projects (6000-6999)\6545-FWA JEKCC Infrastructure Improvements\Drawings\6545 C1.0 Site Demolition & Layout Plan.dwg

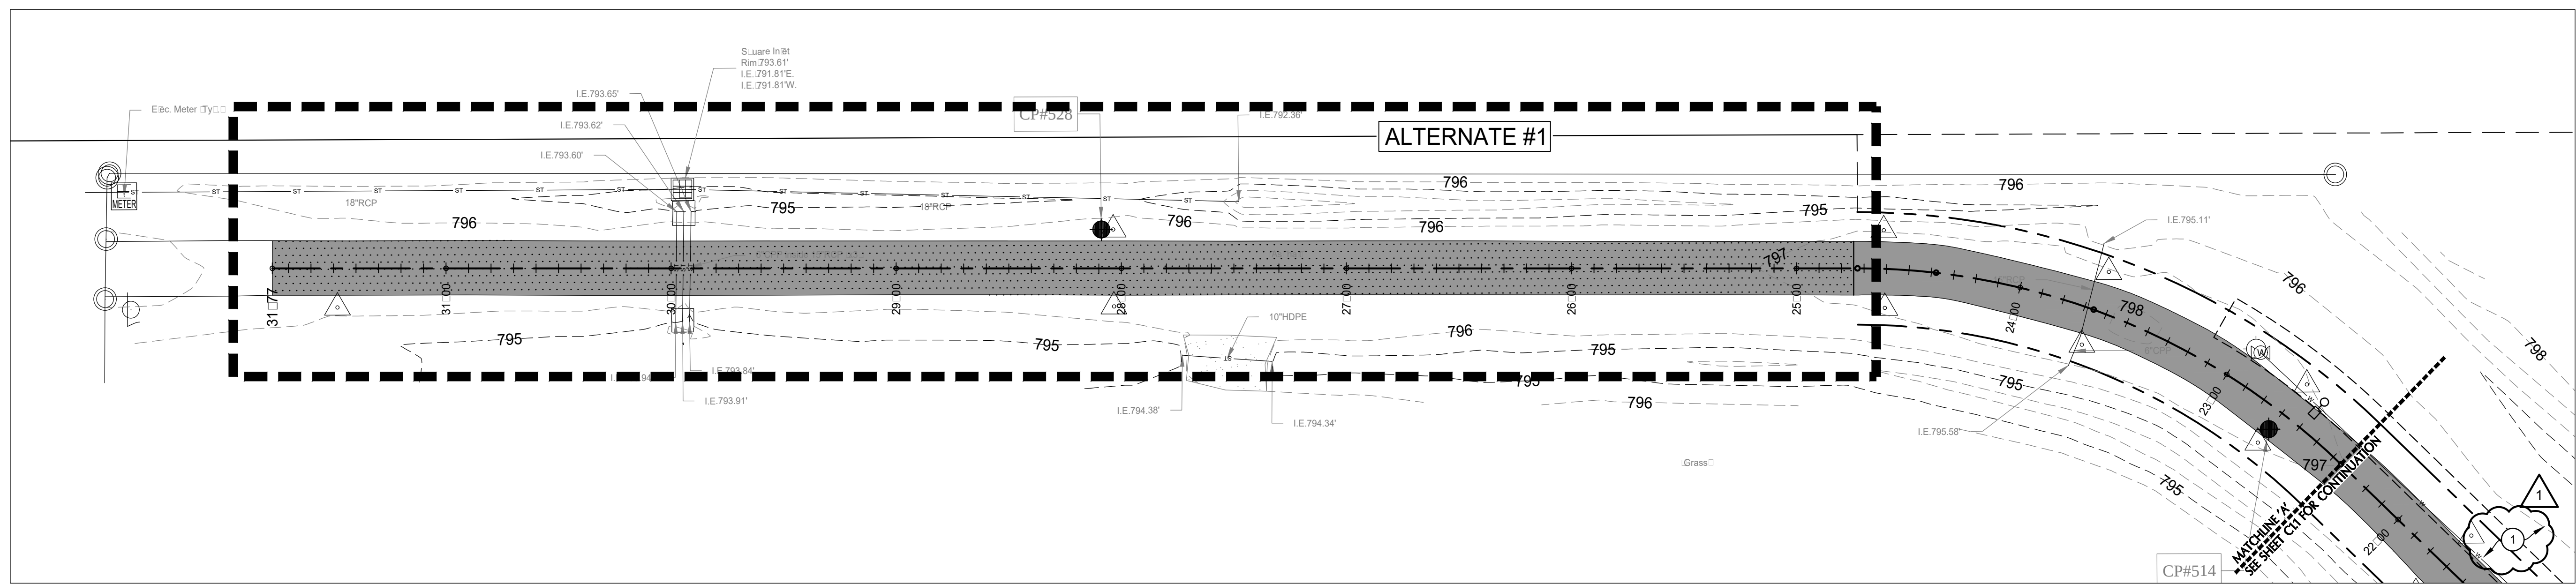

NORTHWEST PERIMETER ROAD - NORTH
SCALE: 1" = 40'

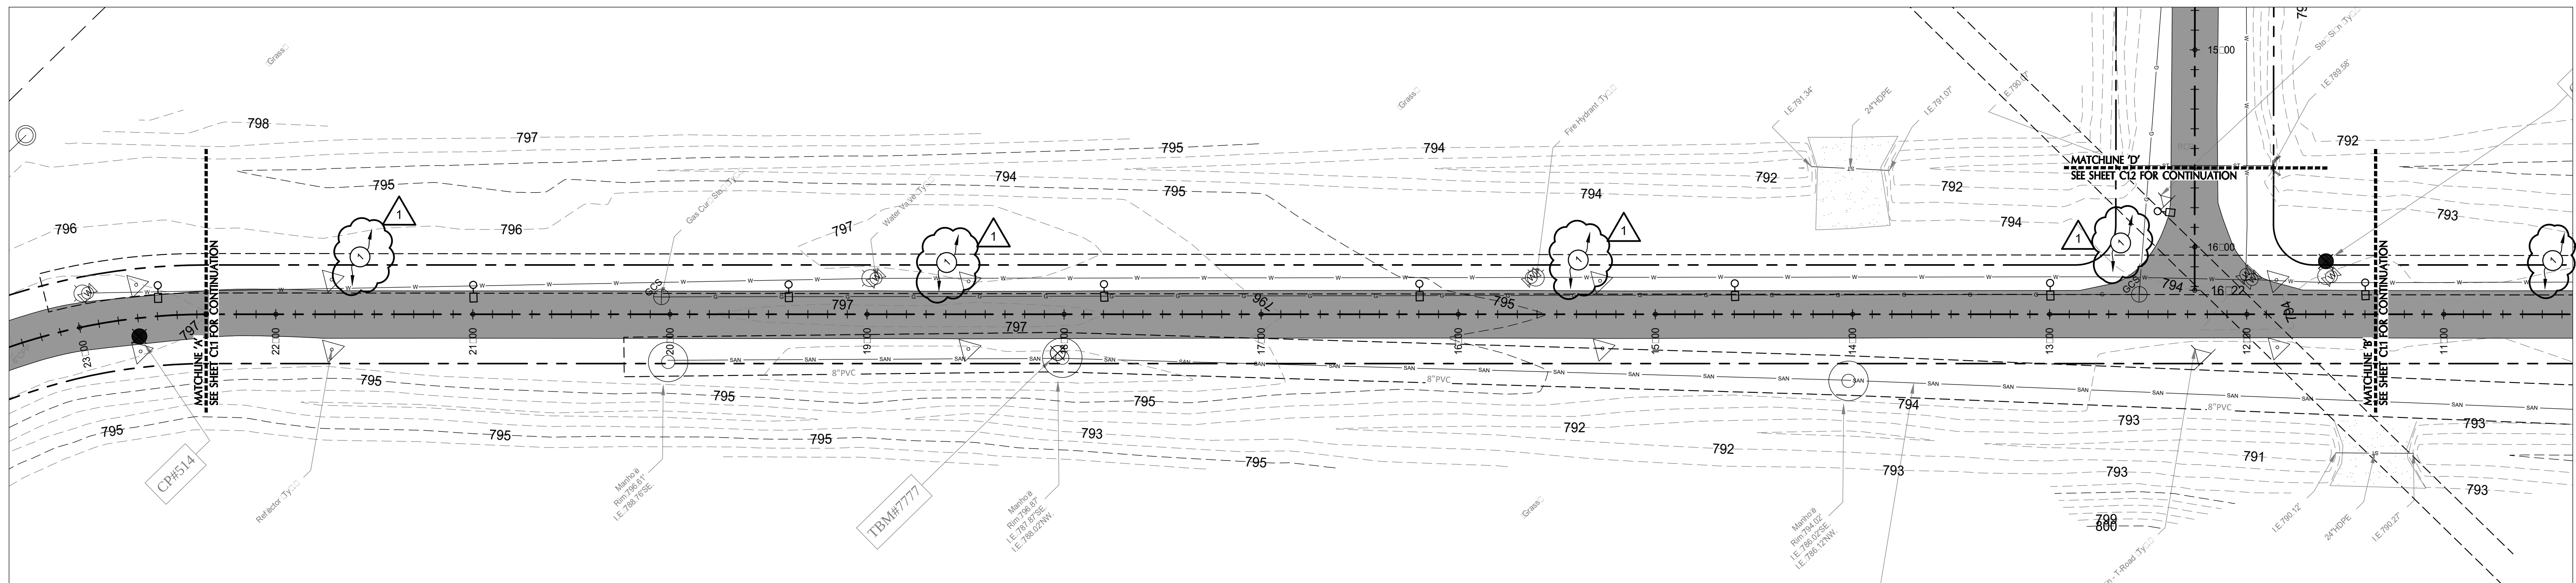

NORTHWEST PERIMETER ROAD - CENTRAL
SCALE: 1" = 40'

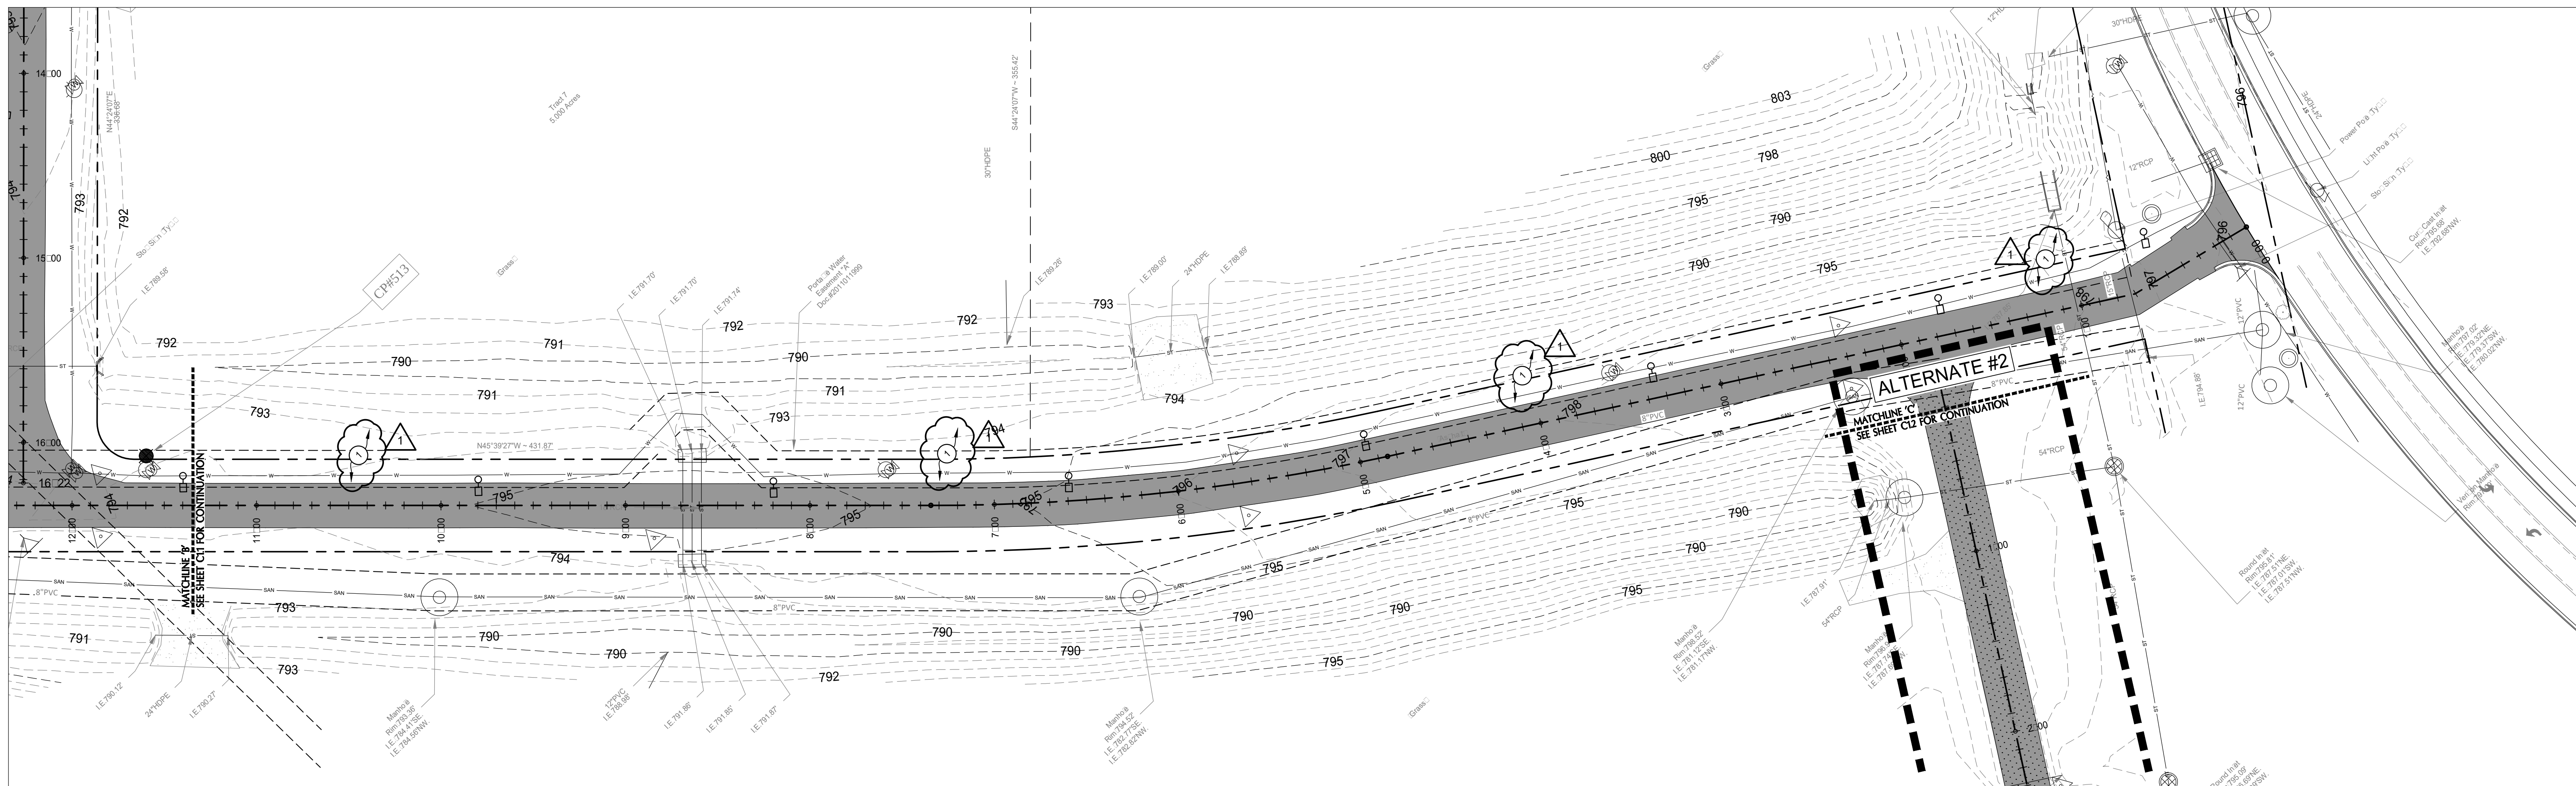

NORTHWEST PERIMETER ROAD - SOUTH
SCALE: 1" = 40'

LAYOUT NOTES

1 GRASS/LANDSCAPE AREA: ALL DISTURBED AREAS TO RECEIVE PERMANENT SEEDING. SEE SPECIFICATIONS SECTION 029200 "LAWNS & GRASSES".

LAYOUT LEGEND

PAVEMENT MILL AND OVERLAY PER DETAIL #1/C1.2.

ALTERNATE: PAVEMENT MILL AND OVERLAY PER DETAIL #1/C1.2.

NOTE: ALL DIMENSIONS ARE TO FACE OF CURB OR EDGE OF PAVEMENT UNLESS NOTED OTHERWISE.

PROPOSED LEGEND

○ LIGHT POLE

ENGINEERING RESOURCES, INC.
4175 New Vision Drive, Fort Wayne, IN 46845
Ph: (260) 490-1025 www.eri consulting

05-27-2025

REGISTERED PROFESSIONAL ENGINEER
No. 10911278
STATE OF INDIANA

M. D. R.

The concepts, ideas, designs, plans and details shown on this document are the sole property of Engineering Resources, Inc. and were created, developed, and presented for use on this specific project. None of the concepts, ideas, designs, plans, or details shall be used, or dissemination of any data herein may be made without the written permission of Engineering Resources, Inc.

**Fort Wayne Airport
JEKCC Infrastructure Improvements
AF25-07**
Fort Wayne, Indiana, 46809

**FORT WAYNE-ALLEN COUNTY
AIRPORT AUTHORITY**


ERI PROJECT NUMBER: 6545
ISSUE DATE: 05.27.2025
CONSTRUCTION DOCUMENTS

REVISIONS		
NO.	DATE	DESCRIPTION
1	06/16/2025	ADDENDUM #1


**SITE PLAN - NORTHWEST
PERIMETER ROAD**

C1.1


June 6, 2025 11:03 AM
S:\Projects\Projects (6000-6999)\Projects (6500-6549)\6545-FWA JEKCC Infrastructure Improvements\Drawings\6545 CL10 Site Demolition & Layout Plan.dwg

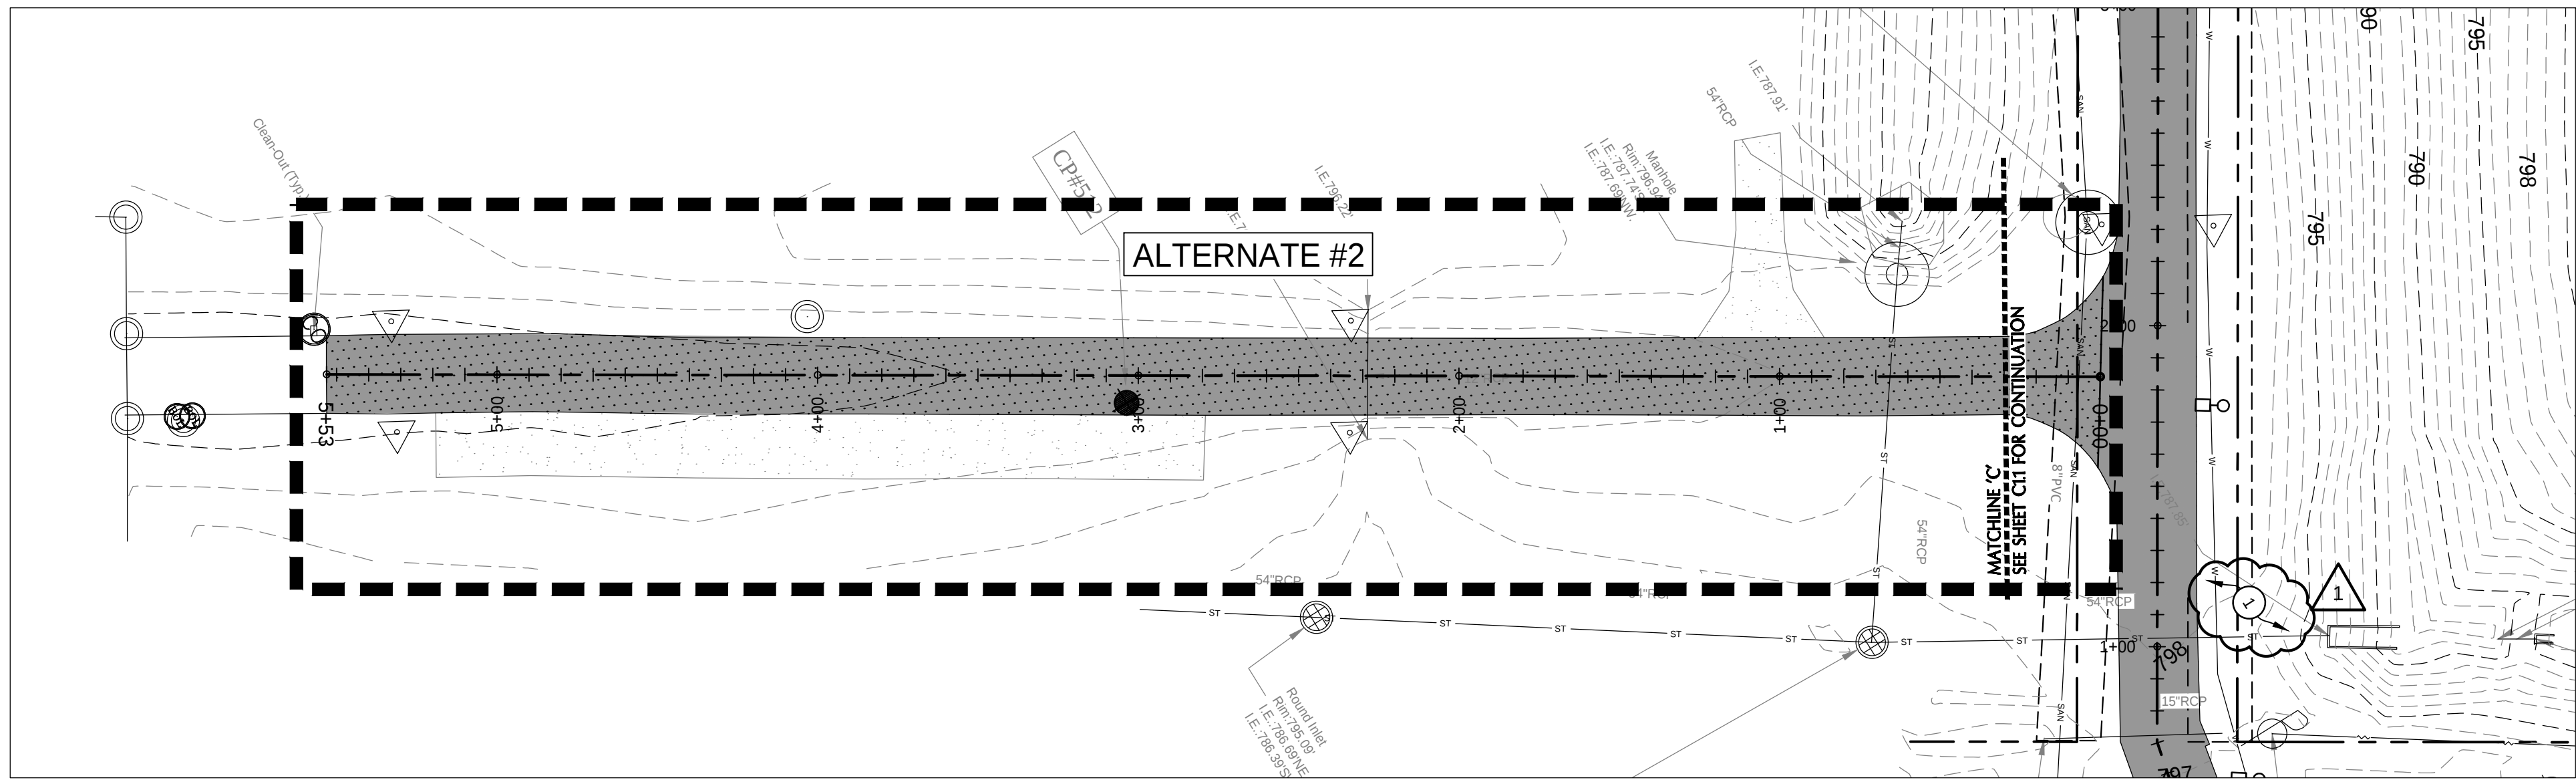

SERVICE ROAD
SCALE: 1" = 40'
NORTH

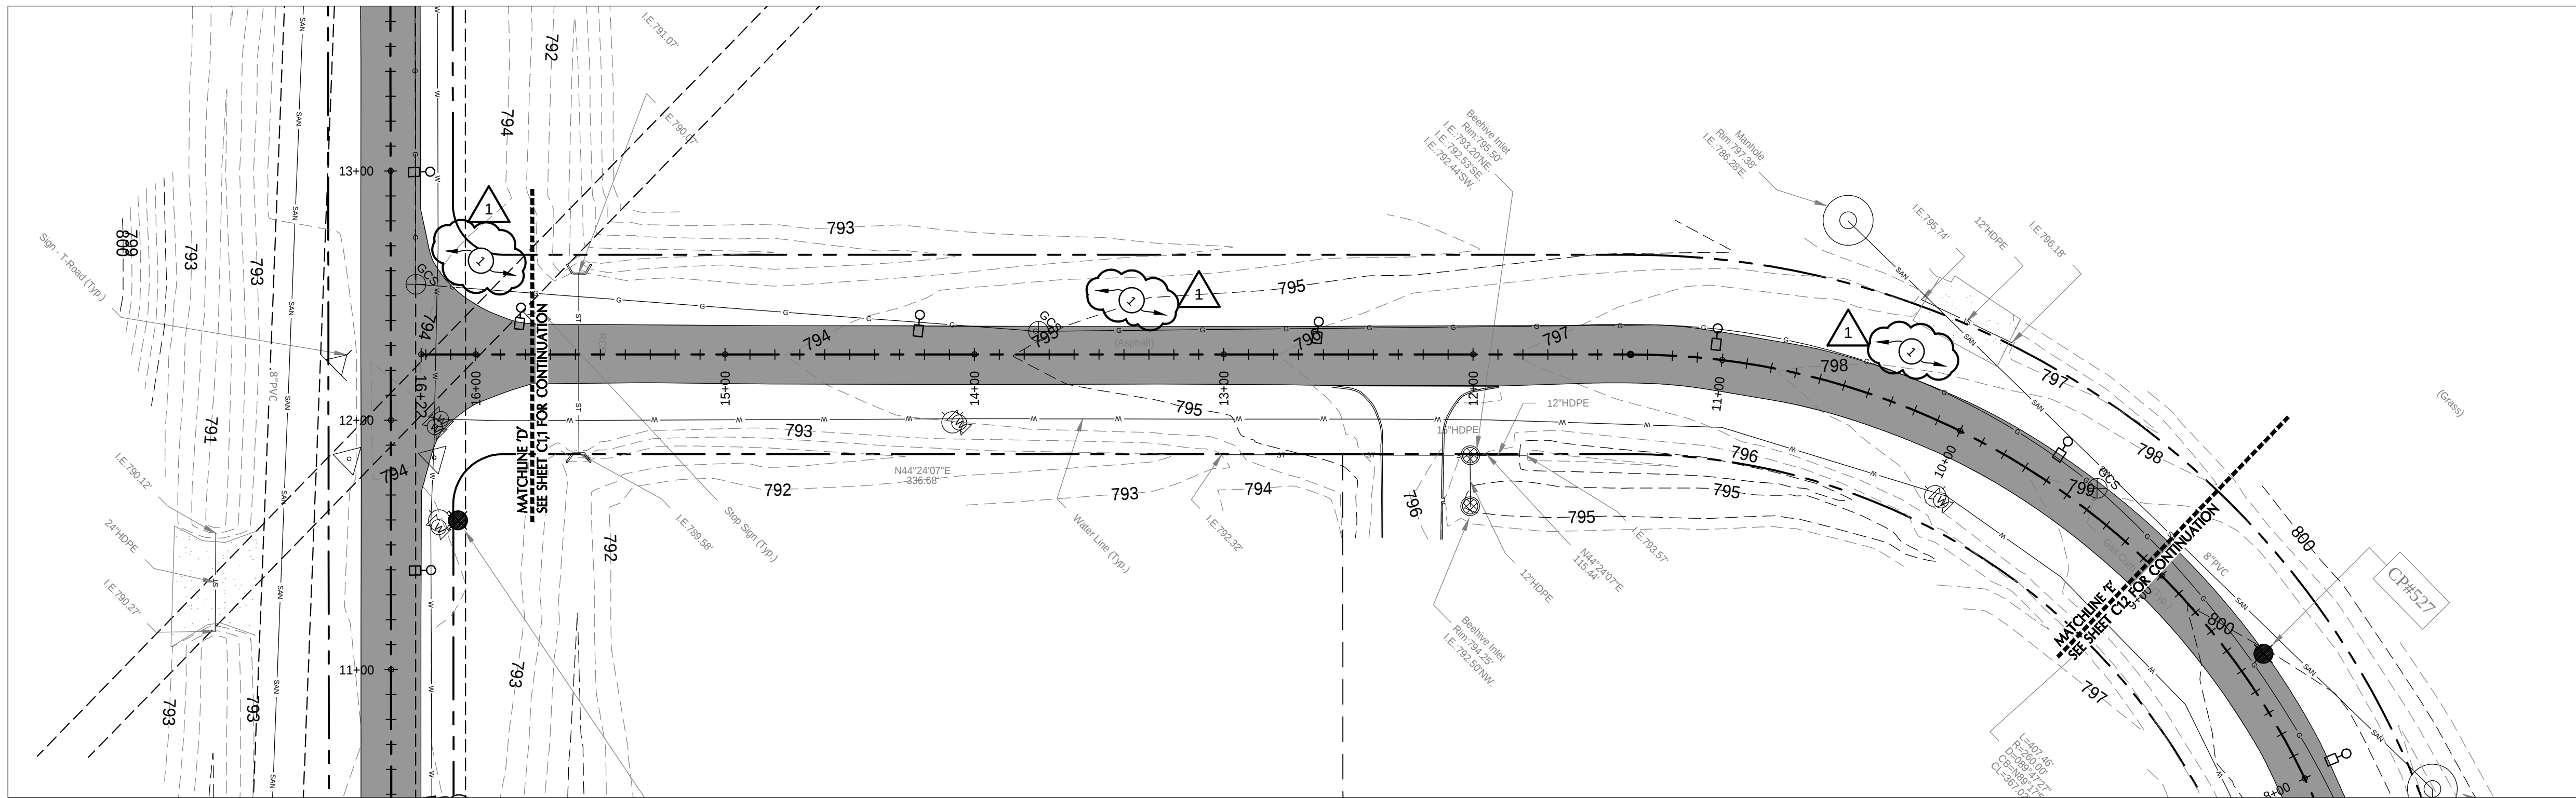

AIRPORT AVENUE - WEST
SCALE: 1" = 40'
NORTH

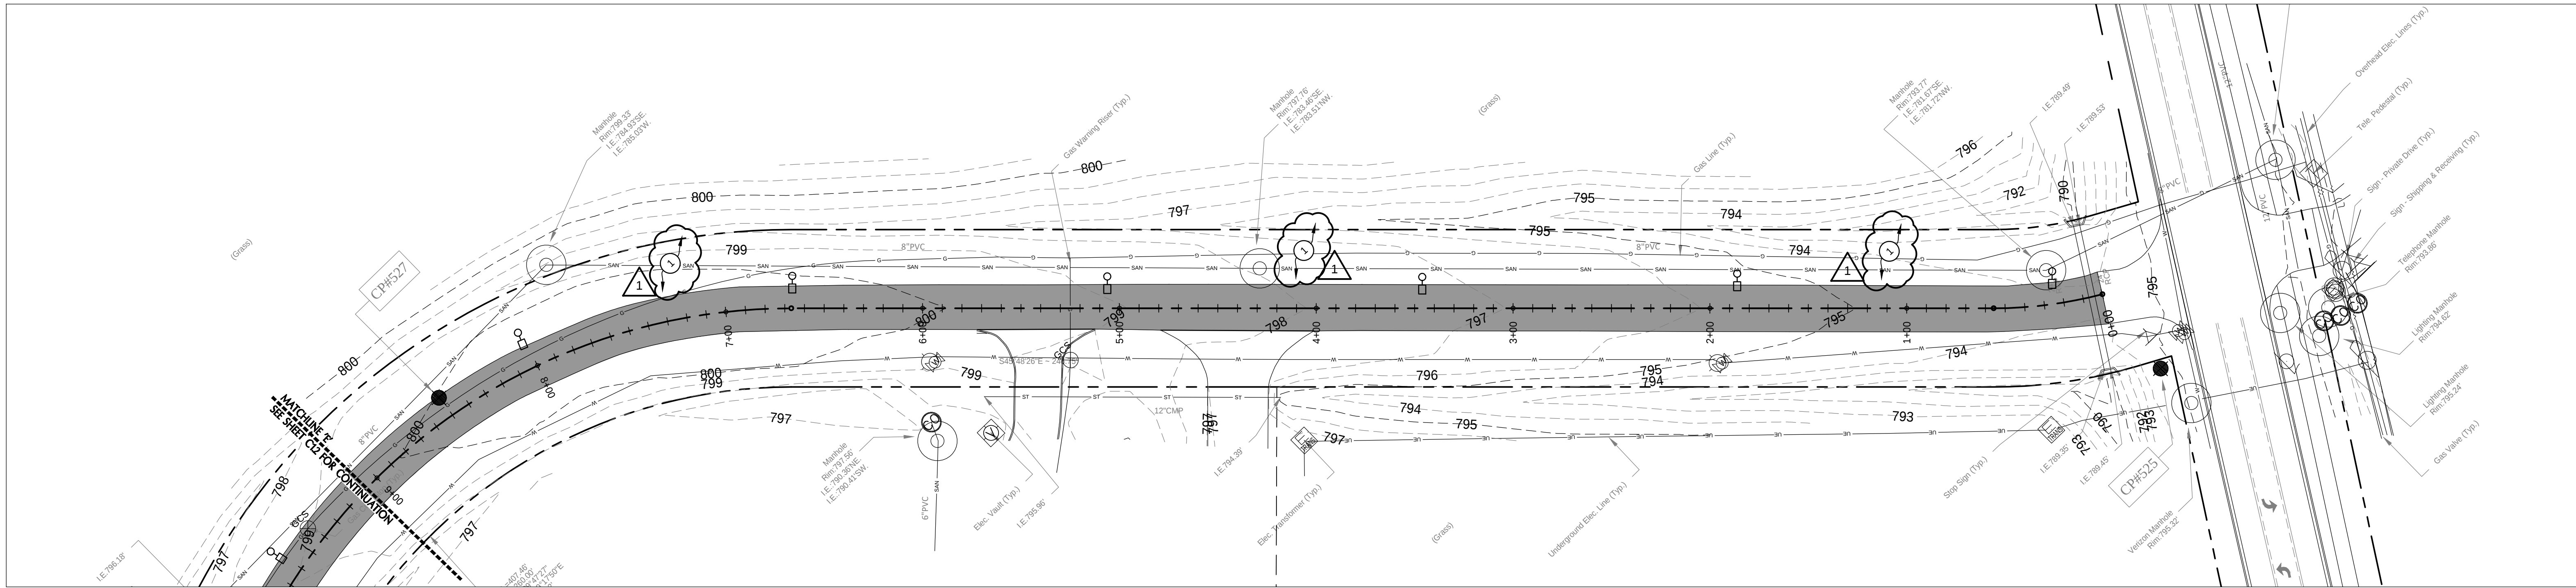


AIRPORT AVENUE - EAST
SCALE: 1" = 40'
NORTH

LAYOUT NOTES:
1 GRASSLANDSCAPE AREA. ALL DISTURBED AREAS TO RECEIVE PERMANENT SEEDING. SEE SPECIFICATIONS SECTION 320200 "LAWNS & GRASSES".


LAYOUT LEGEND:
PAVEMENT MILL AND OVERLAY PER DETAIL #1/C1.2.
ALTERNATE: PAVEMENT MILL AND OVERLAY PER DETAIL #1/C1.2.

NOTE: ALL DIMENSIONS ARE TO FACE OF CURB OR EDGE OF PAVEMENT UNLESS NOTED OTHERWISE.

PROPOSED LEGEND:
LIGHT POLE

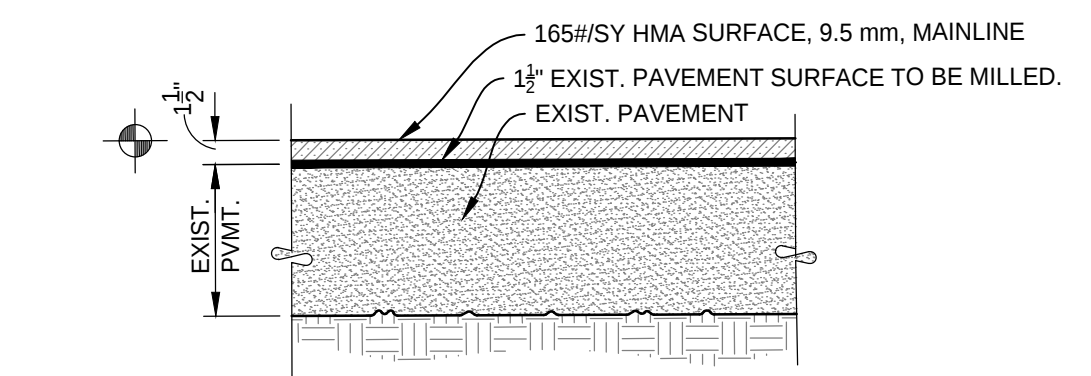

PAVEMENT MILL AND OVERLAY
SCALE: 1" = 1'-0"

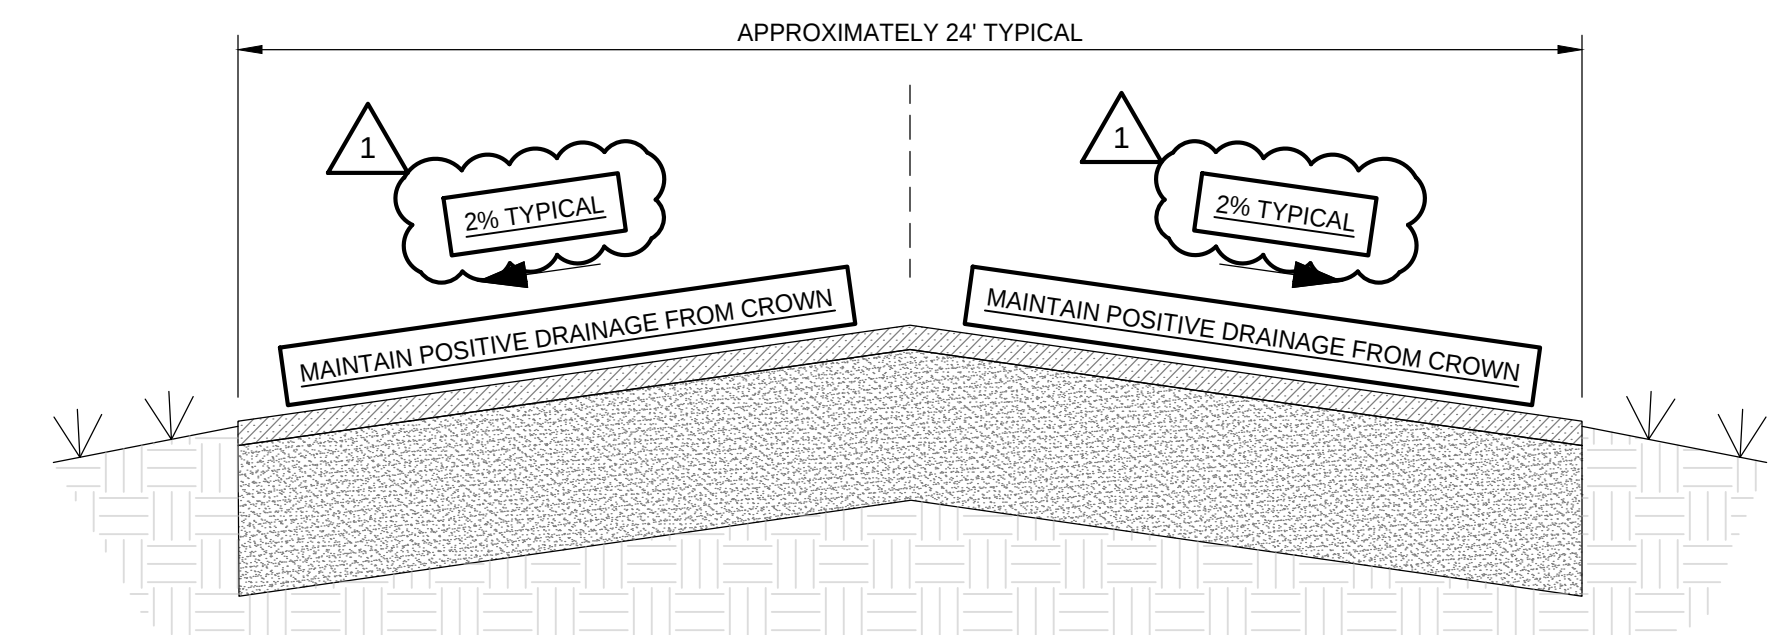

TYPICAL CROSS SECTION
NOT TO SCALE

ENGINEERING RESOURCES, INC.
4175 New Vision Drive, Fort Wayne, IN 46845
Ph: (260) 490-1025 www.eri consulting

05-27-2025

REGISTERED PROFESSIONAL ENGINEER
No. 10911278
STATE OF INDIANA

M. D. R.

The concepts, ideas, designs, plans and details shown on this document are the sole property of Engineering Resources, Inc. and were created, developed, and presented for use on this specific project. None of the concepts, ideas, designs, plans, or details shall be used, or dissemination of any data herein may be made without the written permission of Engineering Resources, Inc.

**Fort Wayne Airport
JEKCC Infrastructure Improvements
AF25-07**
Fort Wayne, Indiana, 46809



ERI PROJECT NUMBER: 6545


ISSUE DATE: 05.27.2025

CONSTRUCTION DOCUMENTS




REVISIONS		
NO.	DATE	DESCRIPTION
1	06/16/2025	ADDENDUM #1

**SITE PLAN - AIRWAY
AVENUE & SERVICE ROAD**


C1.2

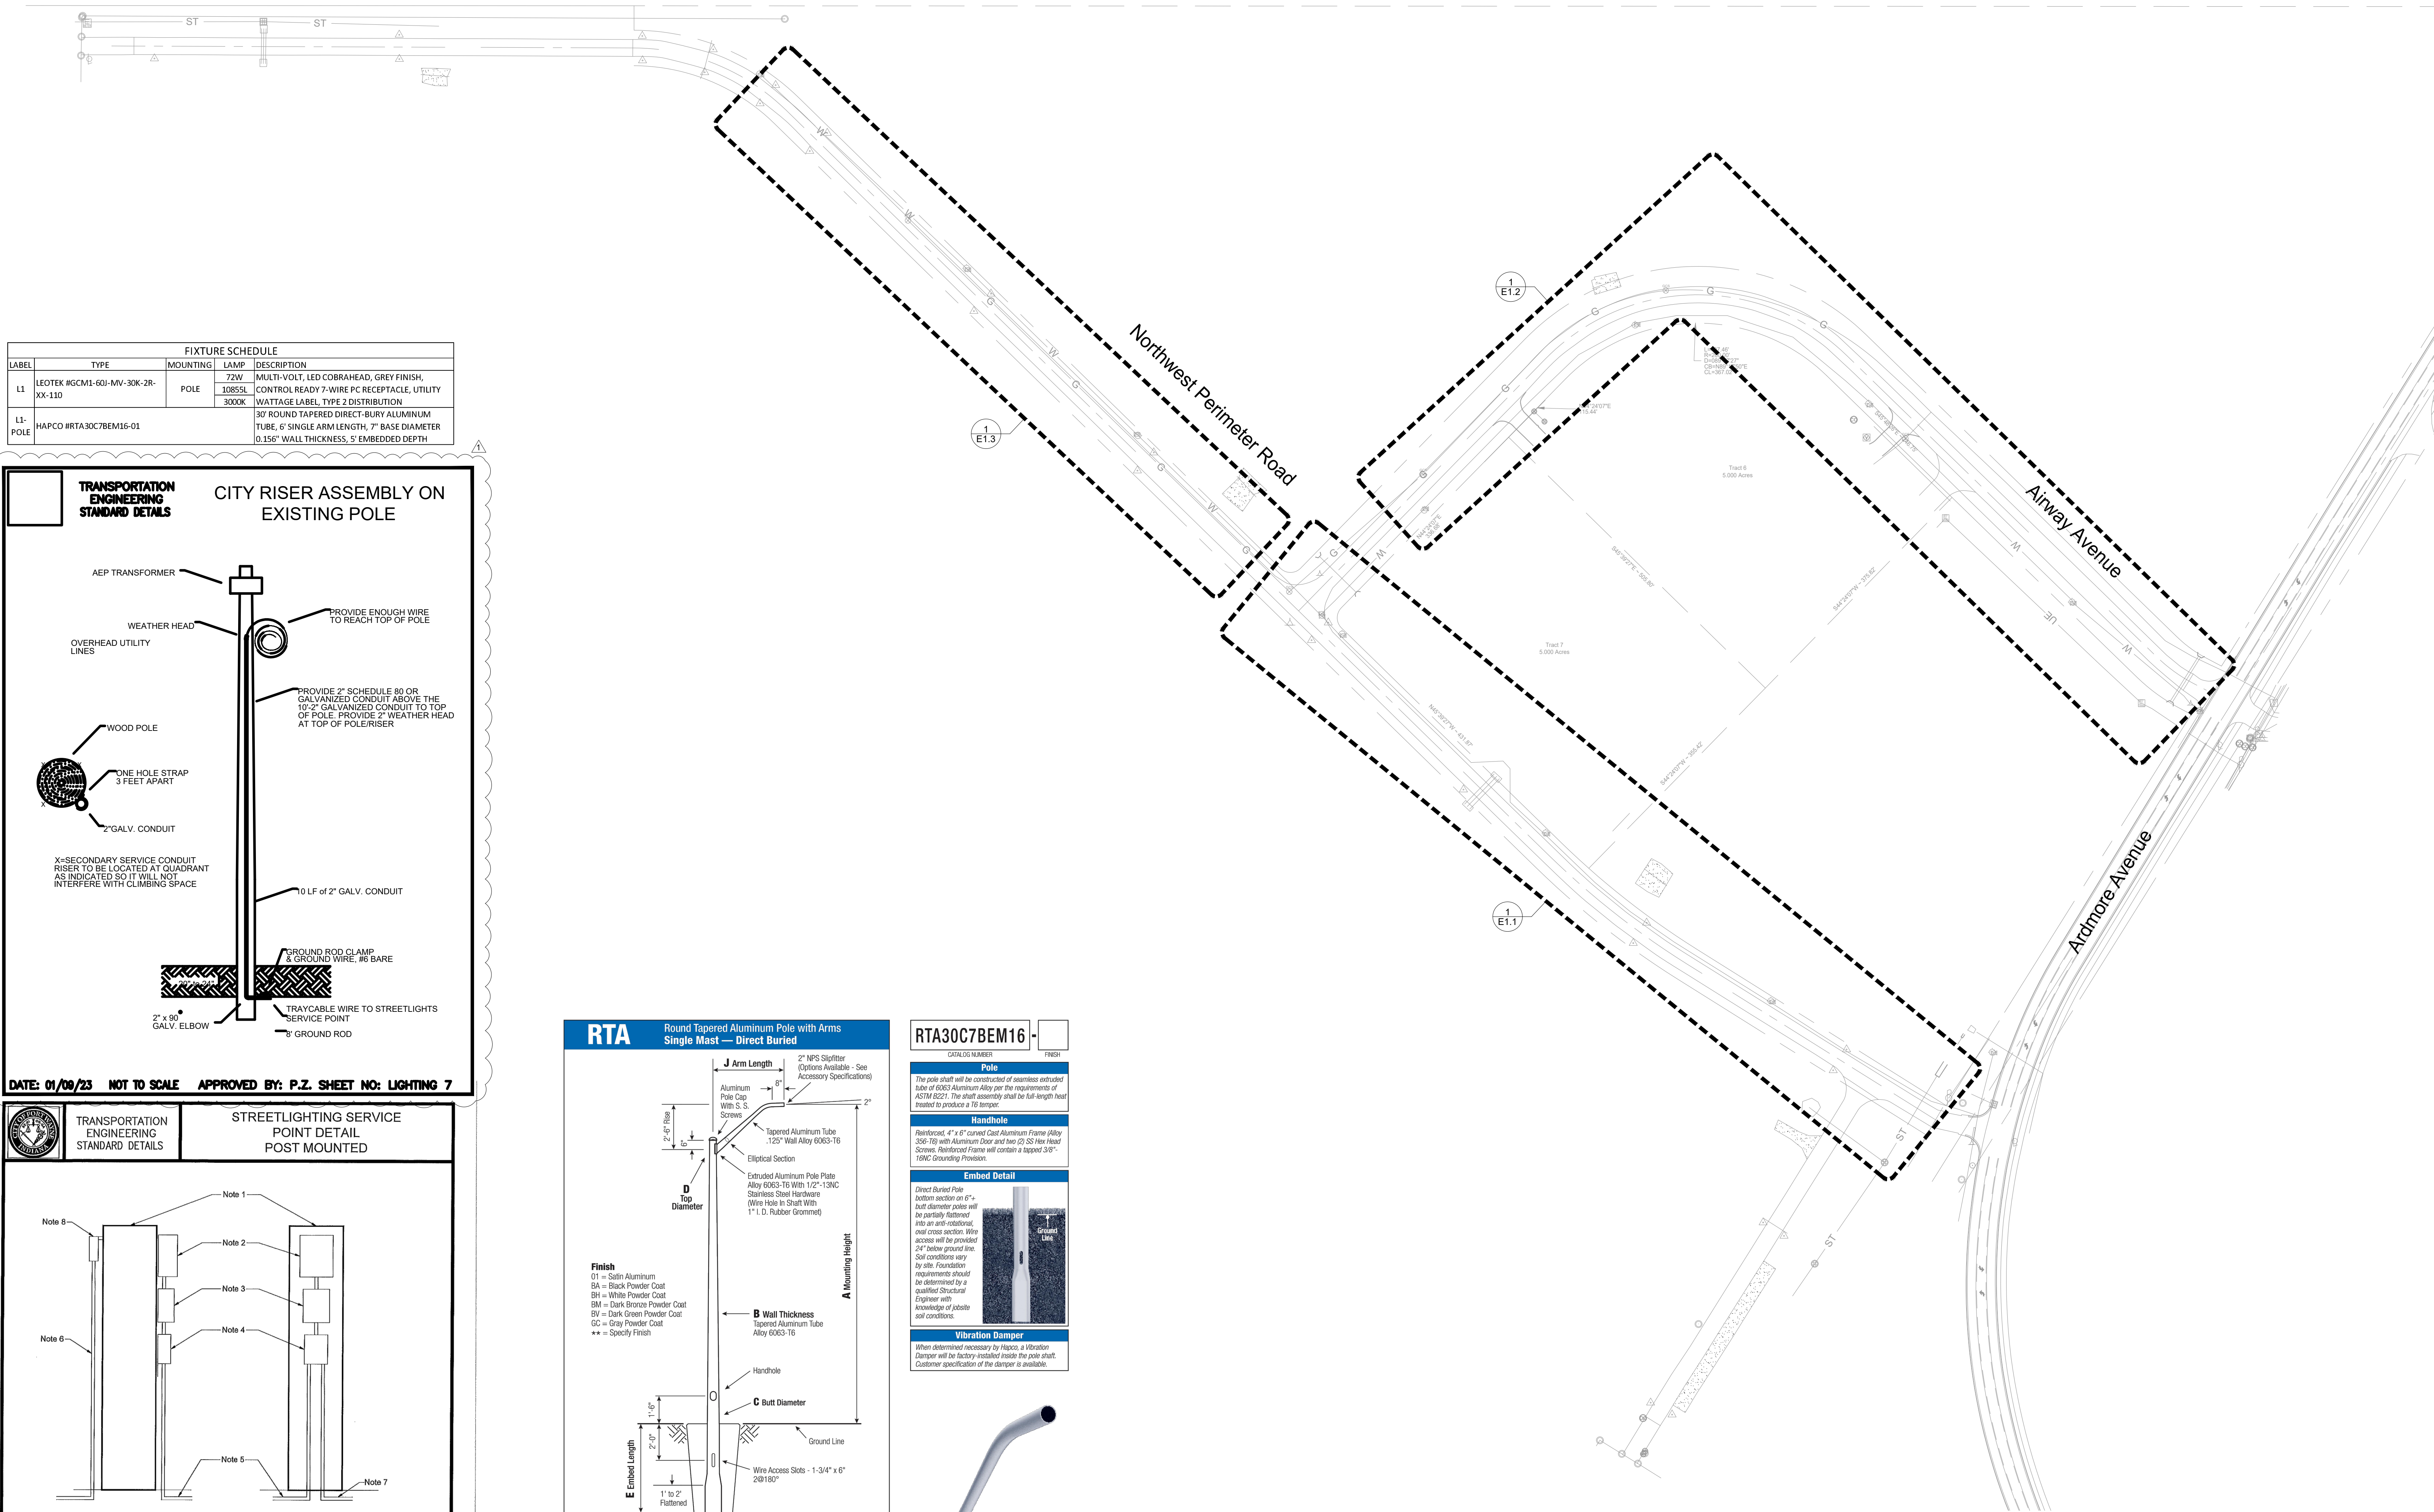


FIXTURE SCHEDULE				
LABEL	TYPE	MOUNTING	LAMP	DESCRIPTION
L1	LEOTEK #60CM1-60-MV-30K-2R-XX-110	POLE	72W 3000K	MULTI-VOLT, LED COBRAHEAD, GREY FINISH, CONTROL READY 7-WIRE PC RECEPTACLE, UTILITY WATTAGE LABEL, TYPE 2 DISTRIBUTION
L1-POLE	HAPCO #RTA30C7BEM16-01			30" ROUND TAPERED DIRECT-BURY ALUMINUM TUBE, 6" SINGLE ARM LENGTH, 7" BASE DIAMETER (0.156" WALL THICKNESS, 5' EMBEDDED DEPTH)

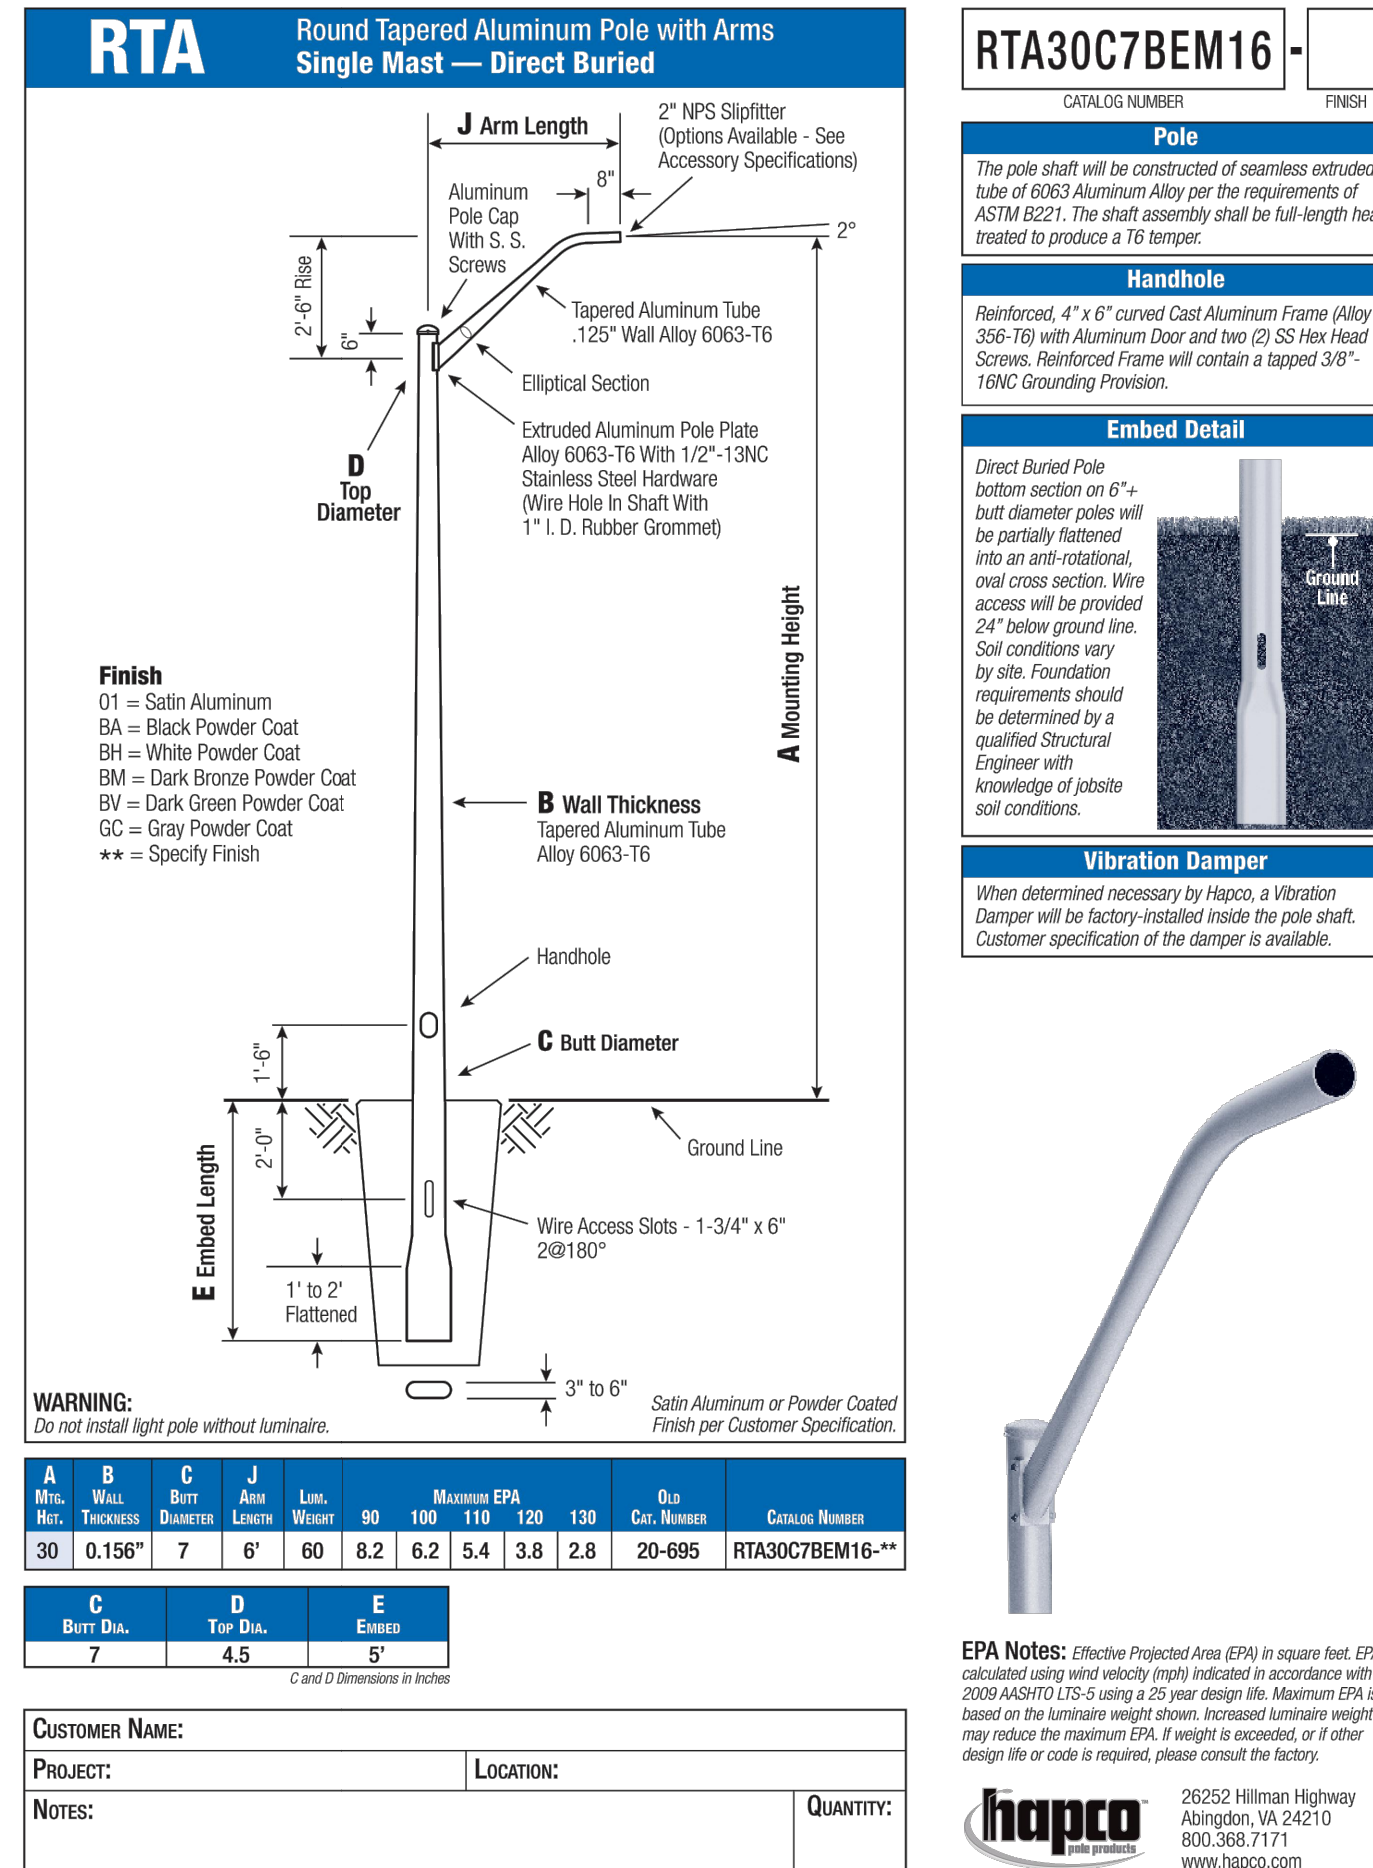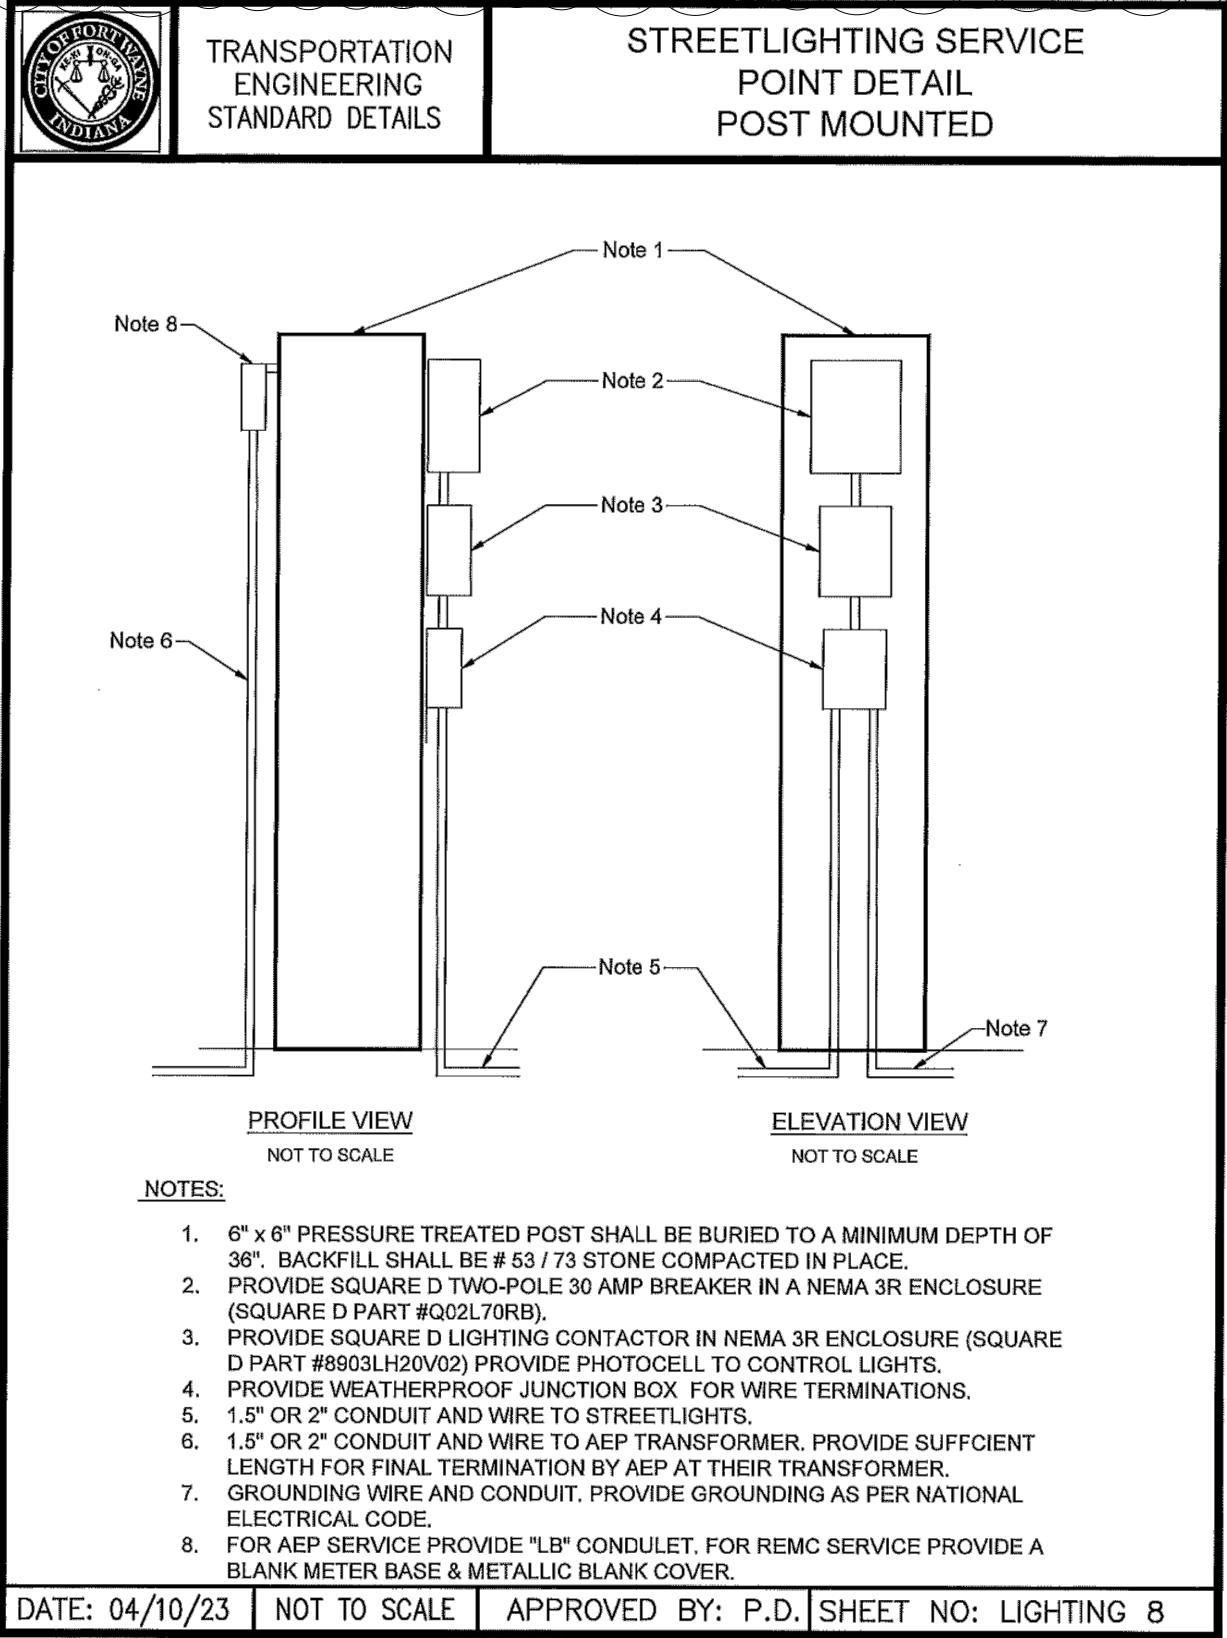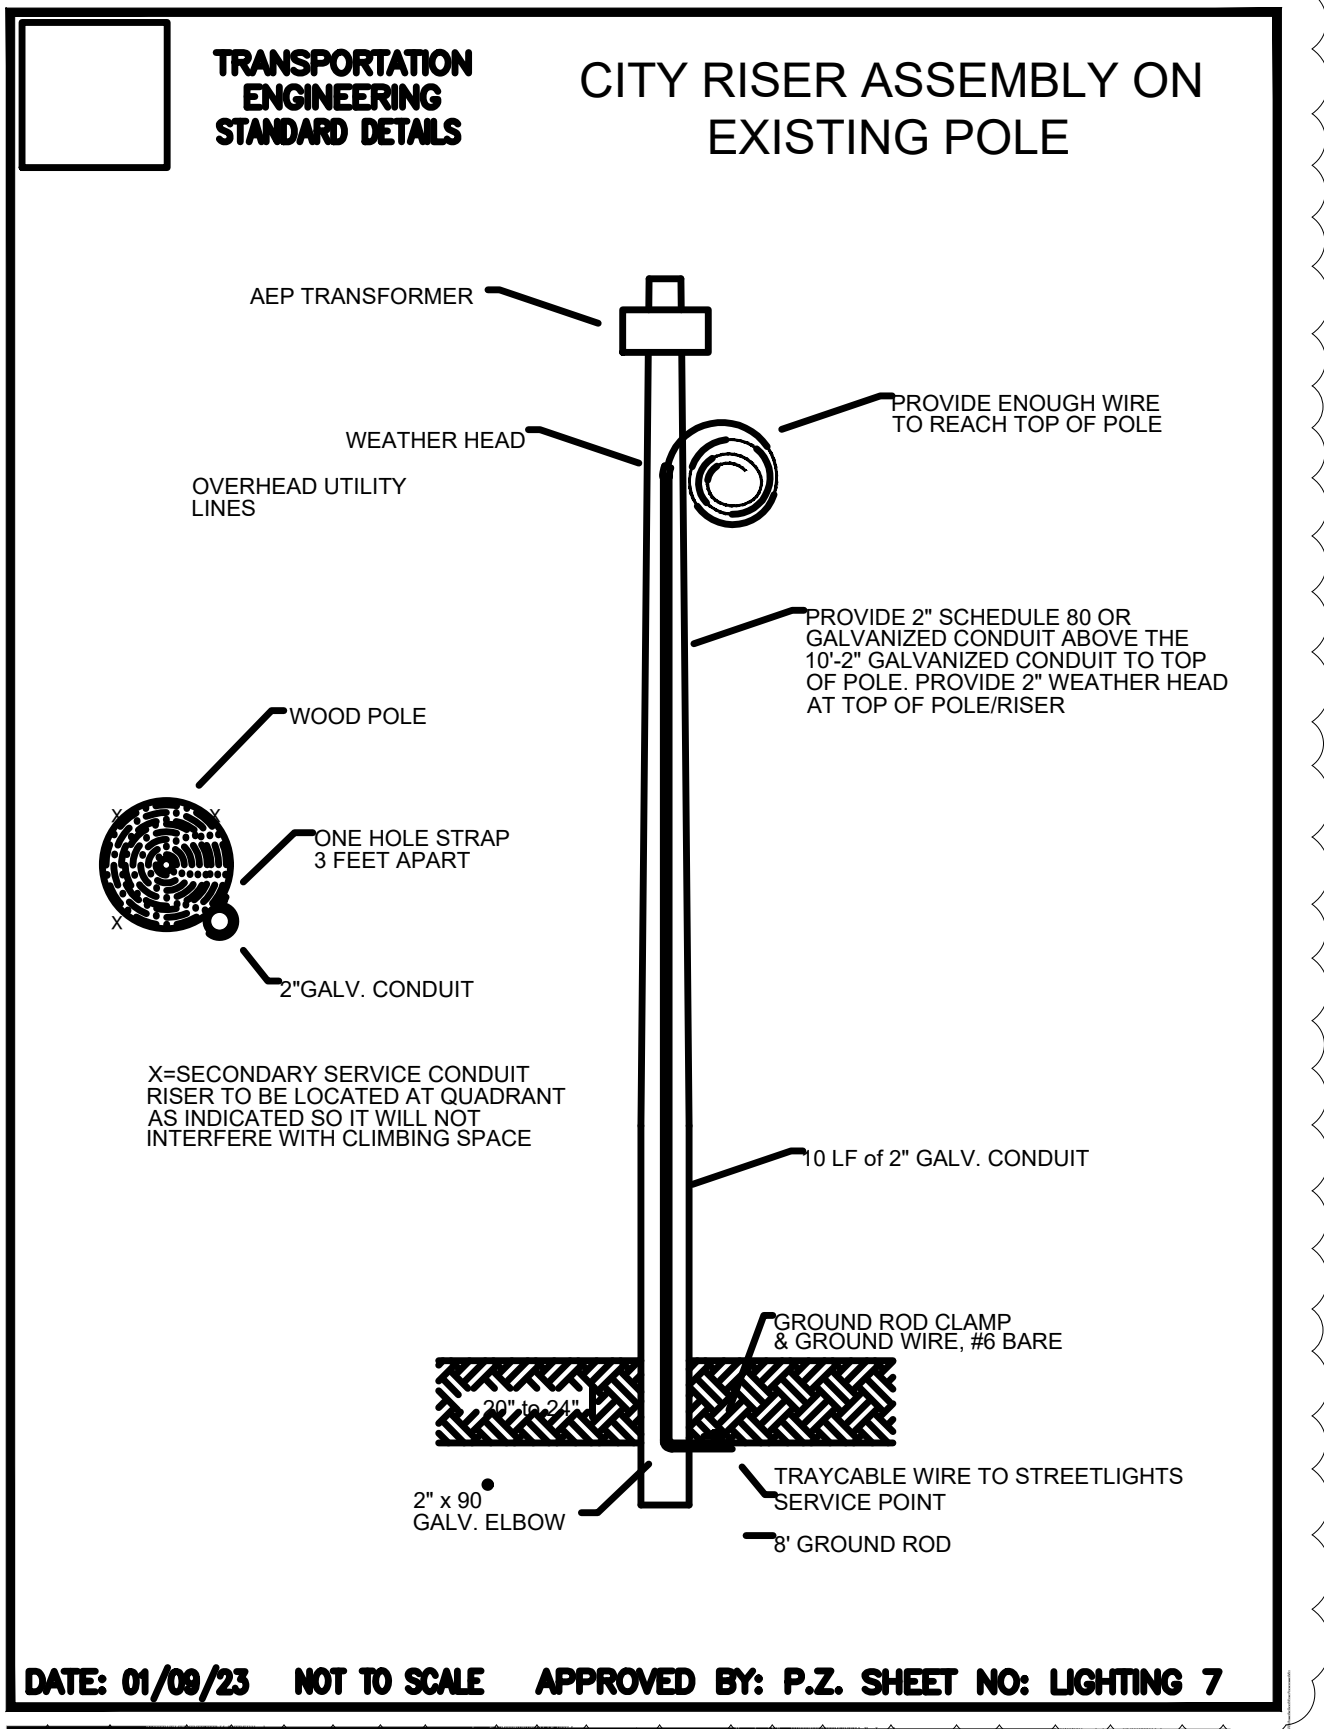

June 12, 2025 11:03 AM
C:\CH Engineering\Projects\2025 Projects\FW Airport Drive Repair\Drawings\PS5093_E1.dwg

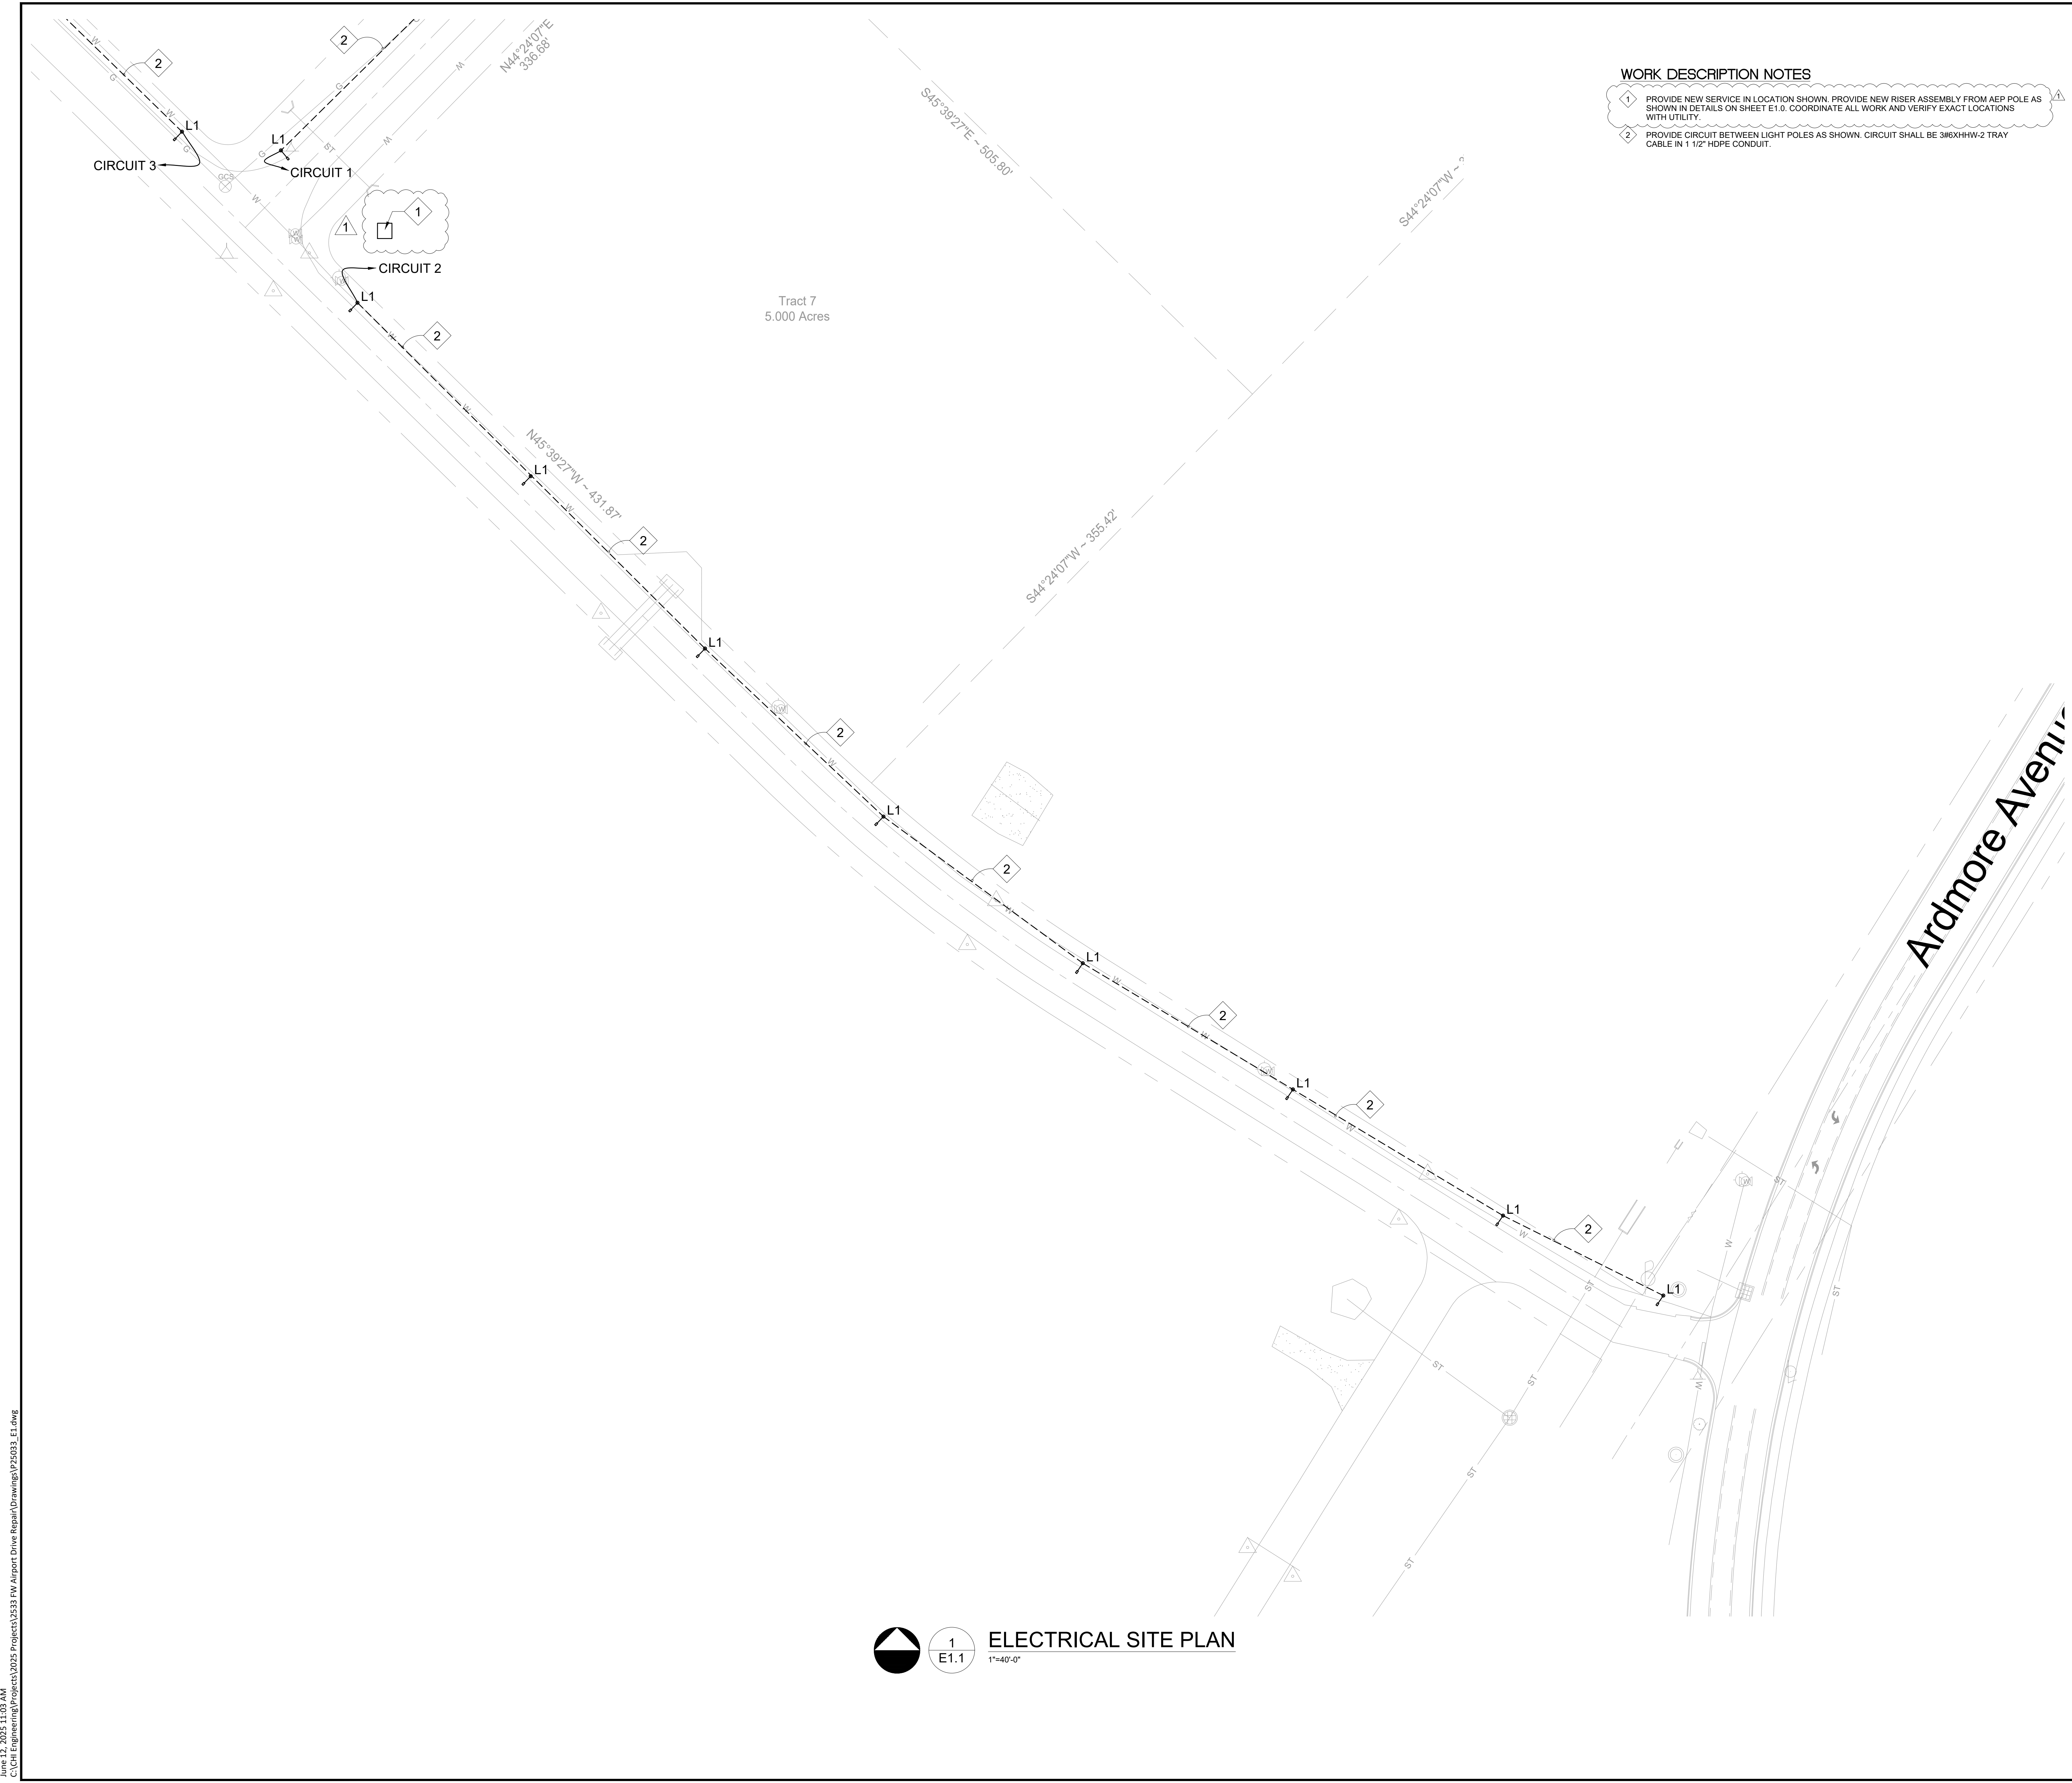


- WORK DESCRIPTION NOTES**
- 1 PROVIDE NEW SERVICE IN LOCATION SHOWN. PROVIDE NEW RISER ASSEMBLY FROM AEP POLE AS SHOWN IN DETAILS ON SHEET E1.0. COORDINATE ALL WORK AND VERIFY EXACT LOCATIONS WITH UTILITY.
 - 2 PROVIDE CIRCUIT BETWEEN LIGHT POLES AS SHOWN. CIRCUIT SHALL BE 3#6XHHW-2 TRAY CABLE IN 1 1/2\"/>

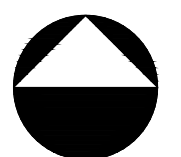 **1**
E1.1
ELECTRICAL SITE PLAN
1\"/>



**ENGINEERING
RESOURCES, INC.**
4175 New Vision Drive, Fort Wayne, IN 46845
Ph: (260) 490-1025 www.eri.consulting

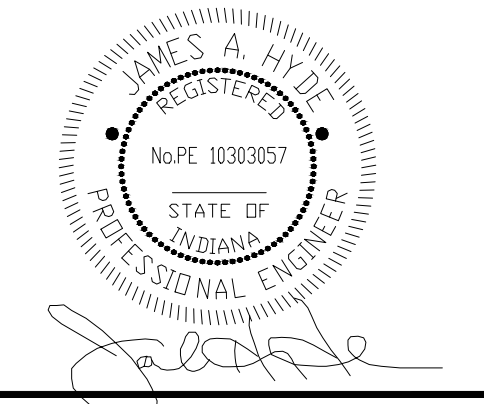

THE CONCEPTS, IDEAS, DESIGN, PLANS AND DETAILS SHOWN ON THIS DOCUMENT ARE THE SOLE PROPERTY OF ENGINEERING RESOURCES, INC., AND WERE CREATED, DEVELOPED, AND PREPARED FOR USE ON THIS SPECIFIC PROJECT. NONE OF THE CONCEPTS, IDEAS, DESIGN, PLANS, OR DETAILS SHALL BE USED, OR DISSEMINATED, IN ANY MANNER WITHOUT THE WRITTEN PERMISSION OF ENGINEERING RESOURCES, INC.




13313 DOLORETTO DOVE
FORT WAYNE, IN 46845
PHONE: 260-490-0501

**Fort Wayne Airport
JEKCC Infrastructure Improvements
AF25-07**
Fort Wayne, Indiana, 46809




**FORT WAYNE-ALLEN COUNTY
AIRPORT AUTHORITY**

ERI PROJECT NUMBER: 6545		
ISSUE DATE: 05.27.2025		
CONSTRUCTION DOCUMENTS		
REVISIONS		
NO.	DATE	DESCRIPTION
1	12JUN2025	ADDENDUM 1

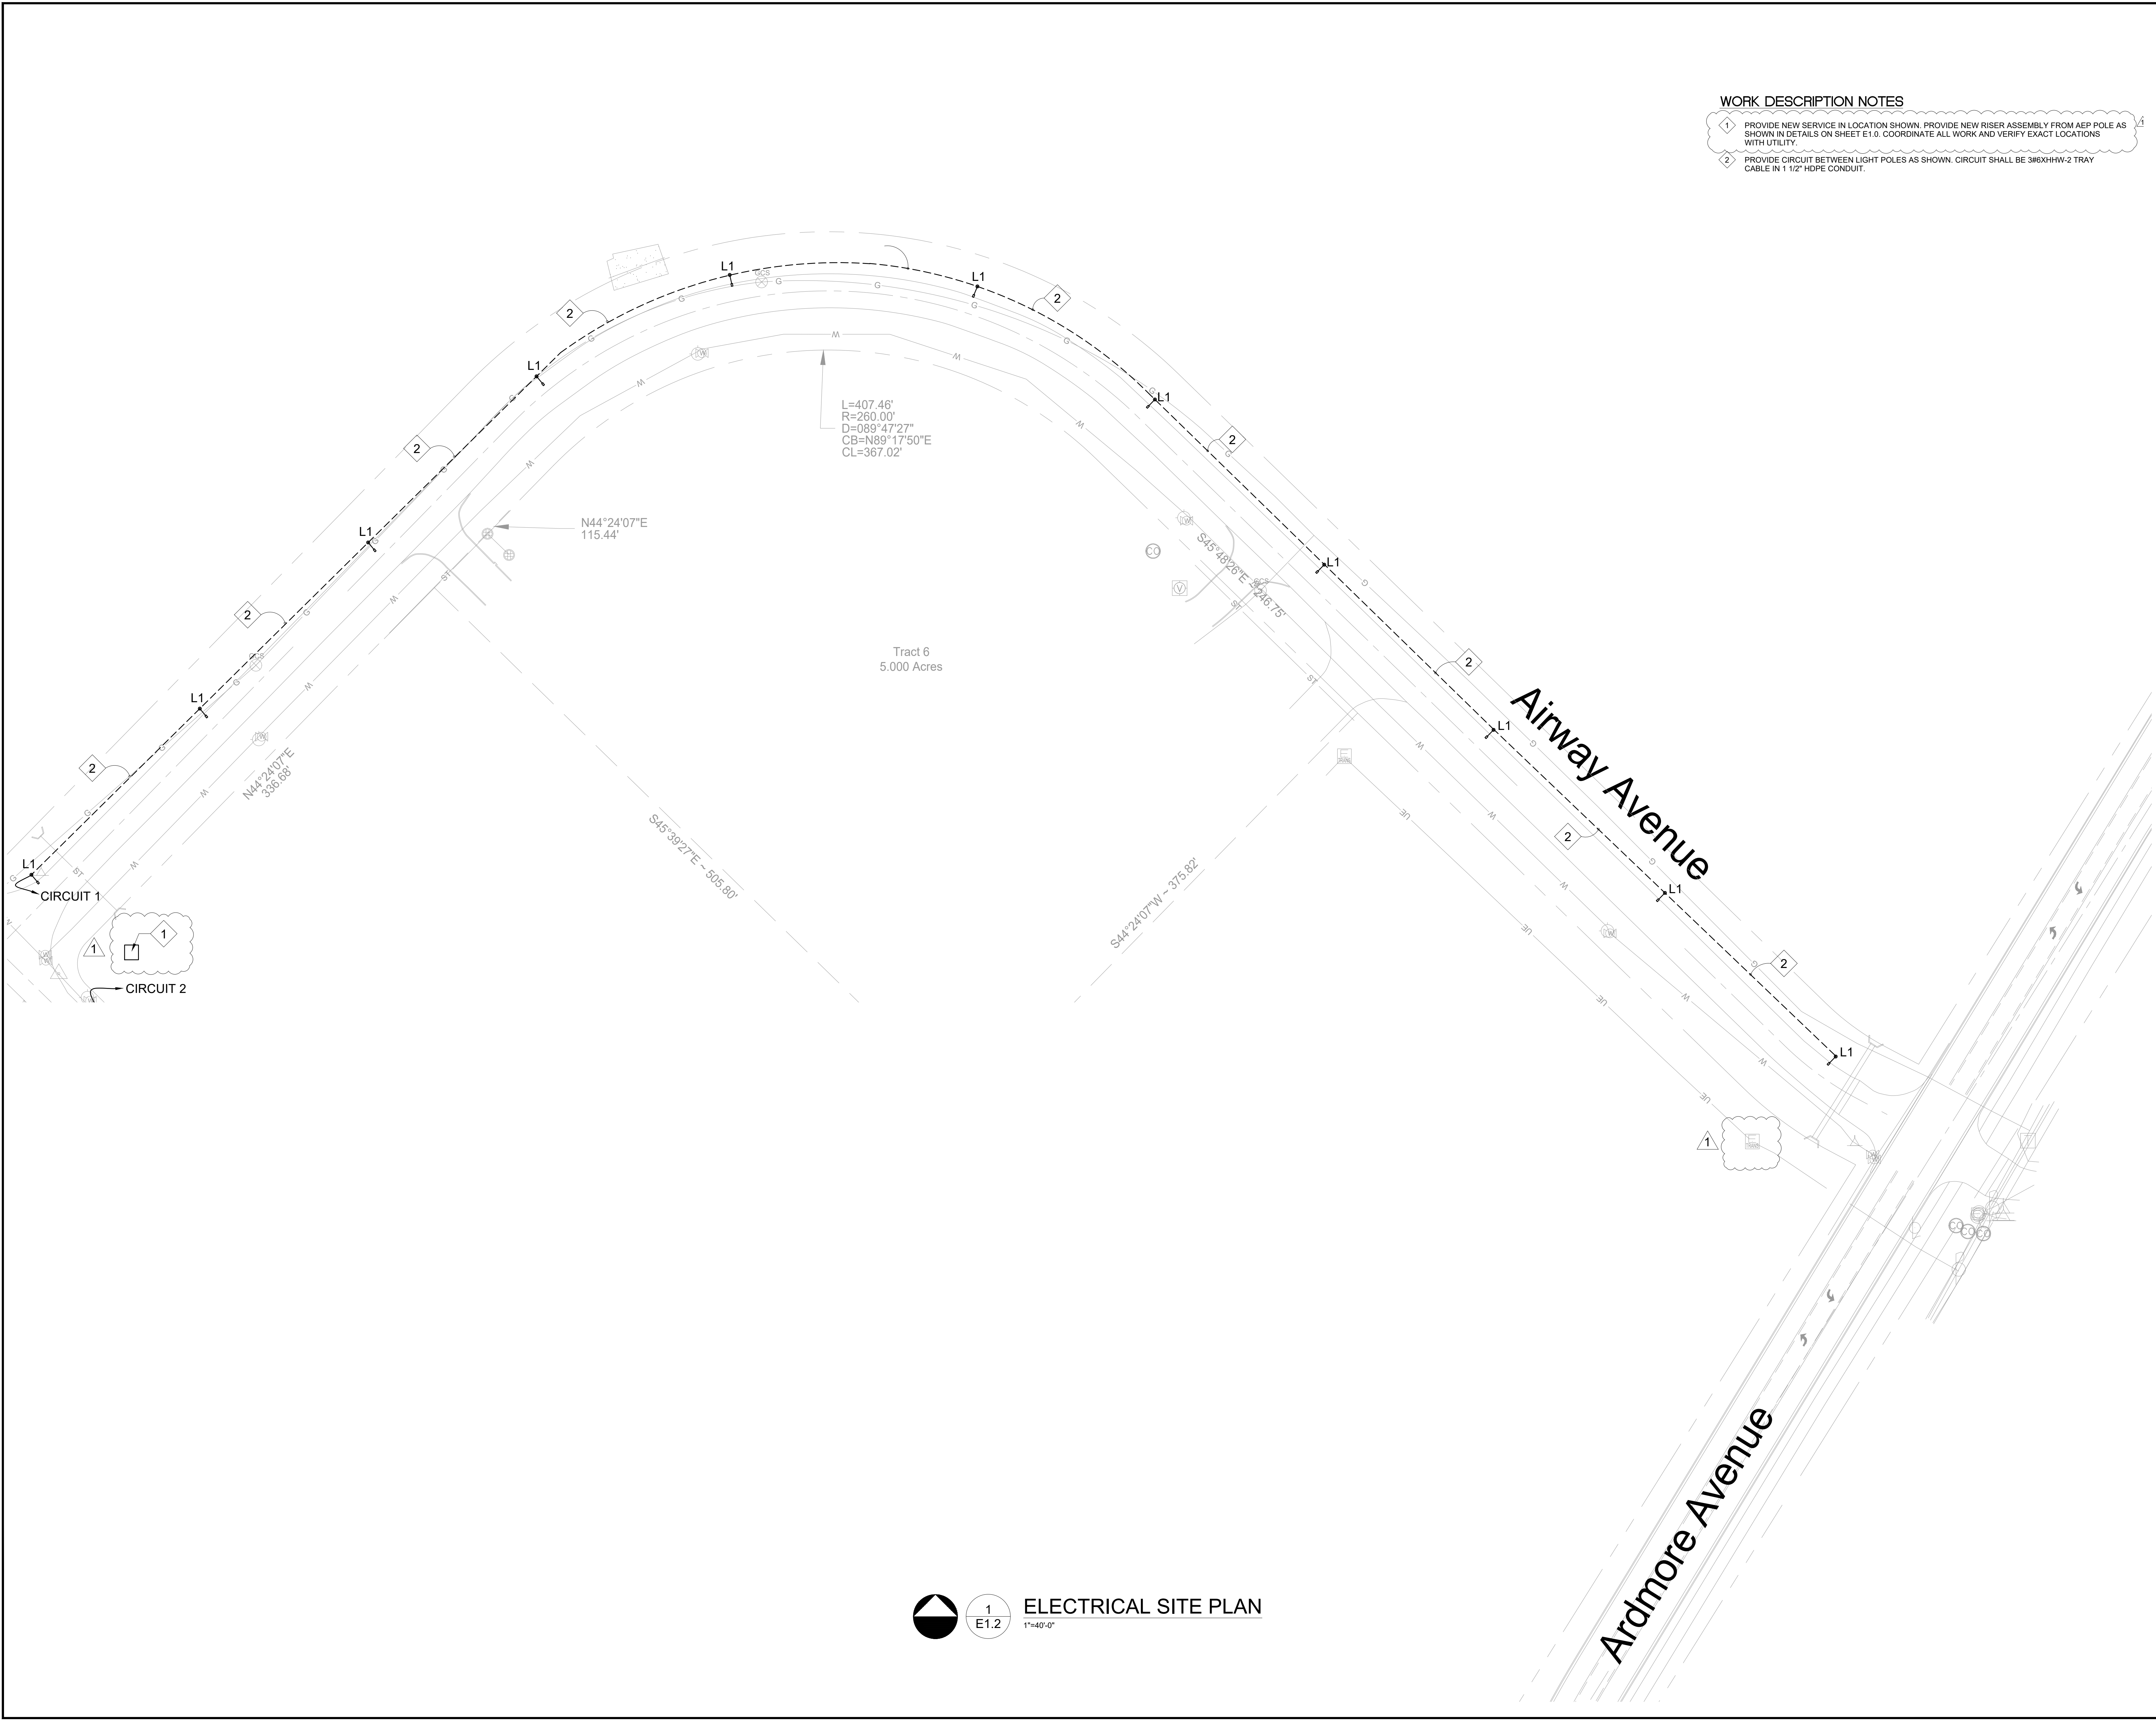

WORK DESCRIPTION NOTES

- 1 PROVIDE NEW SERVICE IN LOCATION SHOWN. PROVIDE NEW RISER ASSEMBLY FROM AEP POLE AS SHOWN IN DETAILS ON SHEET E1.0. COORDINATE ALL WORK AND VERIFY EXACT LOCATIONS WITH UTILITY.
- 2 PROVIDE CIRCUIT BETWEEN LIGHT POLES AS SHOWN. CIRCUIT SHALL BE 3#6XHHW-2 TRAY CABLE IN 1 1/2\"/>

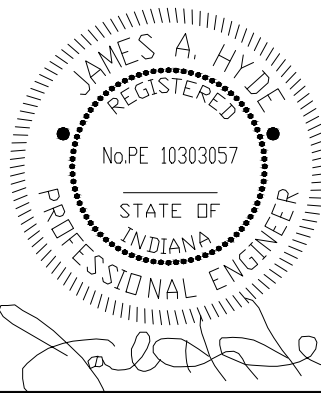

The concepts, ideas, designs, plans and details shown on this document are the sole property of Engineering Resources, Inc. and were created, developed, and presented for use on this specific project. None of the concepts, ideas, designs, plans, or details shall be used, or dissemination of any data herein may be made without the written permission of Engineering Resources, Inc.

CH ENGINEERING
CONSULTANTS

13313 DOLOMETTO COVE
FORT WAYNE, IN 46845
PHONE: 260-490-0501

**Fort Wayne Airport
JEKCC Infrastructure Improvements
AF25-07**

Fort Wayne, Indiana, 46809



ERI PROJECT NUMBER: 6545

ISSUE DATE: 05.27.2025

CONSTRUCTION DOCUMENTS

REVISIONS		
NO.	DATE	DESCRIPTION
1	12JUN2025	ADDENDUM 1

ELECTRICAL SITE PLAN

E1.2





1
E1.2

ELECTRICAL SITE PLAN

1"=40'-0"


June 12, 2025 11:03 AM
C:\CH Engineering\Projects\2025 Projects\FW Airport Drive Repair\Drawings\25093_E1.dwg

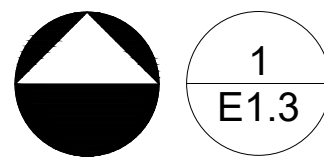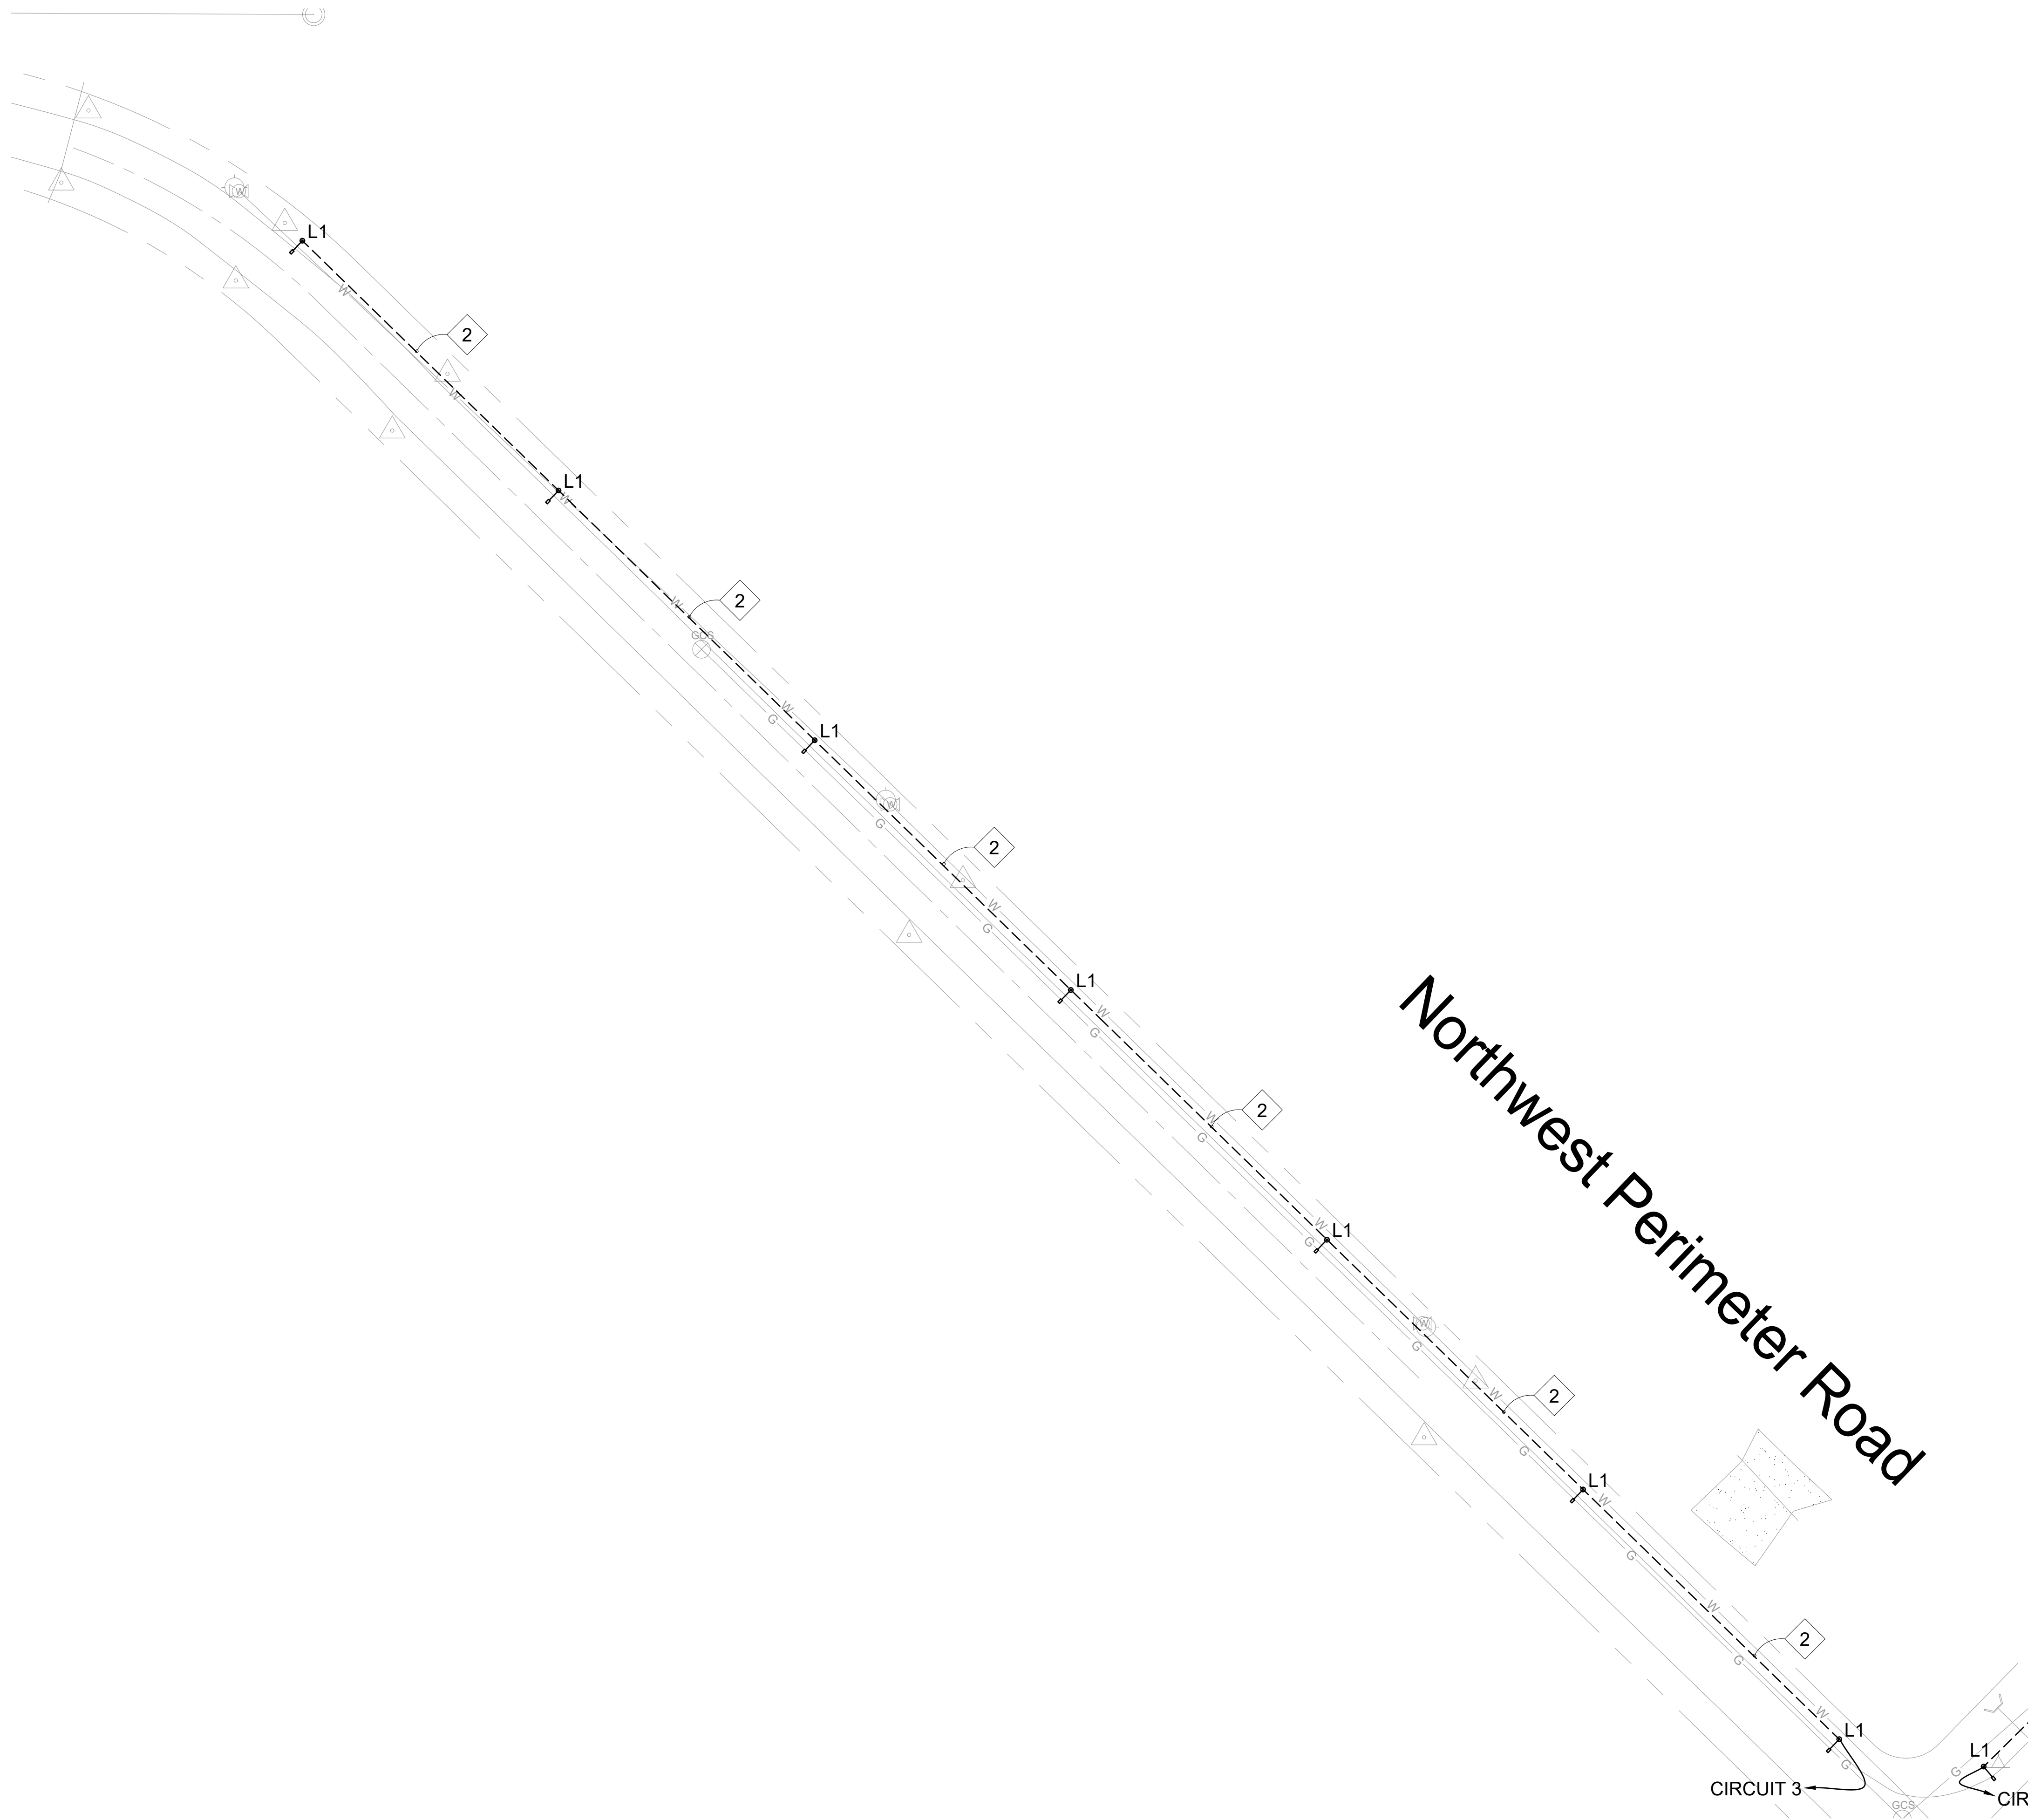

ELECTRICAL SITE PLAN

WORK DESCRIPTION NOTES

- 1 PROVIDE NEW SERVICE IN LOCATION SHOWN. PROVIDE NEW RISER ASSEMBLY FROM AEP POLE AS SHOWN IN DETAILS ON SHEET E1.0. COORDINATE ALL WORK AND VERIFY EXACT LOCATIONS WITH UTILITY.
- 2 PROVIDE CIRCUIT BETWEEN LIGHT POLES AS SHOWN. CIRCUIT SHALL BE 3/8XHHW-2 TRAY CABLE IN 1 1/2" HDPE CONDUIT.

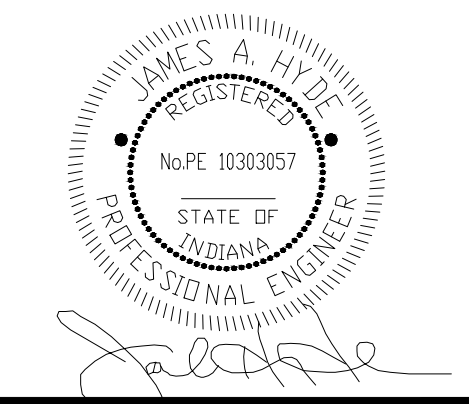

The concepts, ideas, designs, plans and details shown on this document are the sole property of Engineering Resources, Inc. and were created, developed, and presented for use on this specific project. None of the concepts, ideas, designs, plans, or details shall be used, or dissemination of any data herein may be made without the written permission of Engineering Resources, Inc.

CH ENGINEERING
CONSULTANTS
13313 DOLOMETTO DOVE
FORT WAYNE, IN 46845
PHONE: 260-490-5501

**Fort Wayne Airport
JEKCC Infrastructure Improvements
AF25-07**
Fort Wayne, Indiana, 46809



ERI PROJECT NUMBER: 6545

ISSUE DATE: 05.27.2025

CONSTRUCTION DOCUMENTS

REVISIONS		
NO.	DATE	DESCRIPTION
1	12JUN2025	ADDENDUM 1

ELECTRICAL SITE PLAN

E1.3