

ADDENDUM NO. 18

Date: 10.07.2025

Project:

**Westfield Washington School Corporation
Centennial Road Reconstruction
Bid Package 05
17707 Centennial Road,
Westfield, IN. 46074**

Owner:

**C/O Westfield Washington School Corporation
19500 Tomlinson Road
Westfield, IN 46074**



Construction Manager:

**Hagerman, Inc
10315 Allisonville Road
Fishers, IN 46038**

TO: All Interested Bidders of Record

This Addendum #18, Dated 10.07.2024, forms part of the contract documents and modifies the original Bidding Documents Dated 09.15.2025. Please acknowledge receipt of this Addendum in the space provided on the Bid Form. Failure to acknowledge this Addendum may subject the Bidder to disqualification.

The Hagerman, Inc portion of this Addendum consists of the following information:

I. GENERAL INFORMATION

1. This is for Addendum #18 Dated 10.07.2025. (Please note this is really Addendum #01 for the Centennial Road Reconstruction Project but is sequentially Addendum #18 on the overall Westfield Washington School New Middle School West Project, so we will refer to it as Addendum #18).
2. A Pre-bid meeting was held on 10.01.2025 at 11:00 am for this project at the Schools Administration Building. This was a non-mandatory pre-bid meeting, but all contractors and vendors were encouraged to attend. Contractors were able to ask questions to the CMc and the A-F Civil Engineer at this meeting and those answers have been

incorporated into this Addendum #18. All Contractors were invited to perform a field walk to review the existing conditions of Centennial Road after the meeting. At this meeting Hagerman Inc the CMc reviewed the Bid Advertisement, the Instructions to Bidders, the Scope Bids Section 00 24 00, Bid Form, Project Schedule, and Site Logistic Plan. A copy of the Pre-Bid Meeting Sign in Sheet is attached for reference.

II. CHANGES TO THE PROJECT CONTRACT MANUAL

1. All contractors shall review the attached CSO and A&F Engineering Addendum #18 Dated 10.07.2024 and incorporate the changes made to the drawings and specifications into the respective bid item scope of bid.
2. All Bidders shall review the updated Section 00 01 15 List of Drawings.
3. All Bidders can refer to the Quantities sheet that was supplied by the Engineer, but the Contractors are responsible for their own quantity take offs and estimate and bid quantities.
4. Bid Item 32 CRR Contractor shall amend Scope of Bid Item #24 to read Per Note 25 instead of Note 26, since 26 has been omitted.
5. Bid Item 32 CRR Contractor shall amend Scope of Bid Item #31 to read Per Note 25 instead of Note 26, since 26 has been omitted.
6. Bid Item 32 CRR Contractor shall amend Scope of Bid Item #32 to read Per Note 25 instead of Note 26, since 26 has been omitted.

III. DESIGN INFORMATION

1. CSO, and A&F Engineering Addendum #18 Dated 10.07.2025.

END OF SECTION

ADDENDUM

ADDENDUM NO: 18

PROJECT: Westfield Middle School – West

PROJECT NO: 2023061

DATE: October 07, 2025

BY: Brent Hite



This Addendum is issued in accordance with the provisions of "The General Conditions of the Contract for Construction," Article 1, "Contract Documents" and becomes a part of the Contract Documents as provided therein. This Addendum includes:

Addendum Pages: **1-2**

Attached Documents: Quantities

Attached Drawing Sheets: 2, 3, 10, 12, 14, 16, 17, 24, 25, 27-48

PART 1 - GENERAL INFORMATION

1.1 Quantities

- A. See attached sheet

PART 2 - BIDDING REQUIREMENTS

2.1 NOT USED

PART 3 - SPECIFICATIONS

3.1 NOT USED

PART 4 - DRAWINGS

4.1 SHEET 2 – INDEX AND GENERAL NOTES

- A. Reissue attached sheet

4.2 SHEET 3 – TYPICAL SECTIONS

- A. Updated shoulder width, Updated legend

4.3 SHEET 10 - PLAN - LINE "PR-B" STA. 10+00.00 TO STA. 16+00.00

- A. Updated Str. 11A, Added detail notes to box culvert and casting

4.4 SHEET 12 - PLAN - LINE "PR-B" 16+00.00 to 22+00.00

- A. Added "Attach to Pipe By Others" note to Str. 16, Removed extra pavement line, updated legend

- 4.5 SHEET 14 - PLAN - LINE "PR-B" 22+00.00 to 28+00.00
- A. Added "Attach to Pipe By Others" note to Str. 17, updated legend
- 4.6 SHEET 16 - PLAN - LINE "PR-A" STA. 62+00.00 TO STA. 68+00.00
- A. Removed (C1) notes, updated legend
- 4.7 SHEET 17 - PLAN - LINE "PR-A" STA. 68+00.00 TO STA. 74+00.00
- A. Reissue sheet
- 4.8 SHEET 24
- A. Added Box Culvert Details
- 4.9 SHEET 25 - PAVEMENT QUANTITIES AND APPROACH TABLE
- A. Reissue sheet
- 4.10 SHEETS 27-48
- A. Recalculated Earthwork

PART 5 - QUESTIONS AND ANSWERS

- 5.1 NOT USED

END ADDENDUM #18

**WWS NEW MIDDLE SCHOOL WEST
CENTENNIAL ROAD RECONSTRUCTION
LIST OF DRAWINGS**

DRAWINGS			
No.	Drawing Title	Drawing Date	Revisions
1 of 48	COVER SHEET	8/11/2025	
2 of 48	INDEX AND GENERAL NOTES	10/02/2025	Addendum 18
3 of 48	TYPICAL SECTIONS	10/02/2025	Addendum 18
4 of 48	PLAT NO. 1	8/11/2025	
5 of 48	MAINTENANCE OF TRAFFIC	8/11/2025	
6 of 48	MAINTENANCE OF TRAFFIC	8/11/2025	
7 of 48	MAINTENANCE OF TRAFFIC	8/11/2025	
8 of 48	MAINTENANCE OF TRAFFIC	8/11/2025	
9 of 48	MAINTENANCE OF TRAFFIC	8/11/2025	
10 of 48	PLAN – LINE “PR-B” STA. 10+00.00 TO STA. 16+00.00	10/02/2025	Addendum 18
11 of 48	PROFILE – LINE “PR-B” STA. 10+00.00 TO STA. 16+00.00	8/11/2025	
12 of 48	PLAN – LINE “PR-B” 16+00.00 TO 22+00.00	10/02/2025	Addendum 18
13 of 48	PROFILE – LINE “PR-B” STA. 16+00.00 TO STA. 22+00.00	8/11/2025	
14 of 48	PLAN – LINE “PR-B” 22+00.00 TO 28+00.00	10/02/2025	Addendum 18
15 of 48	PROFILE – LINE “PR-B” STA. 22+00.00 TO STA. 25+38.59	8/11/2025	
16 of 48	PLAN – LINE “PR-A” STA. 62+00.00 TO STA. 68+00.00	10/02/2025	Addendum 18
17 of 48	PLAN – LINE “PR-A” STA. 68+00.00 TO STA. 74+00.00	10/02/2025	Addendum 18
18 of 48	CURB RAMP DETAILS	8/11/2025	
19 of 48	EROSION CONTROL DETAIL	8/11/2025	
20 of 48	EROSION CONTROL DETAIL	8/11/2025	
21 of 48	PAVEMENT MARKING DETAILS	8/11/2025	
22 of 48	SHEET SIGN & POST SUMMARY TABLE	8/11/2025	
23 of 48	PAVEMENT MARKINGS SUMMARY OF QUANTITIES	8/11/2025	
24 of 48	MISCELLANEOUS DETAIL	10/02/2025	Addendum 18
25 of 48	PAVEMENT QUANTITIES AND APPROACH TABLE	10/02/2025	Addendum 18

**WWS NEW MIDDLE SCHOOL WEST
CENTENNIAL ROAD RECONSTRUCTION
LIST OF DRAWINGS**

26 of 48	STRUCTURE DATA TABLE	8/11/2025	
27 of 48	CROSS SECTIONS LINE "PR-B"	10/02/2025	Addendum 18
28 of 48	CROSS SECTIONS LINE "PR-B"	10/02/2025	Addendum 18
29 of 48	CROSS SECTIONS LINE "PR-B"	10/02/2025	Addendum 18
30 of 48	CROSS SECTIONS LINE "PR-B"	10/02/2025	Addendum 18
31 of 48	CROSS SECTIONS LINE "PR-B"	10/02/2025	Addendum 18
32 of 48	CROSS SECTIONS LINE "PR-B"	10/02/2025	Addendum 18
33 of 48	CROSS SECTIONS LINE "PR-B"	10/02/2025	Addendum 18
34 of 48	CROSS SECTIONS LINE "PR-B"	10/02/2025	Addendum 18
35 of 48	CROSS SECTIONS LINE "PR-B"	10/02/2025	Addendum 18
36 of 48	CROSS SECTIONS LINE "PR-B"	10/02/2025	Addendum 18
37 of 48	CROSS SECTIONS LINE "PR-B"	10/02/2025	Addendum 18
38 of 48	CROSS SECTIONS LINE "PR-B"	10/02/2025	Addendum 18
39 of 48	CROSS SECTIONS LINE "PR-A"	10/02/2025	Addendum 18
40 of 48	CROSS SECTIONS LINE "PR-A"	10/02/2025	Addendum 18
41 of 48	CROSS SECTIONS LINE "PR-A"	10/02/2025	Addendum 18
42 of 48	CROSS SECTIONS LINE "PR-A"	10/02/2025	Addendum 18
43 of 48	CROSS SECTIONS LINE "PR-A"	10/02/2025	Addendum 18
44 of 48	CROSS SECTIONS LINE "PR-A"	10/02/2025	Addendum 18
45 of 48	CROSS SECTIONS LINE "PR-A"	10/02/2025	Addendum 18
46 of 48	CROSS SECTIONS LINE "PR-A"	10/02/2025	Addendum 18
47 of 48	CROSS SECTIONS LINE "PR-A"	10/02/2025	Addendum 18
48 of 48	CROSS SECTIONS LINE "PR-A"	10/02/2025	Addendum 18

**WWS NEW MIDDLE SCHOOL WEST
CENTENNIAL ROAD RECONSTRUCTION
LIST OF DRAWINGS**

**Drawings included for reference and
coordination ONLY.:**

DRAWINGS			
No.	Drawing Title	Drawing Date	Revisions
10F12	Topographic Survey	8/18/2023	BP 03
20F12	Topographic Survey	8/18/2023	BP 03
30F12	Topographic Survey	8/18/2023	BP 03
40F12	Topographic Survey	8/18/2023	BP 03
50F12	Topographic Survey	8/18/2023	BP 03
60F12	Topographic Survey	8/18/2023	BP 03
70F12	Topographic Survey	8/18/2023	BP 03
80F12	Topographic Survey	8/18/2023	BP 03
90F12	Topographic Survey	8/18/2023	BP 03
100F12	Topographic Survey	8/18/2023	BP 03
110F12	Topographic Survey	8/18/2023	BP 03
120F12	Topographic Survey	8/18/2023	BP 03
C100	COVER SHEET	8/8/2025	ASI 26 - Trans Pipe Outlet
C101	EXISTING CONDITIONS & DEMOLITION PLAN	1/22/2025	ASI 09 - Civil TAC Updates
C102	EXISTING CONDITIONS & DEMOLITION PLAN	6/17/2024	BP 03
C250	Index and Typ	6/21/2024	BP 03
C251	PLAN "PR-A" STA. 00+00 TO STA. 5+80	1/22/2025	ASI 09 - Civil TAC Updates
C252	PROFILE "PR-A" STA. 00+00 TO STA. 05+80	1/22/2025	ASI 09 - Civil TAC Updates
C253	PLAN "PR-A" STA. 05+50 TO STA. 11+00	1/22/2025	ASI 09 - Civil TAC Updates
C254	PROFILE "PR-A" STA. 05+50 TO STA. 11+00	1/22/2025	ASI 09 - Civil TAC Updates
C255	PLAN "PR-A" STA. 11+00 TO STA. 15+39	1/22/2025	ASI 09 - Civil TAC Updates
C256	PROFILE "PR-A" STA. 11+00 TO STA. 15+39	1/22/2025	ASI 09 - Civil TAC Updates
C257	PLAN "PR-B" STA. 00+00 TO STA. 05+00	1/22/2025	ASI 09 - Civil TAC Updates
C258	PROFILE "PR-B" STA. 00+00 TO STA. 5+50	6/17/2024	BP 03

**WWS NEW MIDDLE SCHOOL WEST
CENTENNIAL ROAD RECONSTRUCTION
LIST OF DRAWINGS**

C259	PLAN "PR-B" STA. 05+00 TO STA. 07+91	1/22/2025	ASI 09 - Civil TAC Updates
C260	PROFILE "PR-B" STA. 05+50 TO STA. 7+91	6/17/2024	BP 03
C261	PLAN "PR-C" STA. 00+00 TO STA. 06+00	1/22/2025	ASI 09 - Civil TAC Updates
C262	PROFILE "PR-C" STA. 00+00 TO STA. 06+00	6/17/2024	BP 03
C263	PLAN "PR-C" STA. 06+00 TO STA. 12+00	1/22/2025	ASI 09 - Civil TAC Updates
C264	PROFILE "PR-C" STA. 06+00 TO STA. 12+00	6/17/2024	BP 03
C265	PLAN "PR-C" STA. 12+00 TO STA. 17+00	1/22/2025	ASI 09 - Civil TAC Updates
C266	PROFILE "PR-C" STA. 12+00 TO STA. 18+00	6/17/2024	BP 03
C267	PLAN "PR-C" STA. 17+00 TO STA. 23+00	1/22/2025	ASI 09 - Civil TAC Updates
C268	PROFILE "PR-C" STA. 18+00 TO STA. 24+00	6/17/2024	BP 03
C269	PLAN "PR-C" STA. 23+00 TO STA. 29+79	1/22/2025	ASI 09 - Civil TAC Updates
C270	PROFILE "PR-C" STA. 24+00 TO STA. 29+52	9/26/2024	ASI 02 - Civil Updates
C300	OVERALL GRADING PLAN	1/22/2025	ASI 09 - Civil TAC Updates
C301	GRADING PLAN	1/22/2025	ASI 09 - Civil TAC Updates
C302	GRADING PLAN	1/22/2025	ASI 09 - Civil TAC Updates
C303	GRADING PLAN	1/22/2025	ASI 09 - Civil TAC Updates
C304	GRADING PLAN	1/22/2025	ASI 09 - Civil TAC Updates
C305	GRADING PLAN	1/22/2025	ASI 09 - Civil TAC Updates
C306	GRADING PLAN	1/22/2025	ASI 09 - Civil TAC Updates
C307	GRADING PLAN	1/22/2025	ASI 09 - Civil TAC Updates
C401	SWPPP PLAN (INITIAL)	6/17/2024	BP 03
C402	SWPPP PLAN (INITIAL)	6/17/2024	BP 03
C403	SWPPP PLAN (CONST.)	1/22/2025	ASI 09 - Civil TAC Updates
C404	SWPPP PLAN (CONST.)	1/22/2025	ASI 09 - Civil TAC Updates
C405	SWPPP PLAN (FINAL)	1/22/2025	ASI 09 - Civil TAC Updates
C406	SWPPP PLAN (FINAL)	1/22/2025	ASI 09 - Civil TAC Updates

**WWS NEW MIDDLE SCHOOL WEST
CENTENNIAL ROAD RECONSTRUCTION
LIST OF DRAWINGS**

C407	SWPPP PLAN (DETAILS)	6/17/2024	BP 03
C408	SWPPP PLAN (DETAILS)	6/17/2024	BP 03
C409	SWPPP PLAN (INFORMATION)	6/21/2024	BP 03
C410	SWPPP PLAN (INFORMATION)	1/22/2025	ASI 09 - Civil TAC Updates
C500	STRUCTURE DATA TABLE	1/22/2025	ASI 09 - Civil TAC Updates
C500A	PIPE DATA TABLE	1/22/2025	ASI 09 - Civil TAC Updates
C501	UTILITY PLAN	2/28/2025	ASI 13 - Site Utility Modifications
C502	UTILITY PLAN	2/28/2025	ASI 13 - Site Utility Modifications
C503	UTILITY PLAN	2/28/2025	ASI 13 - Site Utility Modifications
C504	UTILITY PLAN	2/28/2025	ASI 13 - Site Utility Modifications
C505	UTILITY PLAN	1/22/2025	ASI 09 - Civil TAC Updates
C506	UTILITY PLAN	8/20/2025	ASI 26 - Trans Pipe Outlet
C601	SANITARY PLAN & PROFILE	2/28/2025	ASI 13 - Site Utility Modifications
C700	OVERALL UTILITY PLAN	1/22/2025	ASI 09 - Civil TAC Updates
C701	STORM PLAN & PROFILE	1/22/2025	ASI 09 - Civil TAC Updates
C702	STORM PLAN & PROFILE	1/22/2025	ASI 09 - Civil TAC Updates
C703	STORM PLAN & PROFILE	1/22/2025	ASI 09 - Civil TAC Updates
C704	STORM PLAN & PROFILE	2/28/2025	ASI 13 - Site Utility Modifications
C705	STORM PLAN & PROFILE	1/22/2025	ASI 09 - Civil TAC Updates
C706	STORM PLAN & PROFILE	1/22/2025	ASI 09 - Civil TAC Updates
C707	STORM PLAN & PROFILE	1/22/2025	ASI 09 - Civil TAC Updates
C708	STORM PLAN & PROFILE	1/22/2025	ASI 09 - Civil TAC Updates
C709	STORM PLAN & PROFILE	1/22/2025	ASI 09 - Civil TAC Updates

**WWS NEW MIDDLE SCHOOL WEST
CENTENNIAL ROAD RECONSTRUCTION
LIST OF DRAWINGS**

C710	STORM PLAN & PROFILE	1/22/2025	ASI 09 - Civil TAC Updates
C711	STORM PLAN & PROFILE	1/22/2025	ASI 09 - Civil TAC Updates
C712	STORM PLAN & PROFILE	1/22/2025	ASI 09 - Civil TAC Updates
C713	STORM PLAN & PROFILE	1/22/2025	ASI 09 - Civil TAC Updates
C901	SITE DETAILS	1/22/2025	ASI 09 - Civil TAC Updates
C902	SITE DETAILS	6/17/2024	BP 03
C903	SITE DETAILS	6/21/2024	BP 03
C904	SITE DETAILS	1/22/2025	ASI 09 - Civil TAC Updates
C905	SITE DETAILS	1/22/2025	ASI 09 - Civil TAC Updates
C906	SITE DETAILS	9/26/2024	ASI 02 - Civil Updates
C907	SITE DETAILS	2/28/2025	ASI 13 - Site Utility Modifications
L010	TREE PRESERVATION PLAN	12/6/2024	Conformed Set (12/06/2024)
L100	REFERENCE PLAN	12/6/2024	Conformed Set (12/06/2024)
L101	MATERIALS & NOTES	12/6/2024	Conformed Set (12/06/2024)
L102	MATERIALS & NOTES	12/6/2024	Conformed Set (12/06/2024)
L103	MATERIALS & NOTES	12/6/2024	Conformed Set (12/06/2024)
L104	MATERIALS & NOTES	12/6/2024	Conformed Set (12/06/2024)
L105	MATERIALS & NOTES	12/6/2024	Conformed Set (12/06/2024)
L106	MATERIALS & NOTES	12/6/2024	Conformed Set (12/06/2024)
L107	MATERIALS & NOTES	12/6/2024	Conformed Set (12/06/2024)
L108	MATERIALS & NOTES	12/6/2024	Conformed Set (12/06/2024)
L201	LAYOUT PLAN	12/6/2024	Conformed Set (12/06/2024)
L202	LAYOUT PLAN	12/6/2024	Conformed Set (12/06/2024)
L203	LAYOUT PLAN	12/6/2024	Conformed Set (12/06/2024)
L204	LAYOUT PLAN	12/6/2024	Conformed Set (12/06/2024)

**WWS NEW MIDDLE SCHOOL WEST
CENTENNIAL ROAD RECONSTRUCTION
LIST OF DRAWINGS**

L205	LAYOUT PLAN	12/6/2024	Conformed Set (12/06/2024)
L206	LAYOUT PLAN	12/6/2024	Conformed Set (12/06/2024)
L207	LAYOUT PLAN	12/6/2024	Conformed Set (12/06/2024)
L208	LAYOUT PLAN	12/6/2024	Conformed Set (12/06/2024)
L301	ENLARGED ATHLETIC PLANS	12/6/2024	Conformed Set (12/06/2024)
L302	ENLARGED ATHLETIC PLANS	12/6/2024	Conformed Set (12/06/2024)
L303	ENLARGED ATHLETIC PLANS	11/22/2024	ASI 04 - Irrigation Room Dugout
L304	ENLARGED ATHLETIC PLANS	12/6/2024	Conformed Set (12/06/2024)
L305	ENLARGED ATHLETIC PLANS	12/6/2024	Conformed Set (12/06/2024)
L306	ENLARGED ATHLETIC PLANS	12/6/2024	Conformed Set (12/06/2024)
L307	ENLARGED ATHLETIC PLANS	12/6/2024	Conformed Set (12/06/2024)
L308	BLEACHER AND PRESS BOX PLANS & DETAILS	12/6/2024	Conformed Set (12/06/2024)
L309	BLEACHER AND PRESS BOX PLANS & DETAILS	12/6/2024	Conformed Set (12/06/2024)
L310	BLEACHER AND PRESS BOX PLANS & DETAILS	12/6/2024	Conformed Set (12/06/2024)
L311	BLEACHER AND PRESS BOX PLANS & DETAILS	12/6/2024	Conformed Set (12/06/2024)
L312	BLEACHER AND PRESS BOX PLANS & DETAILS	12/6/2024	Conformed Set (12/06/2024)
L313	BLEACHER AND PRESS BOX PLANS & DETAILS	12/6/2024	Conformed Set (12/06/2024)
L314	BLEACHER AND PRESS BOX PLANS & DETAILS	12/6/2024	Conformed Set (12/06/2024)
L315	BLEACHER AND PRESS BOX PLANS & DETAILS	12/6/2024	Conformed Set (12/06/2024)
L316	BLEACHER AND PRESS BOX PLANS & DETAILS	12/6/2024	Conformed Set (12/06/2024)
L317	BLEACHER AND PRESS BOX PLANS & DETAILS	12/6/2024	Conformed Set (12/06/2024)
L318	BLEACHER AND PRESS BOX PLANS & DETAILS	12/6/2024	Conformed Set (12/06/2024)
L401	PLANTING PLAN	12/6/2024	Conformed Set (12/06/2024)
L402	PLANTING PLAN	12/6/2024	Conformed Set (12/06/2024)

**WWS NEW MIDDLE SCHOOL WEST
CENTENNIAL ROAD RECONSTRUCTION
LIST OF DRAWINGS**

L403	PLANTING PLAN	12/6/2024	Conformed Set (12/06/2024)
L404	PLANTING PLAN	7/26/2024	Conformed Set (12/06/2024)
L405	PLANTING PLAN	7/26/2024	Conformed Set (12/06/2024)
L406	PLANTING PLAN	7/26/2024	Conformed Set (12/06/2024)
L407	PLANTING PLAN	7/26/2024	Conformed Set (12/06/2024)
L408	PLANTING PLAN	7/26/2024	Conformed Set (12/06/2024)
L500	SITE DETAILS	12/6/2024	Conformed Set (12/06/2024)
L501	SITE DETAILS	12/6/2024	Conformed Set (12/06/2024)
L502	SITE DETAILS	12/6/2024	Conformed Set (12/06/2024)
L510	ATHLETIC DETAILS	12/6/2024	Conformed Set (12/06/2024)
L511	ATHLETIC DETAILS	12/6/2024	Conformed Set (12/06/2024)
L512	ATHLETIC DETAILS	12/6/2024	Conformed Set (12/06/2024)

END OF SECTION

Item No.	Description	Unit	Quantity
1	MOBILIZATION AND DEMOBILIZATION	LS	1.0
2	CONSTRUCTION ENGINEERING	LS	1.0
3	CLEARING OF RIGHT OF WAY	LS	1.0
4	EXCAVATION, COMMON	CYS	1,512.0
5	BORROW	CYS	3,518.1
6	STORM WATER MANAGEMENT BUDGET	LS	1.0
7	STORMWATER MANAGEMENT IMPLEMENTATION	LS	1.0
8	SWOCP PREPARATION	LS	1.0
9	SUBGRADE TREATMENT, TYPE IBC	SYS	8,731.1
10	12 IN. COMPACTED AGGREGATE, NO. 53, BASE	CYS	3,242.8
11	SUBGRADE TREATMENT, TYPE IBL	SYS	1,994.3
12	CURB AND GUTTER, CONCRETE	LFT	262.2
13	CURB RAMP, CONCRETE	SYS	48.2
14	DETECTABLE WARNING SURFACES	SYS	7.1
15	ASPHALT FOR TACK COAT	TON	6.7
16	HMA SURFACE, TYPE B, 9.5 MM	TON	721.0
17	HMA INTERMEDIATE, TYPE B, 19.0 MM	TON	1,127.0
18	HMA BASE, TYPE B, 25.0 MM	TON	2,905.0
19	HMA SURFACE, TYPE B, 12.5 MM	TON	331.0
20	MULCHING MATERIAL	TON	2.8
21	FERTILIZER	TON	0.6
22	SEED MIXTURE, T	LBS	207.9
23	SEED MIXTURE, U	LBS	207.9
24	PIPE, TYPE 2, CIRCULAR, 12 IN.	LFT	133.0
25	PIPE, TYPE 2, CIRCULAR, 15 IN.	LFT	40.0
26	INLET, TYPE E7	EACH	2.0
27	PIPE END SECTION, DIAMETER 12 IN.	EACH	2.0
28	15" PIPE CATCH BASIN	EACH	2.0
29	STRUCTURE, REINFORCED CONCRETE, BOX SECTIONS, 5 FT X 2 FT, WITH WINGWALLS	LFT	85.0
29	GRADED CASTING AND RISER RINGS	EACH	1.0
30	STRUCTURE BACKFILL, TYPE 1	CYS	25.7
31	FLOWABLE BACKFILL, REMOVABLE	CYS	48.4
32	COMPACTED AGGREGATE, NO. 8	CYS	34.6
33	CASTING, FURNISH AND ADJUST TO GRADE	EACH	1.0
34	RIPRAP, REVETMENT	TON	39.0
35	GEOTEXTILES FOR RIPRAP, TYPE 1B	SYS	52.0
36	MAINTAINING TRAFFIC	LS	1.0
37	CONSTRUCTION SIGN, TYPE A	EACH	8.0
38	BARRICADE, TYPE III-A	LFT	84.0
39	ROAD CLOSURE SIGN ASSEMBLY	EACH	3
40	DETOUR ROUTE MARKER ASSEMBLY	EACH	48
41	TEMPORARY PAVEMENT MARKING, REMOVABLE, 4 IN.	LFT	4,732
42	SIGN, SHEET, WITH LEGEND, 0.080 IN. THICKNESS	SFT	55
43	SIGN, SHEET, WITH LEGEND, 0.100 IN. THICKNESS	SFT	13.8
44	SIGN POST, SQUARE, TYPE 2, REINFORCED ANCHOR BASE	LFT	131.8
45	SOLAR POWERED FLASHING BEACON ASSEMBLY	EACH	2.0
46	TRAFFIC SIGNAL HEAD, NO. 1 SECTION, 12 IN. AMBER	EACH	2.0
47	LINE, THERMOPLASTIC, SOLID, WHITE, 4 IN.	LFT	4,177.0
48	LINE, THERMOPLASTIC, SOLID, YELLOW, 4 IN.	LFT	3,006.0
49	PAVEMENT MESSAGE MARKING, THERMOPLASTIC, LANE INDICATION ARROW	EACH	9.0
50	TRANSVERSE MARKING, THERMOPLASTIC, STOP LINE, 24 IN.	LFT	36.0

UTILITIES

UTILITY	OWNER	ADDRESS
Gas	Citizen's Energy Group	Rich Miller 317-927-4684 rmiller@citizensenergygroup.com 2150 Dr. Martin Luther King Jr. Street Indianapolis, IN 46202
Sanitary	Citizen's Energy Group	David Clark 317-429-3993 dclark@citizensenergygroup.com 2150 Dr. Martin Luther King Jr. Street Indianapolis, IN 46202
Water	Citizen's Energy Group	Scott Ritter 317-927-4434 sritter@citizensenergygroup.com 2150 Dr. Martin Luther King Jr. Street Indianapolis, IN 46202
Electric	Duke Energy Group	Frank Hancock 765-524-7945 frank.hancock@duke-energy.com 4535 Jane Blvd New Castle, IN 47362
Communications	Comcast	BSM Groups LLC 812-271-2400 comcastrelocate@bsmgroups.com 1600 West Fountain Dr Bloomington, IN 47404
	Crown Castle Fiber	Craig Brown 317-819-8648 craig.brown@crowncastle.com 800 Oliver Ave. Suite 1 Indianapolis, IN 46225
	Duke Fiber	Charlotte Seegrist 513-287-1105 DukeFiberMW@Duke-Energy.com 139 E. 4th Street Cincinnati, OH 45202
	Frontier Communication	Dan Koch 260-415-9328 daniel.koch@ftr.com 4027 Beckwith Drive Fort Wayne, IN 46808
	Metronet	Doug Reckart 317-809-8067 doug.reckart@metronet.com 8036 Cole Wood Blvd. Indianapolis, IN 46239
	Spectrum Communications	Byron Posey 317-538-2016 byron.posey@charter.com 3030 Roosevelt Ave Indianapolis, IN 46218
	Verizon/MCI	Rolland Craig 317-498-1242 dennis.craig@verizon.com 6835 Hillsdale Ct. Indianapolis, IN 46250
	Zayo Group	Waylon Higgins 765-341-1199 waylon.higgins@zayo.com 9209 Castlegate Dr Indianapolis, IN 46256

GENERAL NOTES

**	All Earth Shoulders, median areas, and cut and fill slopes shall be plain or mulched seeded except where sodding is specified.
**	Clearing and removal of woody vegetation will be kept to a minimum between construction limits and right-of-way.
**	Tack Coat shall be placed on new and existing bituminous before a new lift of bituminous is added.
**	City of Westfield Construction Standards and Specifications: https://www.westfieldin.gov/DocumentCenter/View/366/Standards-PDF
**	2026 INDOT Standard Specifications: https://www.in.gov/dot/div/contracts/standards/book/sep25/sep.htm
**	Represents General Notes required.

REVISIONS

[illegible]

R/W INDEX

[illegible]

INDEX

[illegible]


VERIFICATION NOTE

Contractor shall verify all dimensions and clearances and all existing filed conditions before starting construction. Commencement of work constitutes acceptance of conditions.

Should different conditions be encountered, contact the engineer or designer before proceeding with work.



8365 Keystone Crossing, Suite 201, Indianapolis, IN. 46240 (317) 202-0864

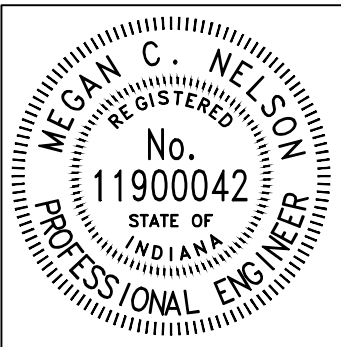

RECOMMENDED
FOR APPROVAL Megan C. Nelson 08/11/2025
DESIGN ENGINEER DATE


DESIGNED: MCN DRAWN: AJG

CHECKED: JAH CHECKED: JAH


WESTFIELD
WASHINGTON SCHOOLS

INDEX AND GENERAL NOTES


HORIZONTAL SCALE	BRIDGE FILE		
N/A	N/A		
VERTICAL SCALE	DESIGNATION		
N/A	--		
	SHEETS		
	2	of	48
	CONTRACT		
	--		

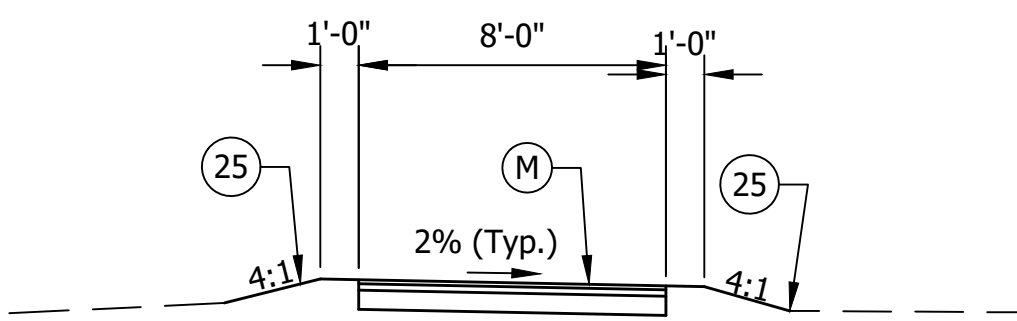

TYPICAL SECTION - PATH
Sta. 61+23.55 to Sta. 74+00.00 "PR-A"

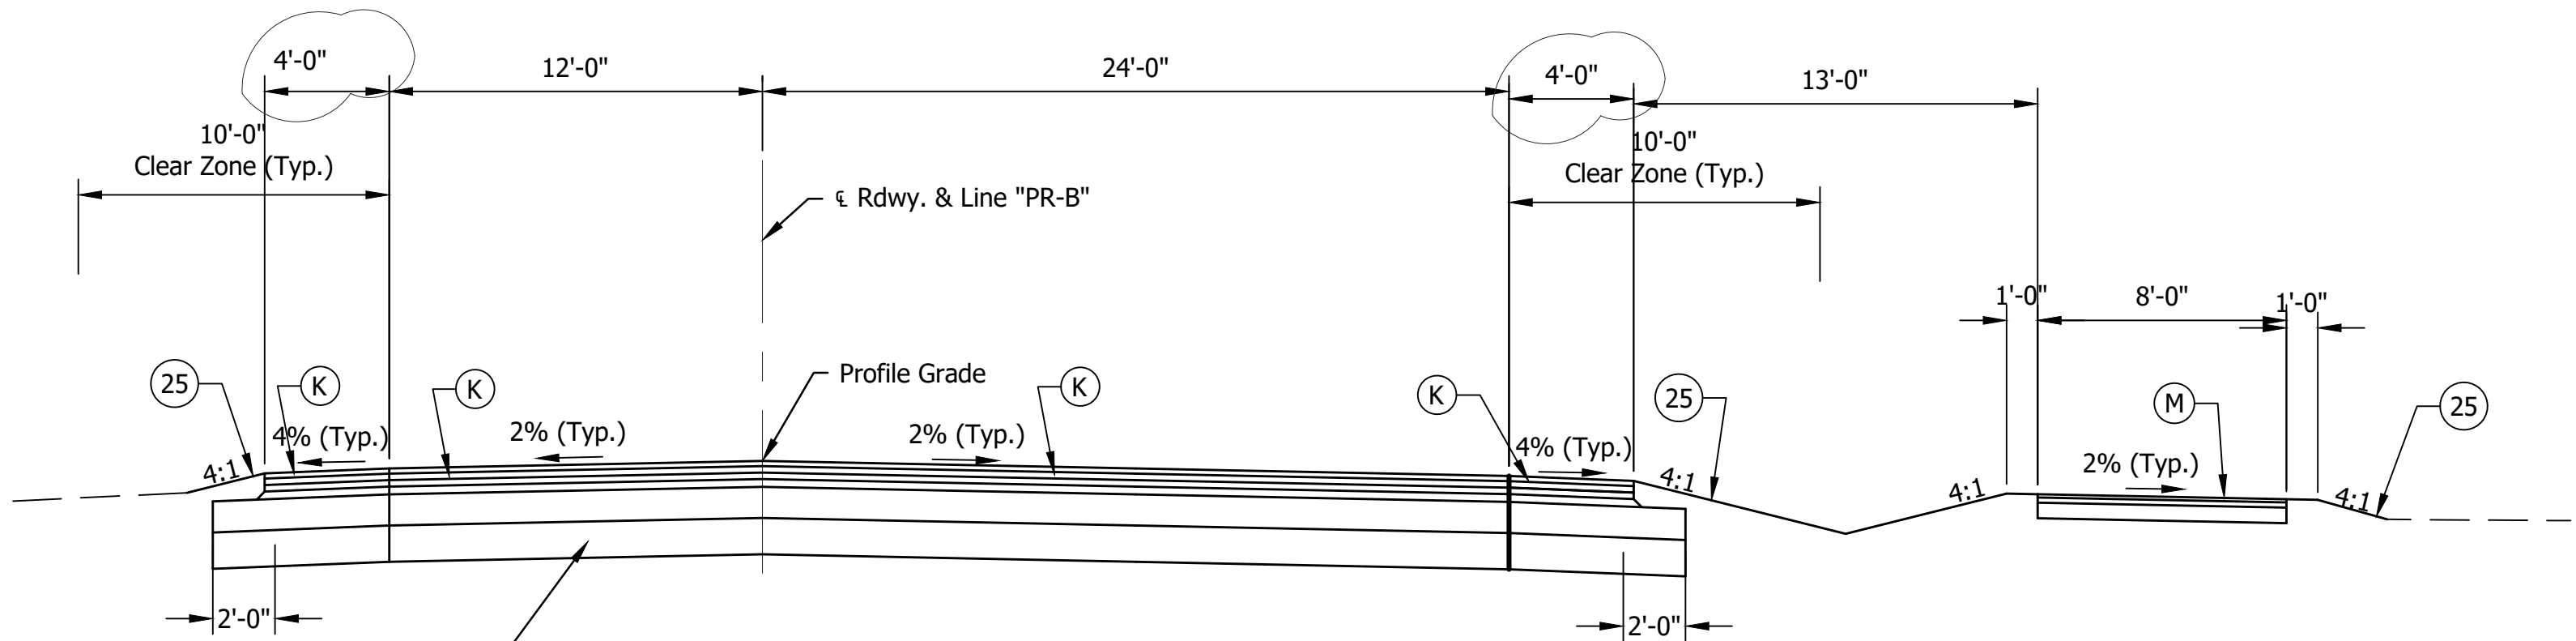


TYPICAL SECTION
Sta. 10+14.80 to Sta. 25+38.55 "PR-B"

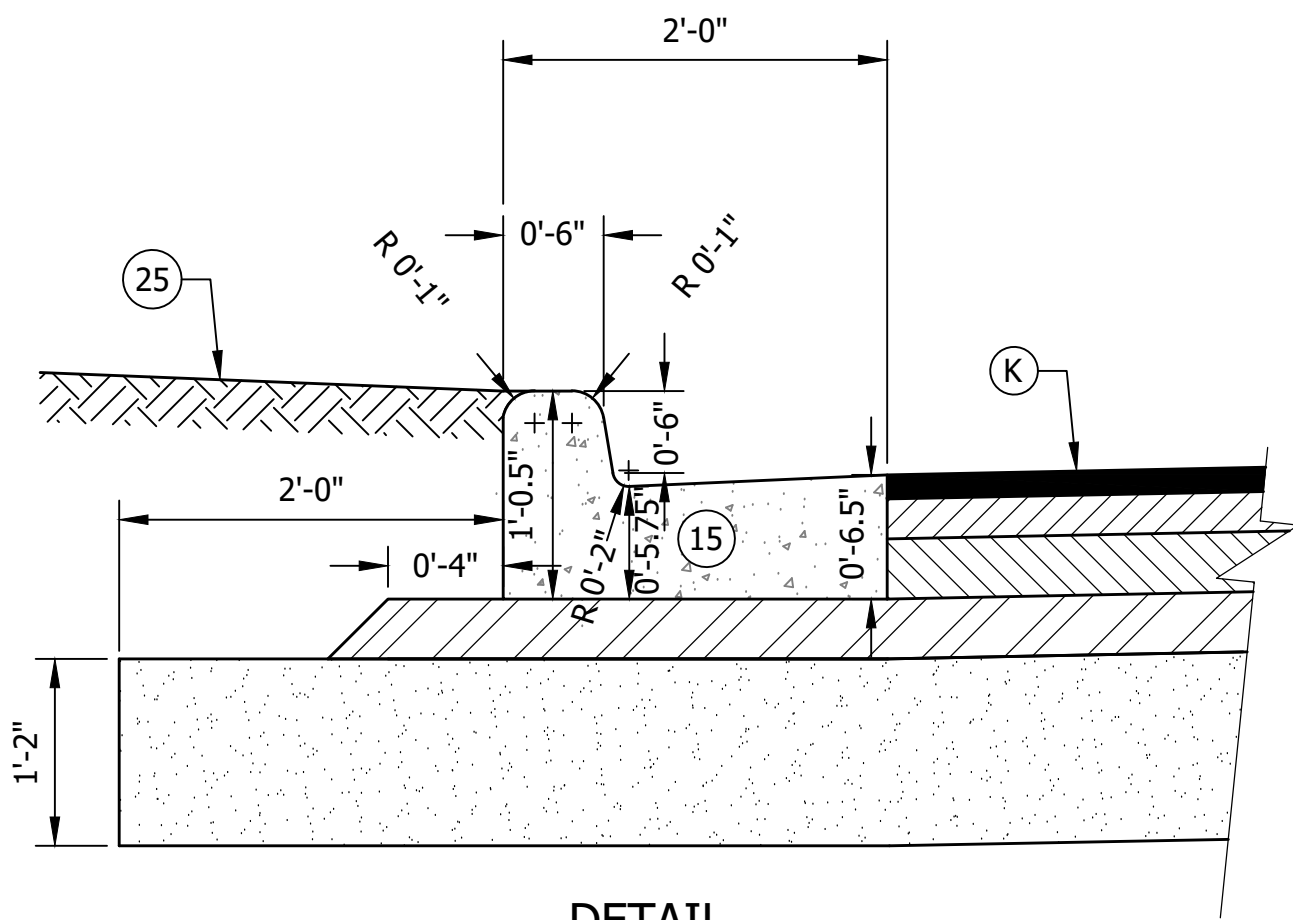


DETAIL
COMBINED CONCRETE CURB & GUTTER
NOT TO SCALE

- LEGEND**
- (K) Full Depth HMA Pavement:
1.5" HMA Surface, Type B, 9.5mm on
2.5" HMA Intermediate, Type B, 19.0mm on
2.5" HMA Base, Type B, 25.0mm on
3.5" HMA Base, Type B, 25.0mm on
12" Compacted Aggregate, No. 53, Base on
Subgrade Treatment, Type IBC
 - (M) HMA for Sidewalk:
3" HMA Surface, Type B, 12.5mm on
6" Compacted Aggregate, No. 53, Base on
Subgrade Treatment, Type IBL
 - (25) Seeding

REVISIONS	
DATE	ITEM
Oct 2, 2025	Updated shoulder width Removed Sodding from Legend

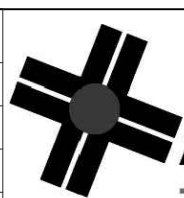**A&F ENGINEERING**
Transportation & Site Engineering
Creating Order Since 1966
8365 Keystone Crossing, Suite 201, Indianapolis, IN. 46240 (317) 202-0864

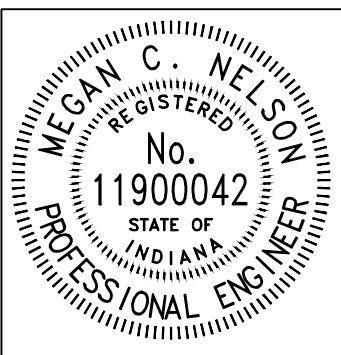


RECOMMENDED FOR APPROVAL		08/11/2025 DATE
DESIGNED:	MCN	DRAWN: MCN
CHECKED:	JAH	CHECKED: JAH


WESTFIELD WASHINGTON SCHOOLS
TYPICAL SECTIONS


HORIZONTAL SCALE 1" = 5'	BRIDGE FILE N/A
VERTICAL SCALE N/A	DESIGNATION --
SHEETS	
3	of 48
CONTRACT	
--	

Z:\2024\240787-CONTEXT DESIGN TRAFFIC SIGNAL, SR 32-CENTENNIAL RD PH5 1D.WG\CENTENNIAL PLAN SET\240787-PLAN CENTENNIAL.DWG

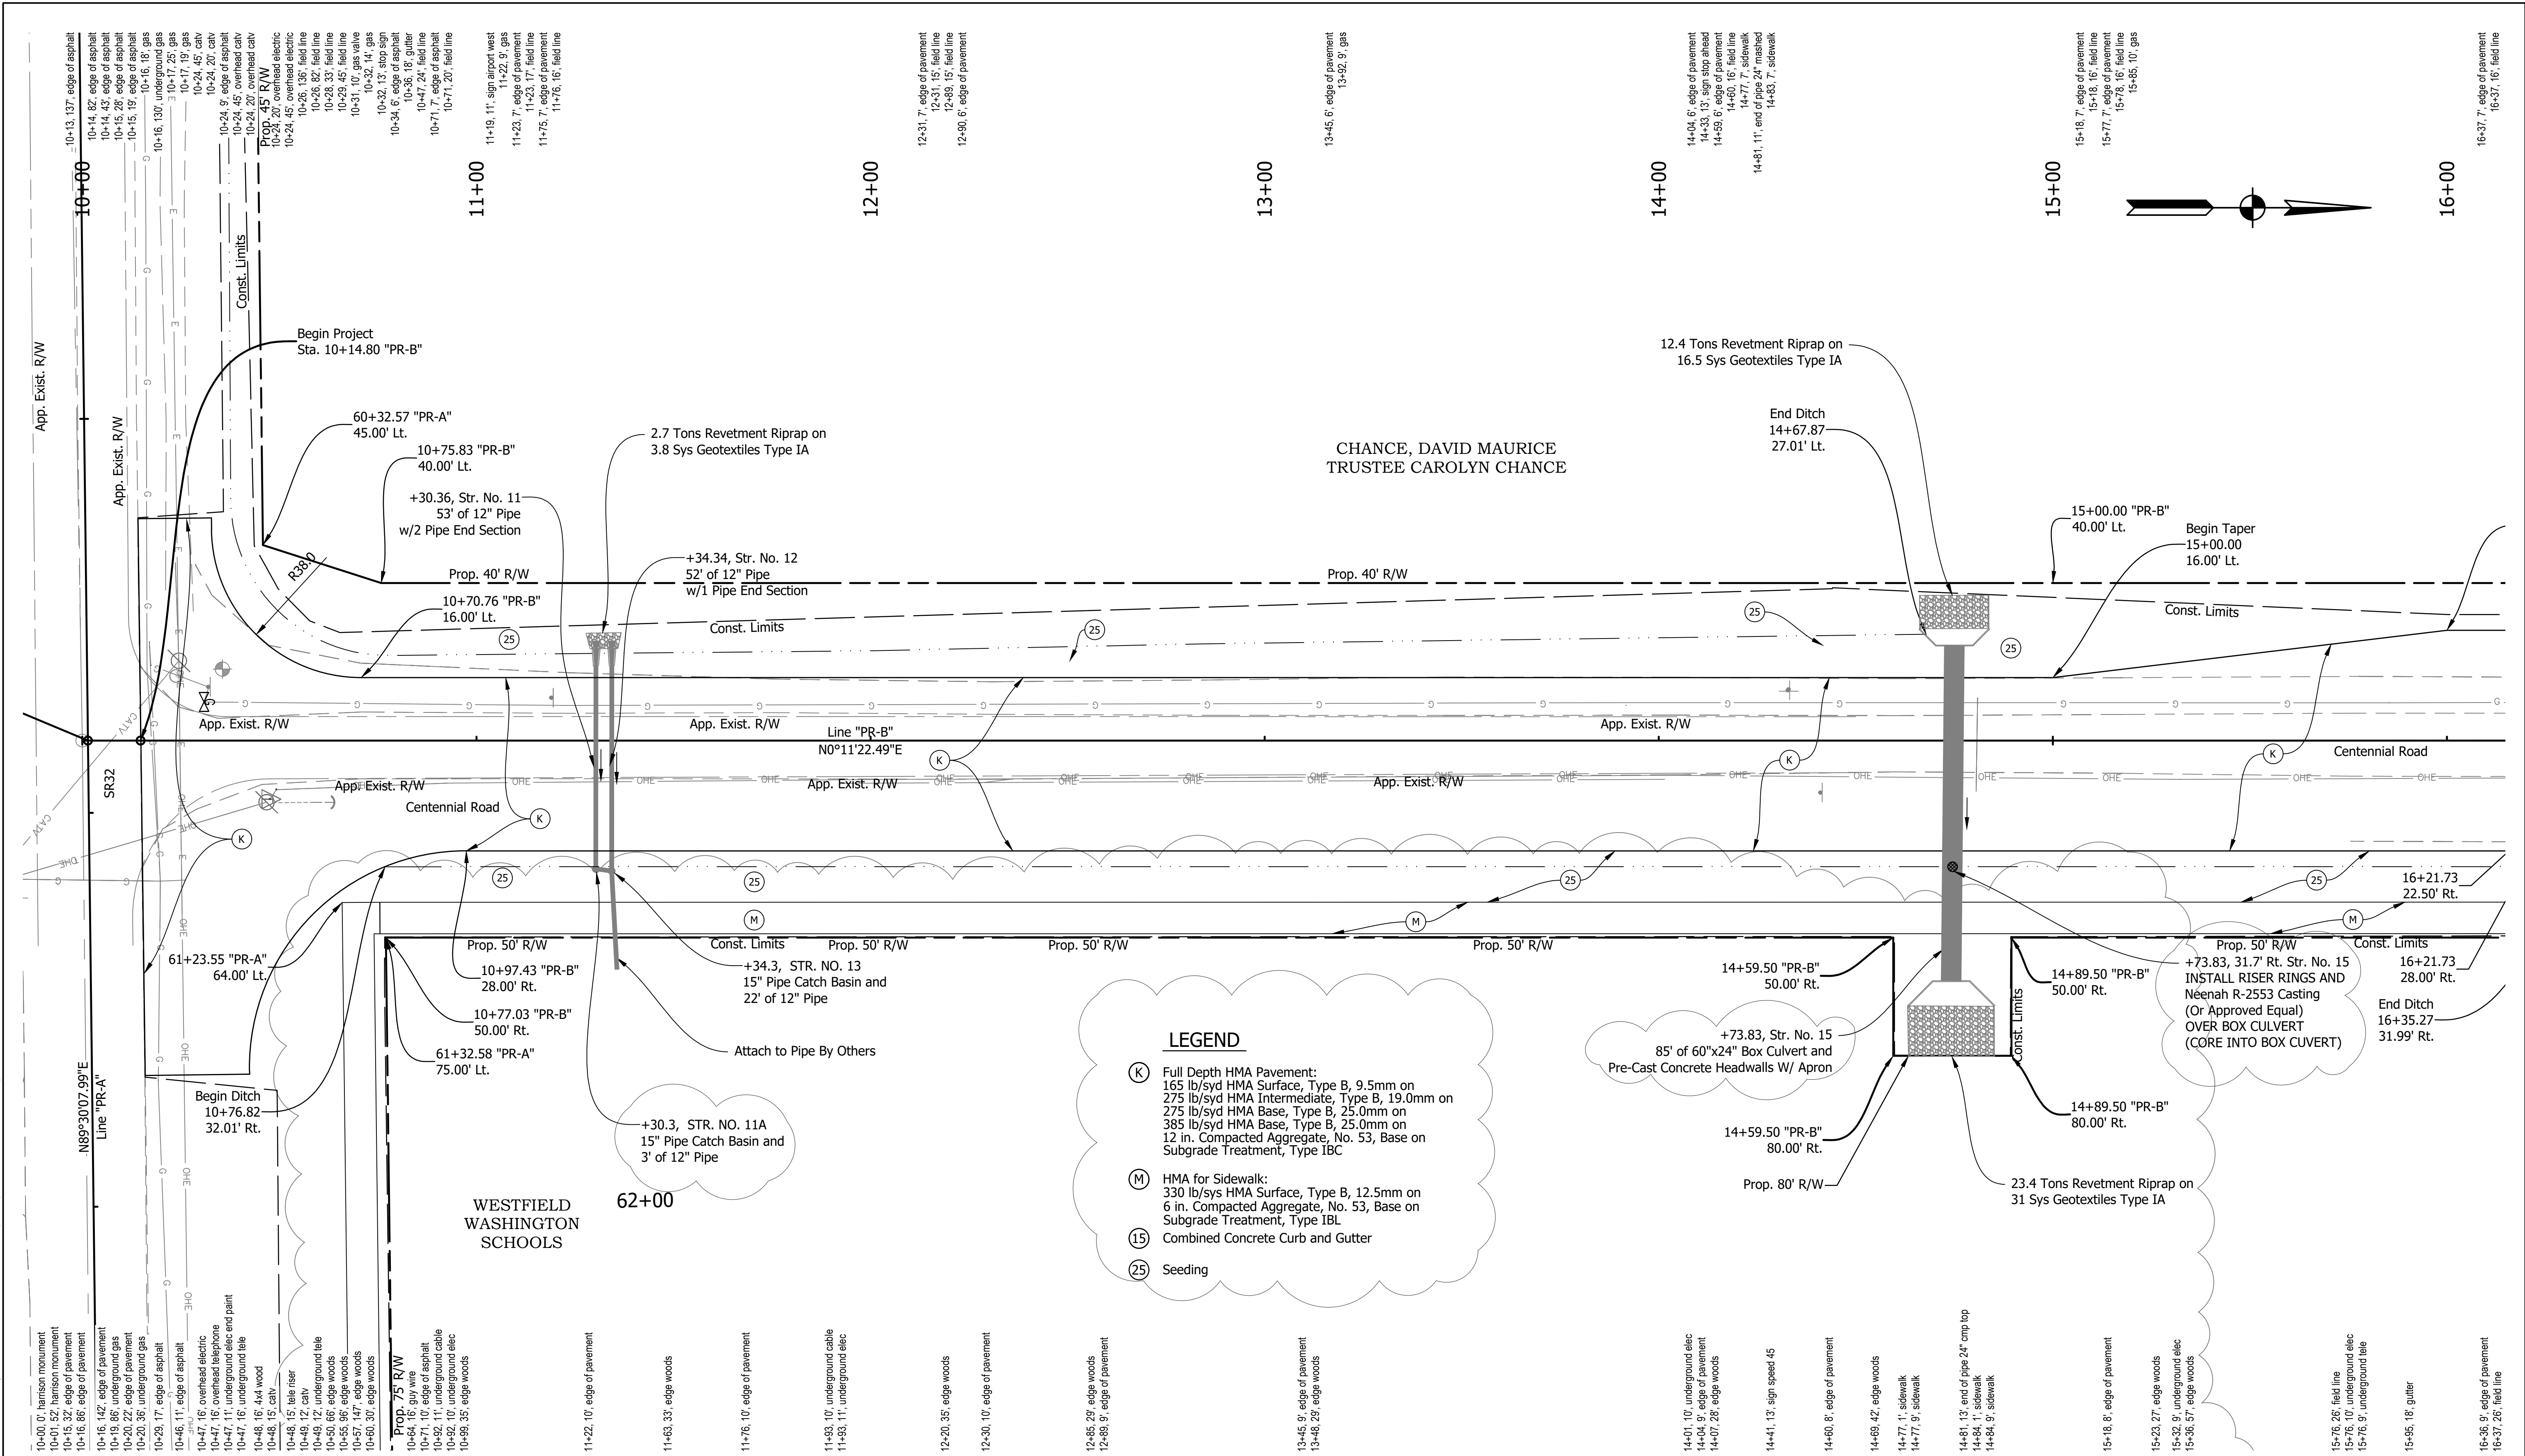

REVISIONS	
DATE	ITEM
Oct 2, 2025	Updated Str. 11A, Added detail notes to box culvert and casting
	Updated Legend

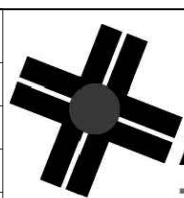**A&F ENGINEERING**
Transportation & Site Engineering
Creating Order Since 1966
8365 Keystone Crossing, Suite 201, Indianapolis, IN. 46240 (317) 202-0864

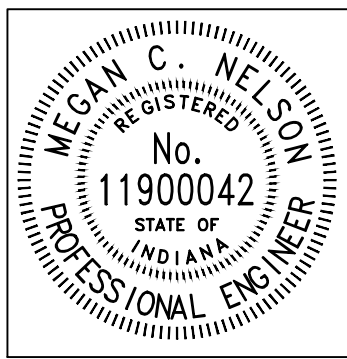


RECOMMENDED FOR APPROVAL		08/11/2025	
<i>Megan C. Nelson</i>		DATE	
DESIGNED: MCN		DRAWN: AJG	
CHECKED: JAH		CHECKED: JAH	

WESTFIELD
WASHINGTON SCHOOLS

PLAN - LINE "PR-B"
STA. 10+00.00 TO STA. 16+00.00

HORIZONTAL SCALE 1" = 20'		BRIDGE FILE N/A	
VERTICAL SCALE N/A		DESIGNATION --	
		SHEETS	
		10	of 48
		CONTRACT --	

Z:\2024\240787-CONTEXT DESIGN\TRAFFIC SIGNAL, SR 32-CENTENNIAL RD PH5 1.DWG\CENTENNIAL PLAN SET\240787-PLAN CENTENNIAL.DWG

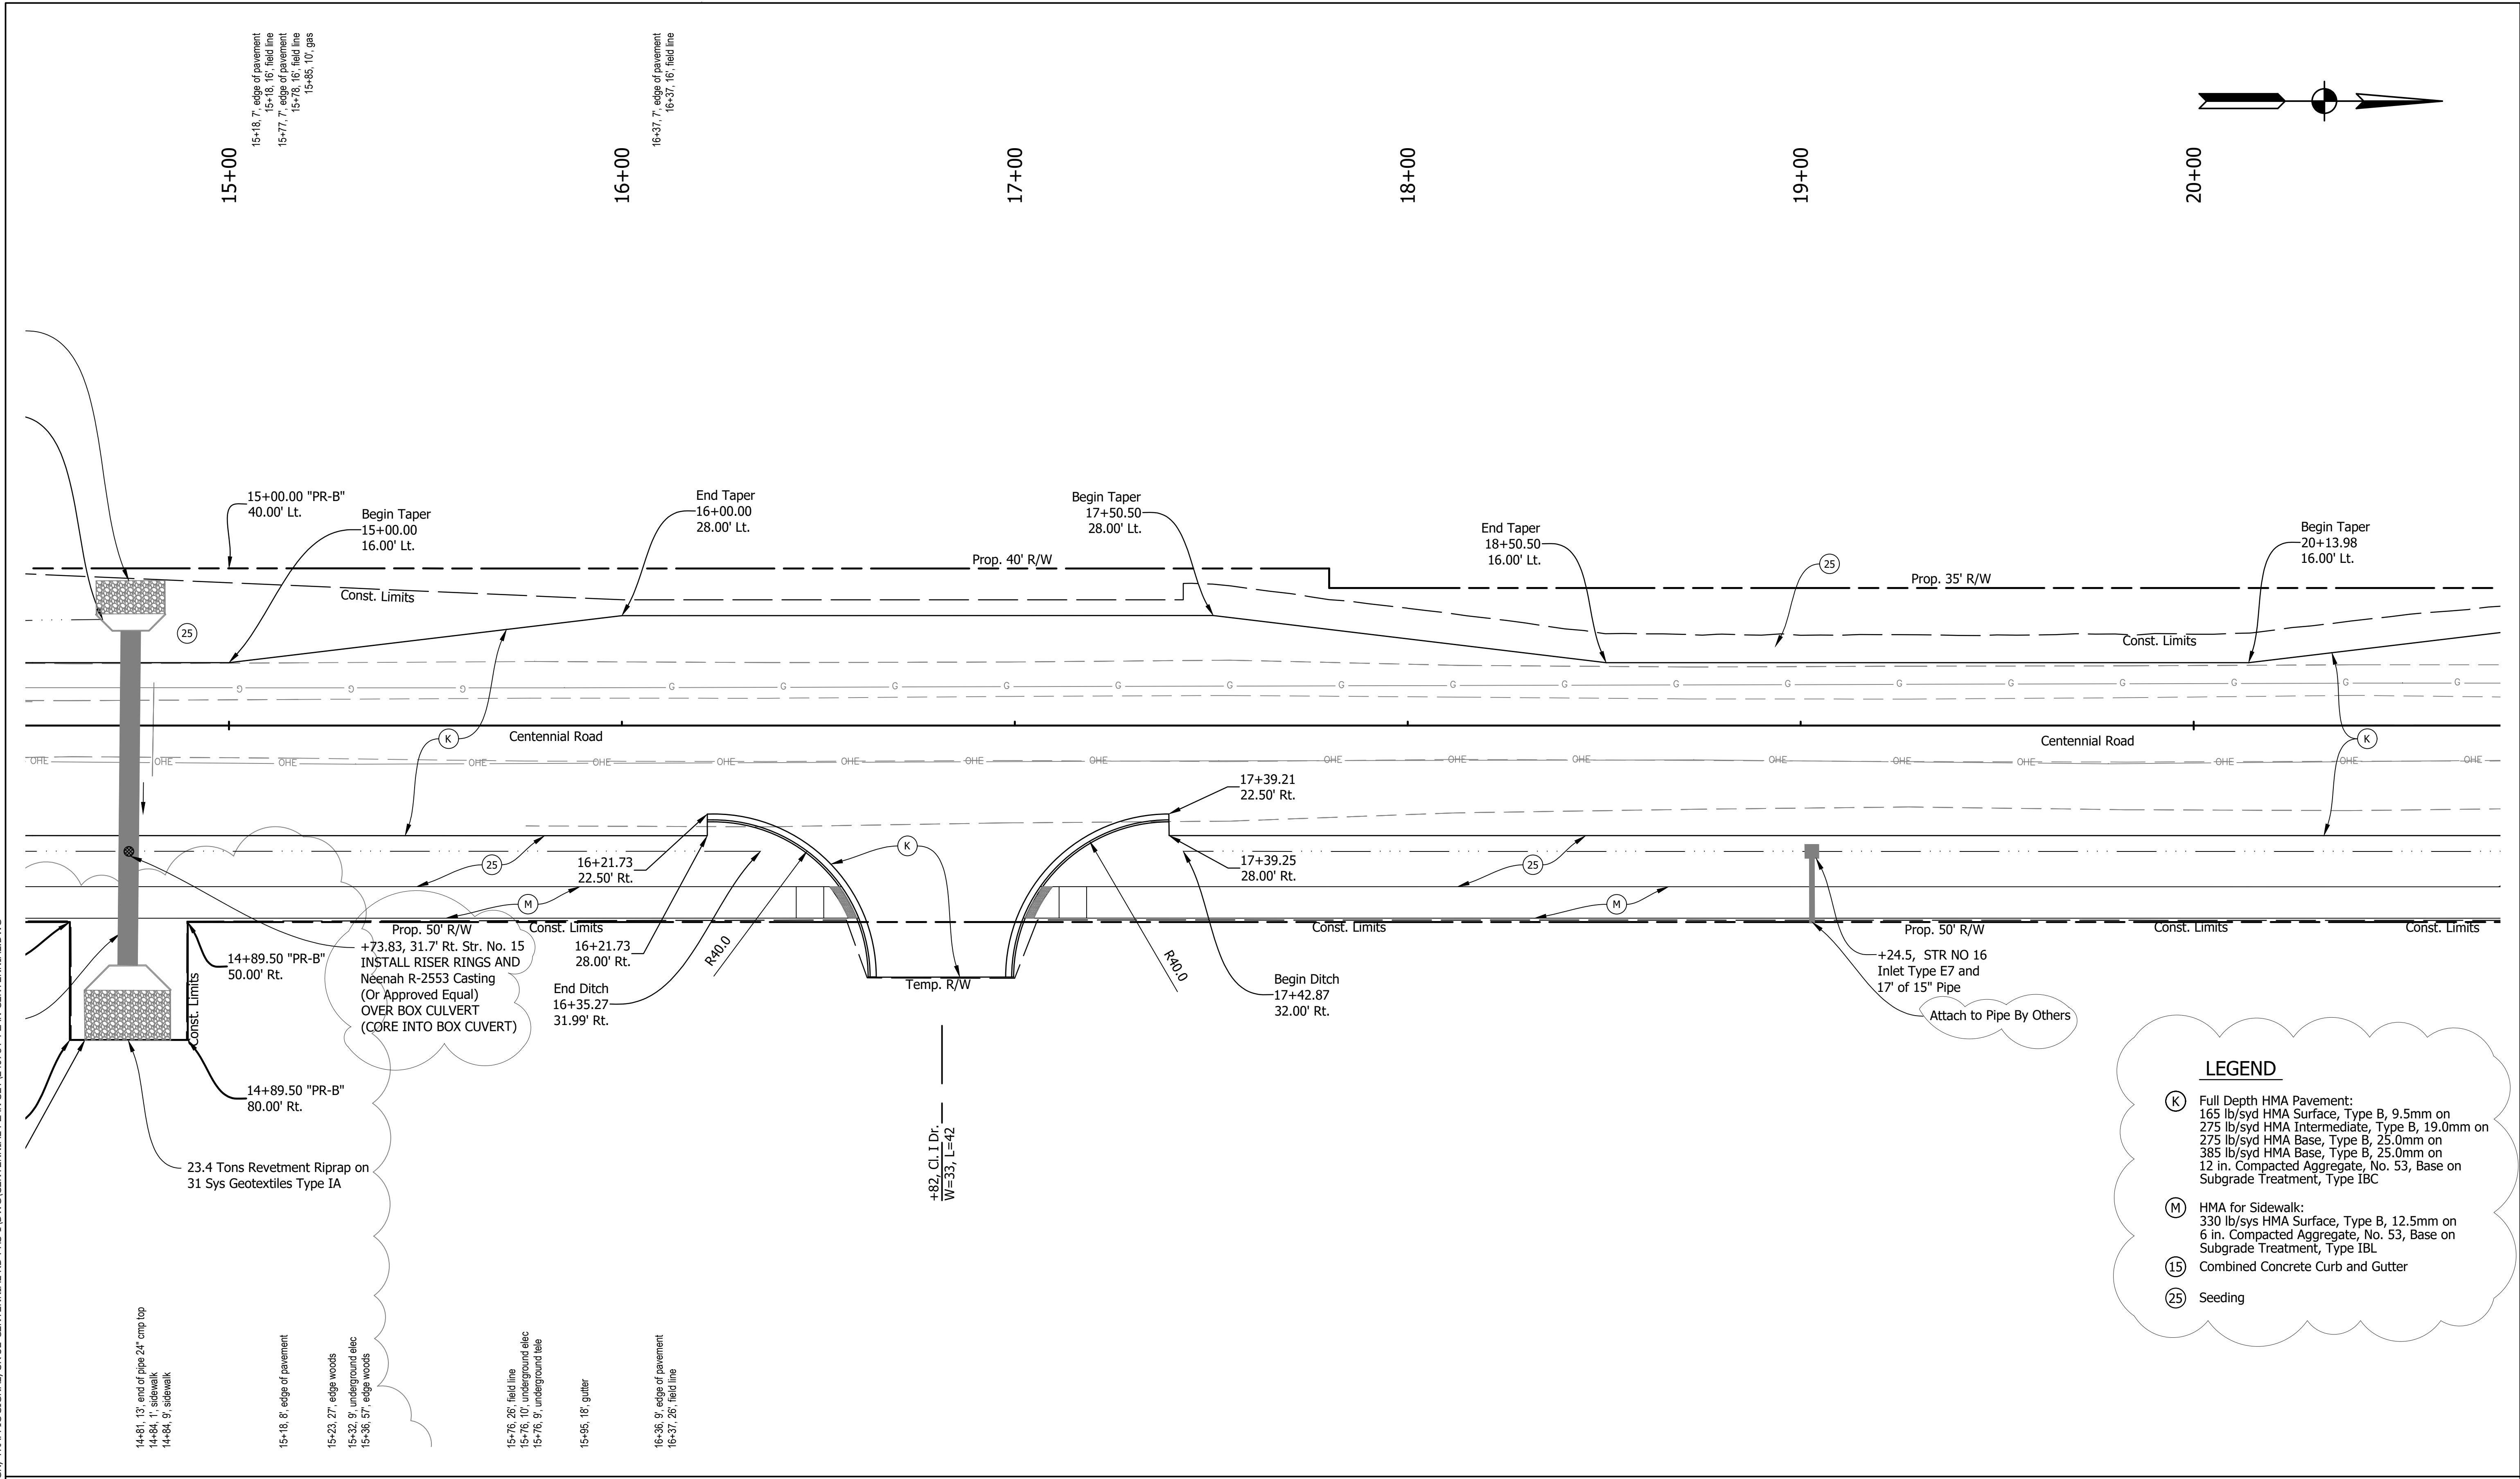


LEGEND

- (K) Full Depth HMA Pavement:
165 lb/syd HMA Surface, Type B, 9.5mm on
275 lb/syd HMA Intermediate, Type B, 19.0mm on
275 lb/syd HMA Base, Type B, 25.0mm on
385 lb/syd HMA Base, Type B, 25.0mm on
12 in. Compacted Aggregate, No. 53, Base on
Subgrade Treatment, Type IBC
- (M) HMA for Sidewalk:
330 lb/sys HMA Surface, Type B, 12.5mm on
6 in. Compacted Aggregate, No. 53, Base on
Subgrade Treatment, Type IBL
- (15) Combined Concrete Curb and Gutter
- (25) Seeding

REVISIONS	
DATE	ITEM
Oct 2, 2025	Added detail notes to box culvert and casting
	Added "Attach to Pipe By Others Note"
	Updated Legend

A&F ENGINEERING
Transportation & Site Engineering
Creating Order Since 1966
8365 Keystone Crossing, Suite 201, Indianapolis, IN. 46240 (317) 202-0864

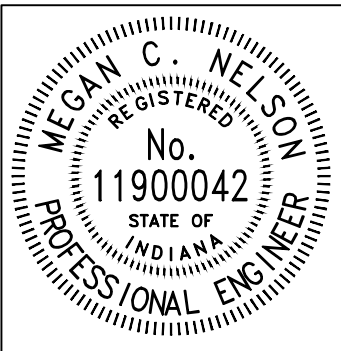



RECOMMENDED FOR APPROVAL	<i>Megan C. Nelson</i>	08/11/2025
DESIGNED:	MCN	DRAWN: AJG
CHECKED:	JAH	CHECKED: JAH


WESTFIELD WASHINGTON SCHOOLS
PLAN - LINE "PR-B" 16+00.00 to 22+00.00

HORIZONTAL SCALE 1" = 20'	BRIDGE FILE N/A
VERTICAL SCALE N/A	DESIGNATION --
SHEETS	
12	of 48
CONTRACT	
--	

 Z:\2024\240787-CONTEXT DESIGN\TRAFFIC SIGNAL, SR 32-CENTENNIAL RD PH5 1.DWG\CENTENNIAL PLAN SET\240787-PLAN CENTENNIAL.DWG

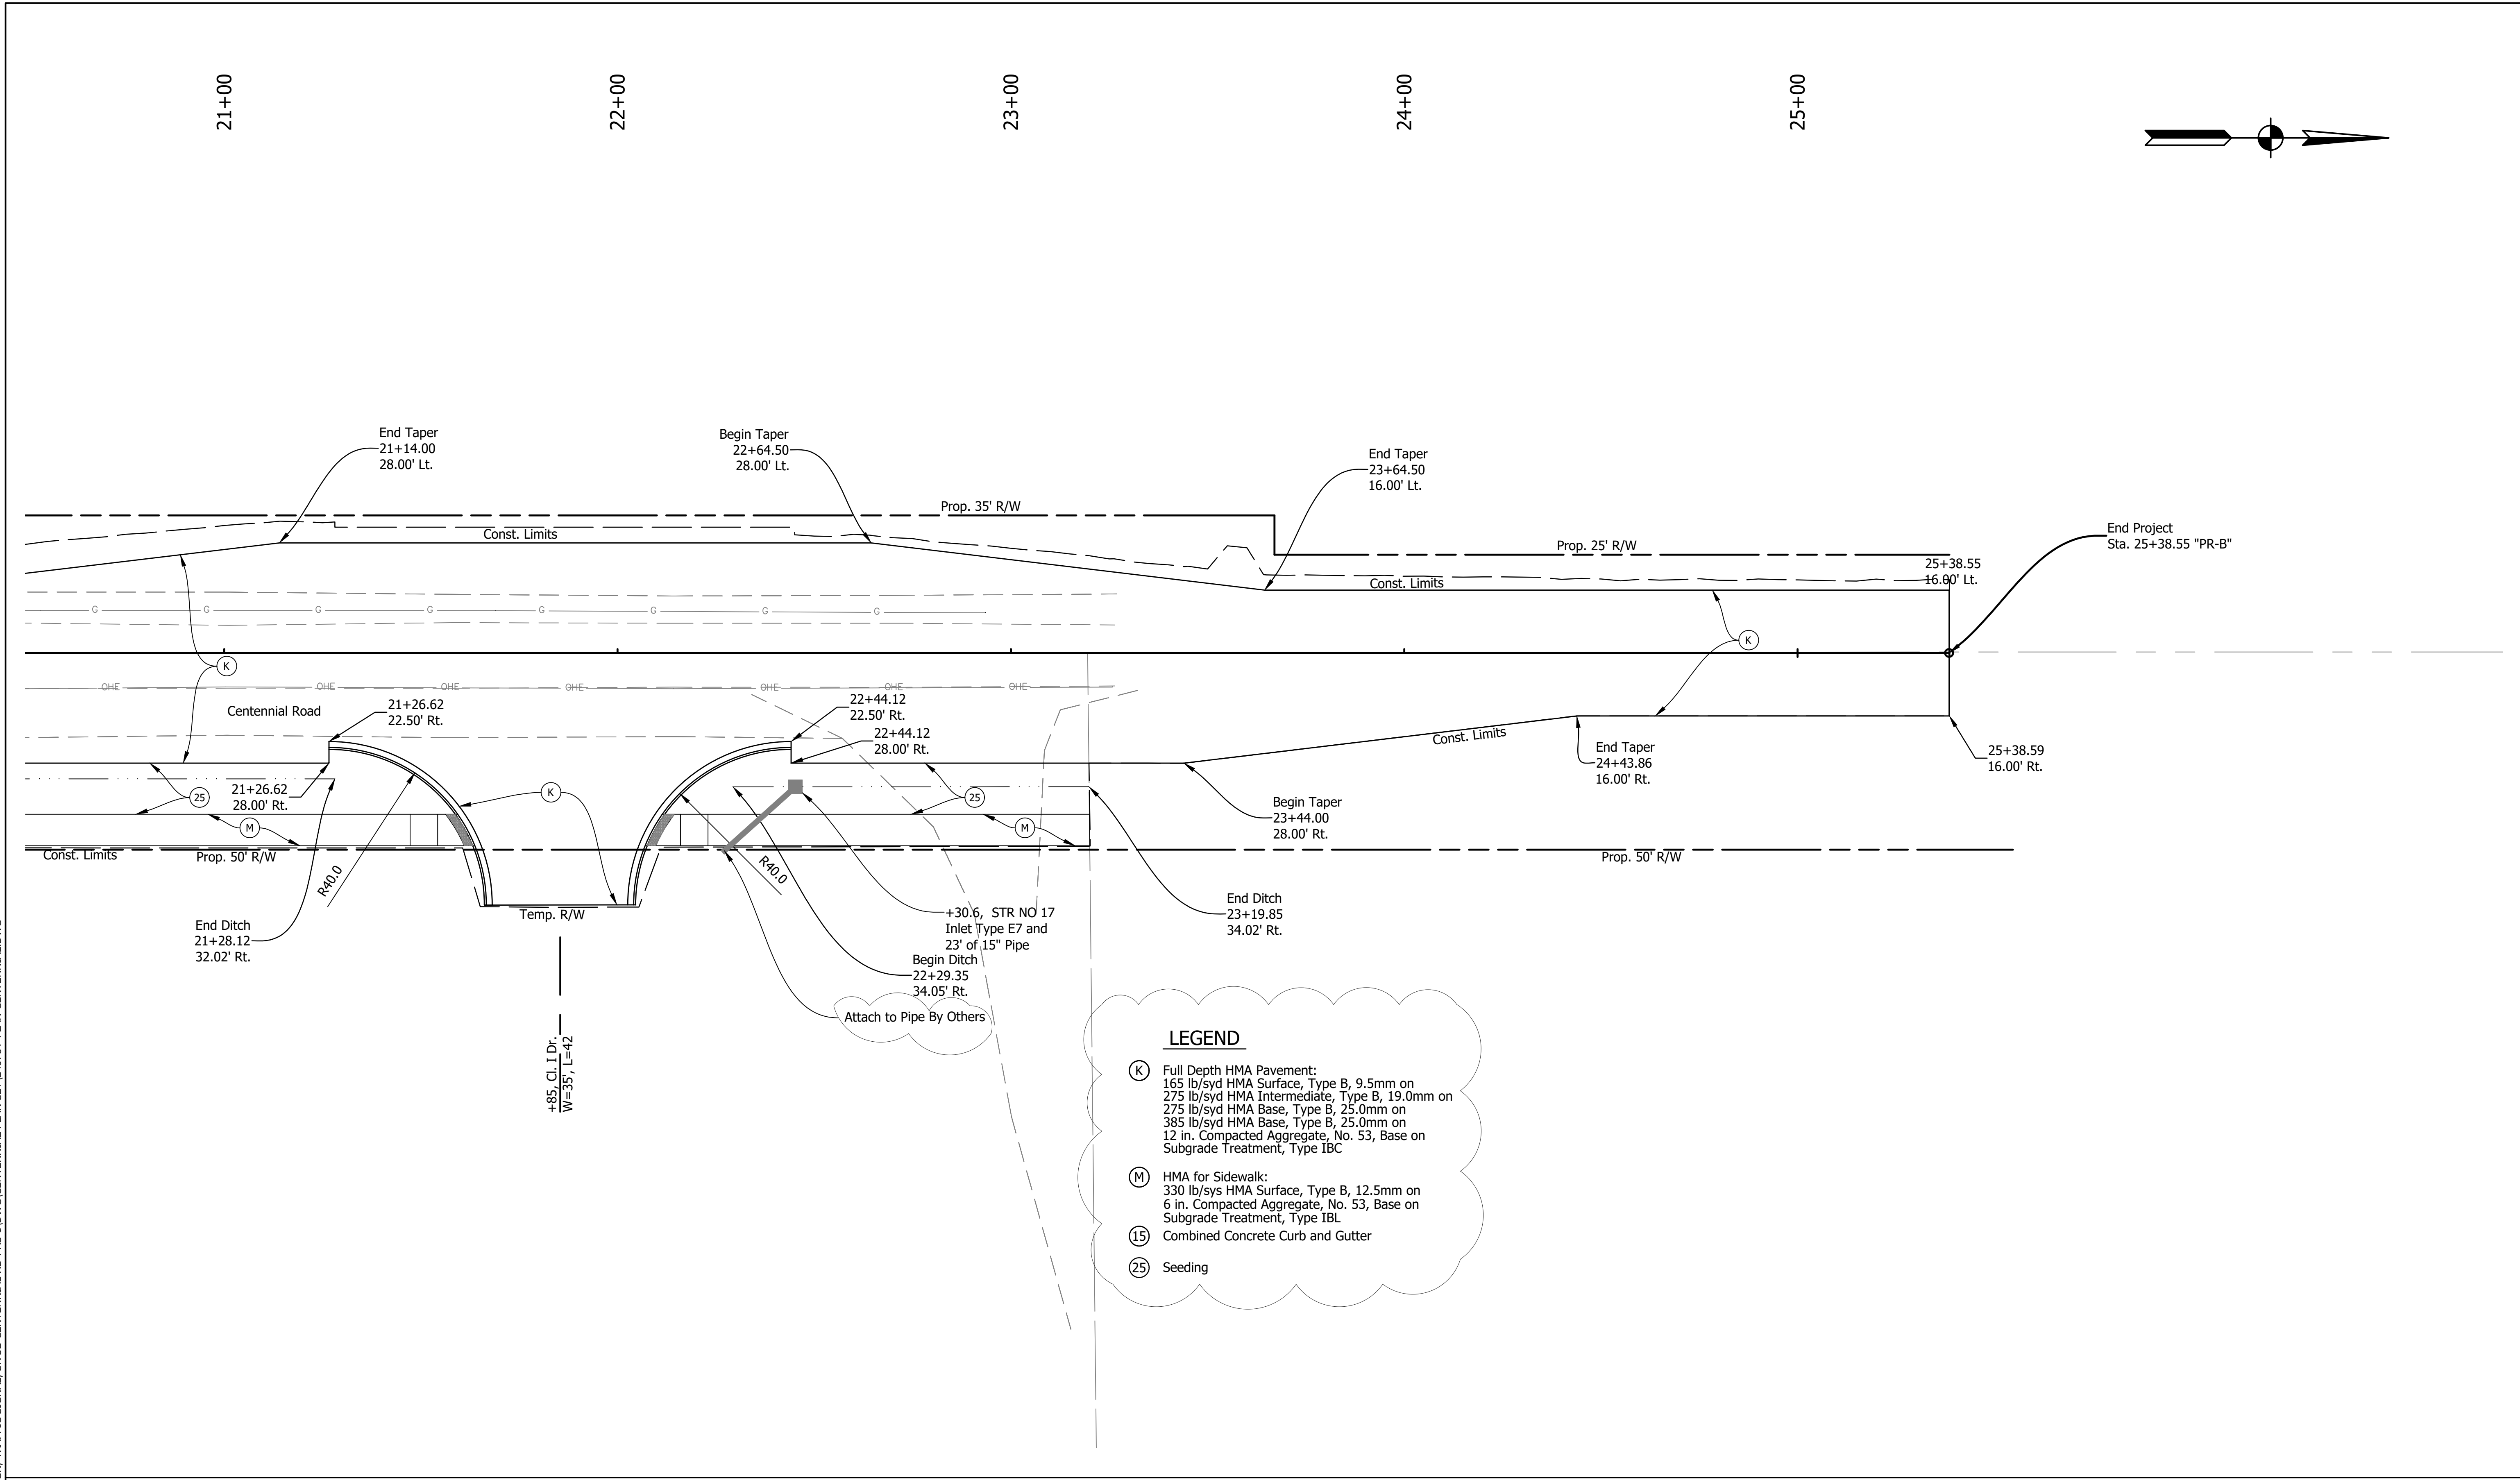


REVISIONS		 A&F ENGINEERING Transportation & Site Engineering Creating Order Since 1966 8365 Keystone Crossing, Suite 201, Indianapolis, IN. 46240 (317) 202-0864		RECOMMENDED FOR APPROVAL		WESTFIELD WASHINGTON SCHOOLS		HORIZONTAL SCALE		BRIDGE FILE	
DATE	ITEM			08/11/2025				1" = 20'		N/A	
Oct 2, 2025	Added "Attach to Pipe By Others" Note			DESIGN ENGINEER				VERTICAL SCALE		DESIGNATION	
	Updated Legend			DATE				N/A		--	
				DESIGNED: MCN		DRAWN: AJG		PLAN - LINE "PR-B" 22+00.00 to 28+00.00			
				CHECKED: JAH		CHECKED: JAH					
								SHEETS			
						14 of 48		CONTRACT			
								--			

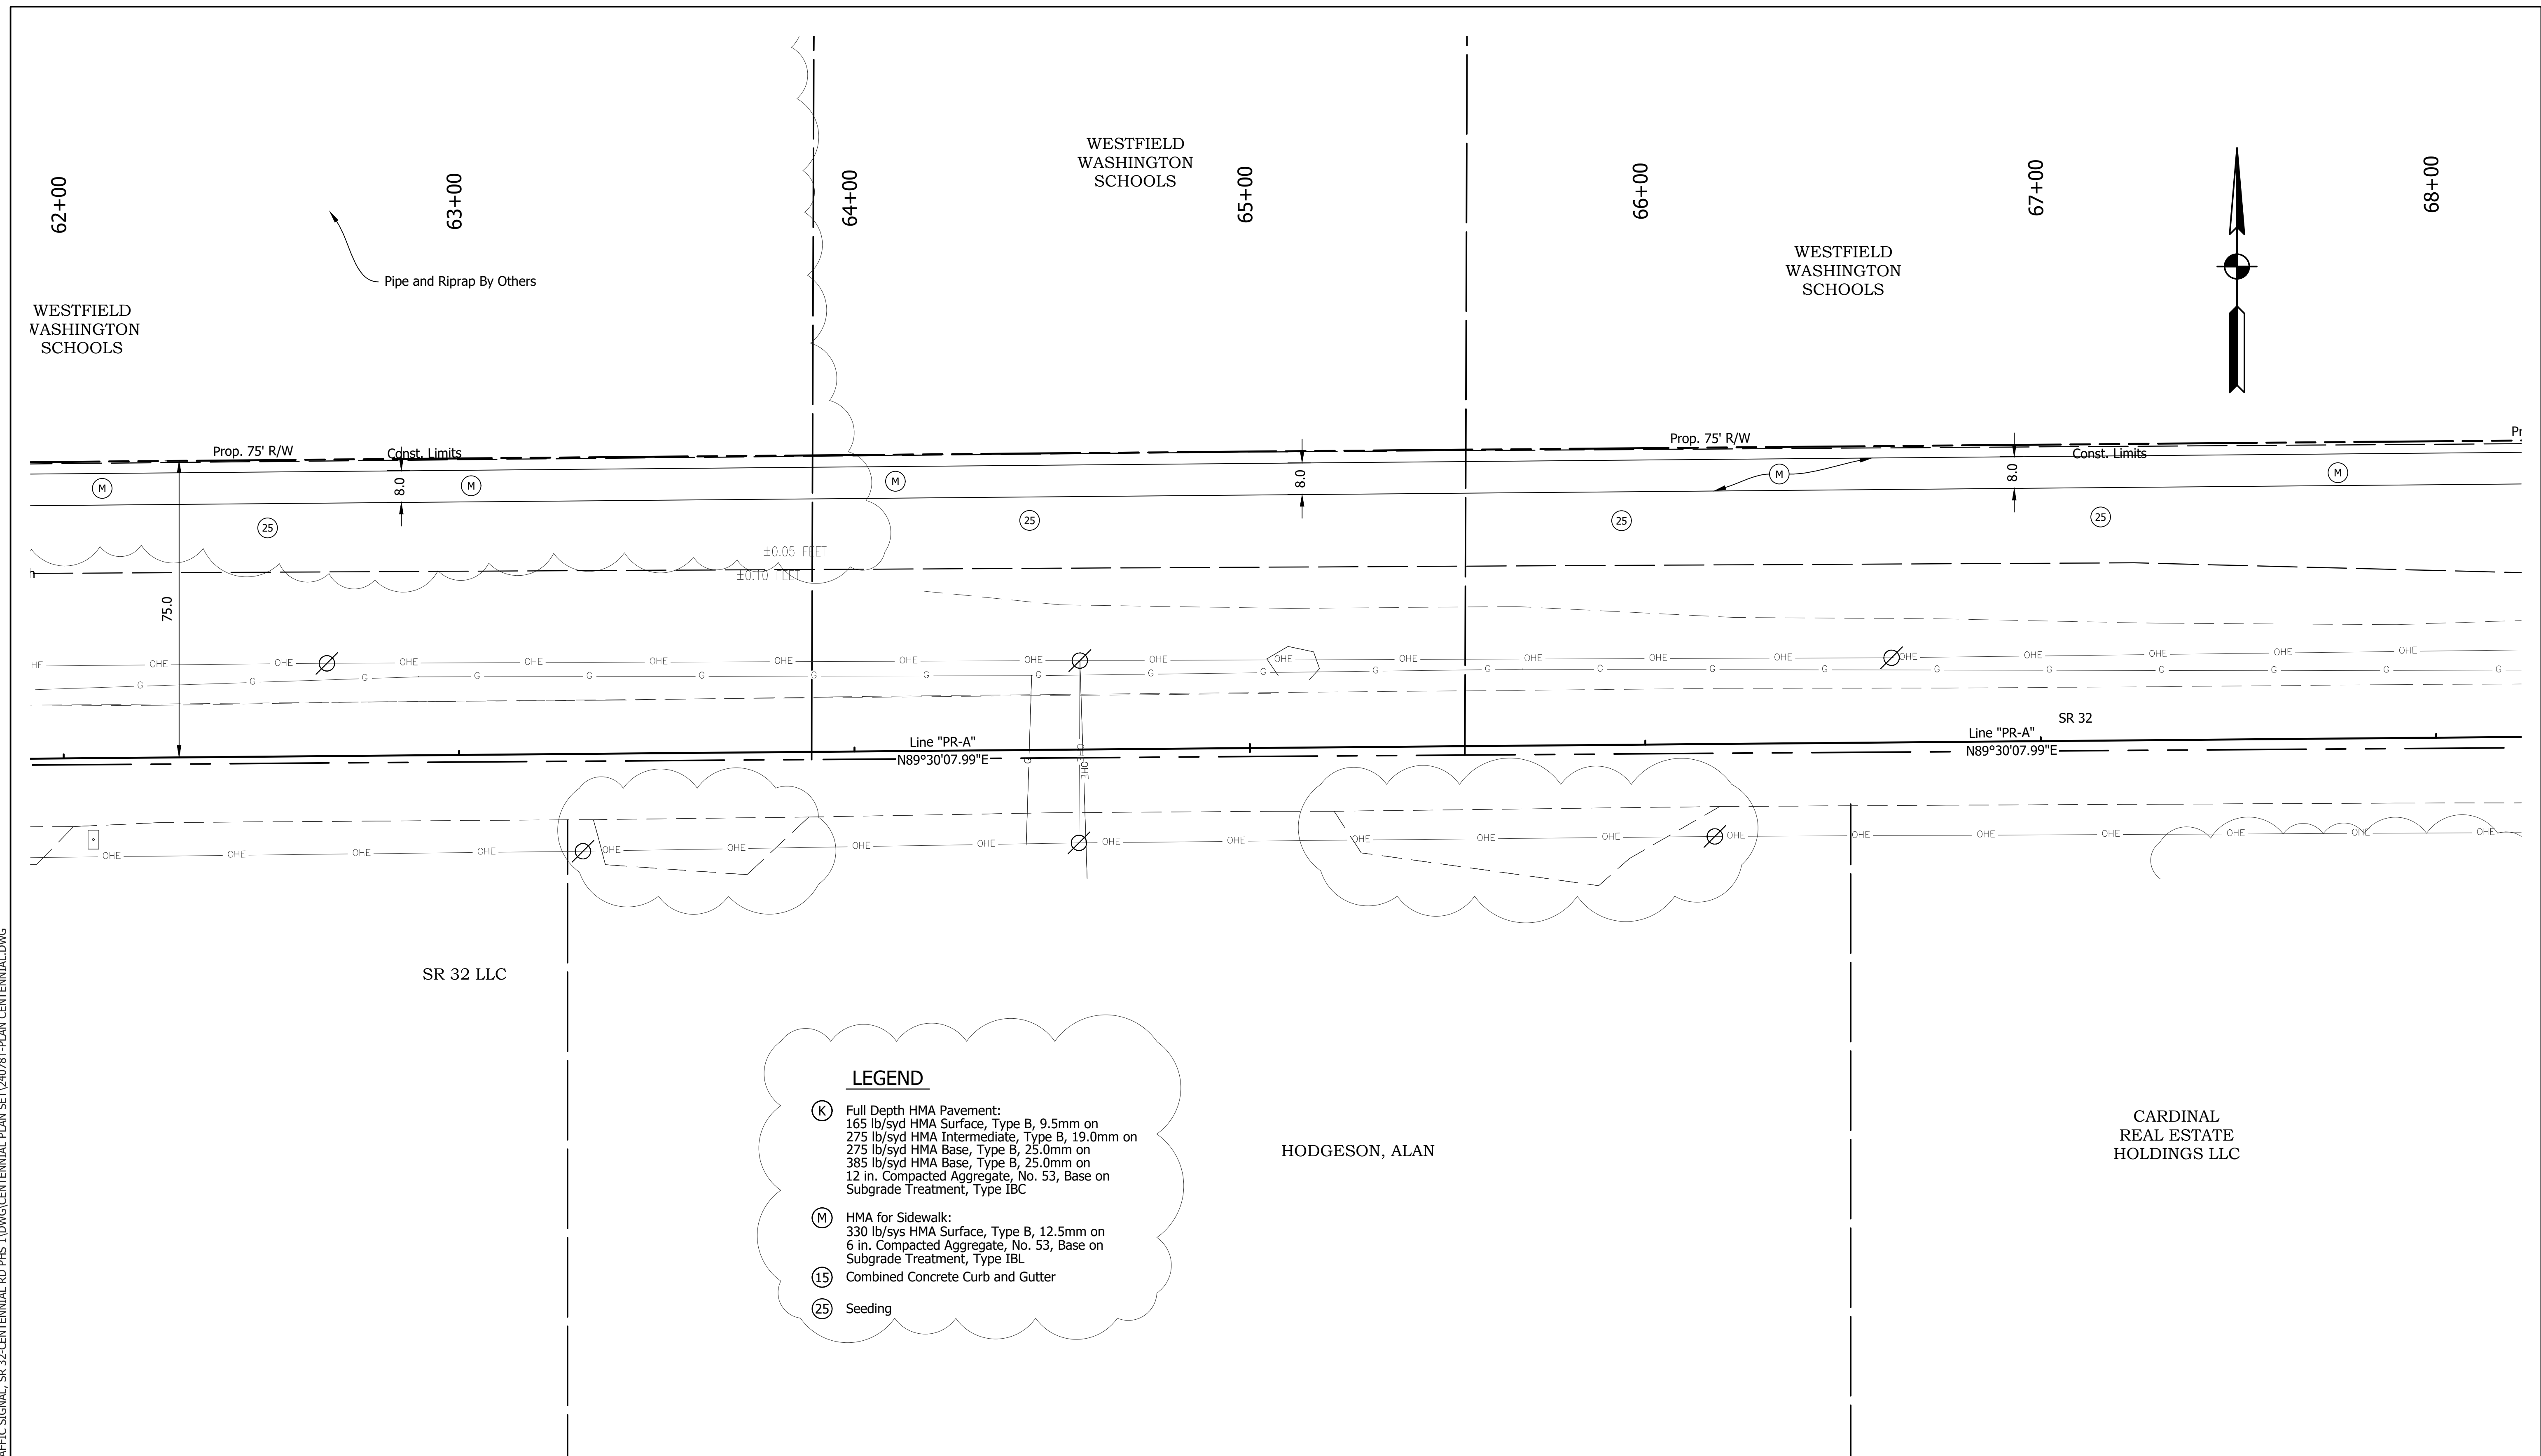

REVISIONS		A&F ENGINEERING Transportation & Site Engineering Creating Order Since 1966 8365 Keystone Crossing, Suite 201, Indianapolis, IN. 46240 (317) 202-0864	MEGAN C. NELSON REGISTERED No. 11900042 STATE OF INDIANA PROFESSIONAL ENGINEER	RECOMMENDED FOR APPROVAL Megan C. Nelson DESIGN ENGINEER 08/11/2025 DATE		WESTFIELD WASHINGTON SCHOOLS		HORIZONTAL SCALE 1" = 20'		BRIDGE FILE N/A	
DATE	ITEM			DESIGNED: MCN		DRAWN: AJG		VERTICAL SCALE N/A		DESIGNATION --	
Oct 2, 2025	Updated Legend			CHECKED: JAH		CHECKED: JAH		PLAN - LINE "PR-A"		SHEETS 16 of 48	
	Removed Excess Notes							STA. 62+00.00 TO STA. 68+00.00		CONTRACT --	

Z:\2024\240787-CONTEXT DESIGN\TRAFFIC SIGNAL, SR 32-CENTENNIAL RD PH5 1\DWG\CENTENNIAL PLAN SET\240787-PLAN CENTENNIAL.DWG

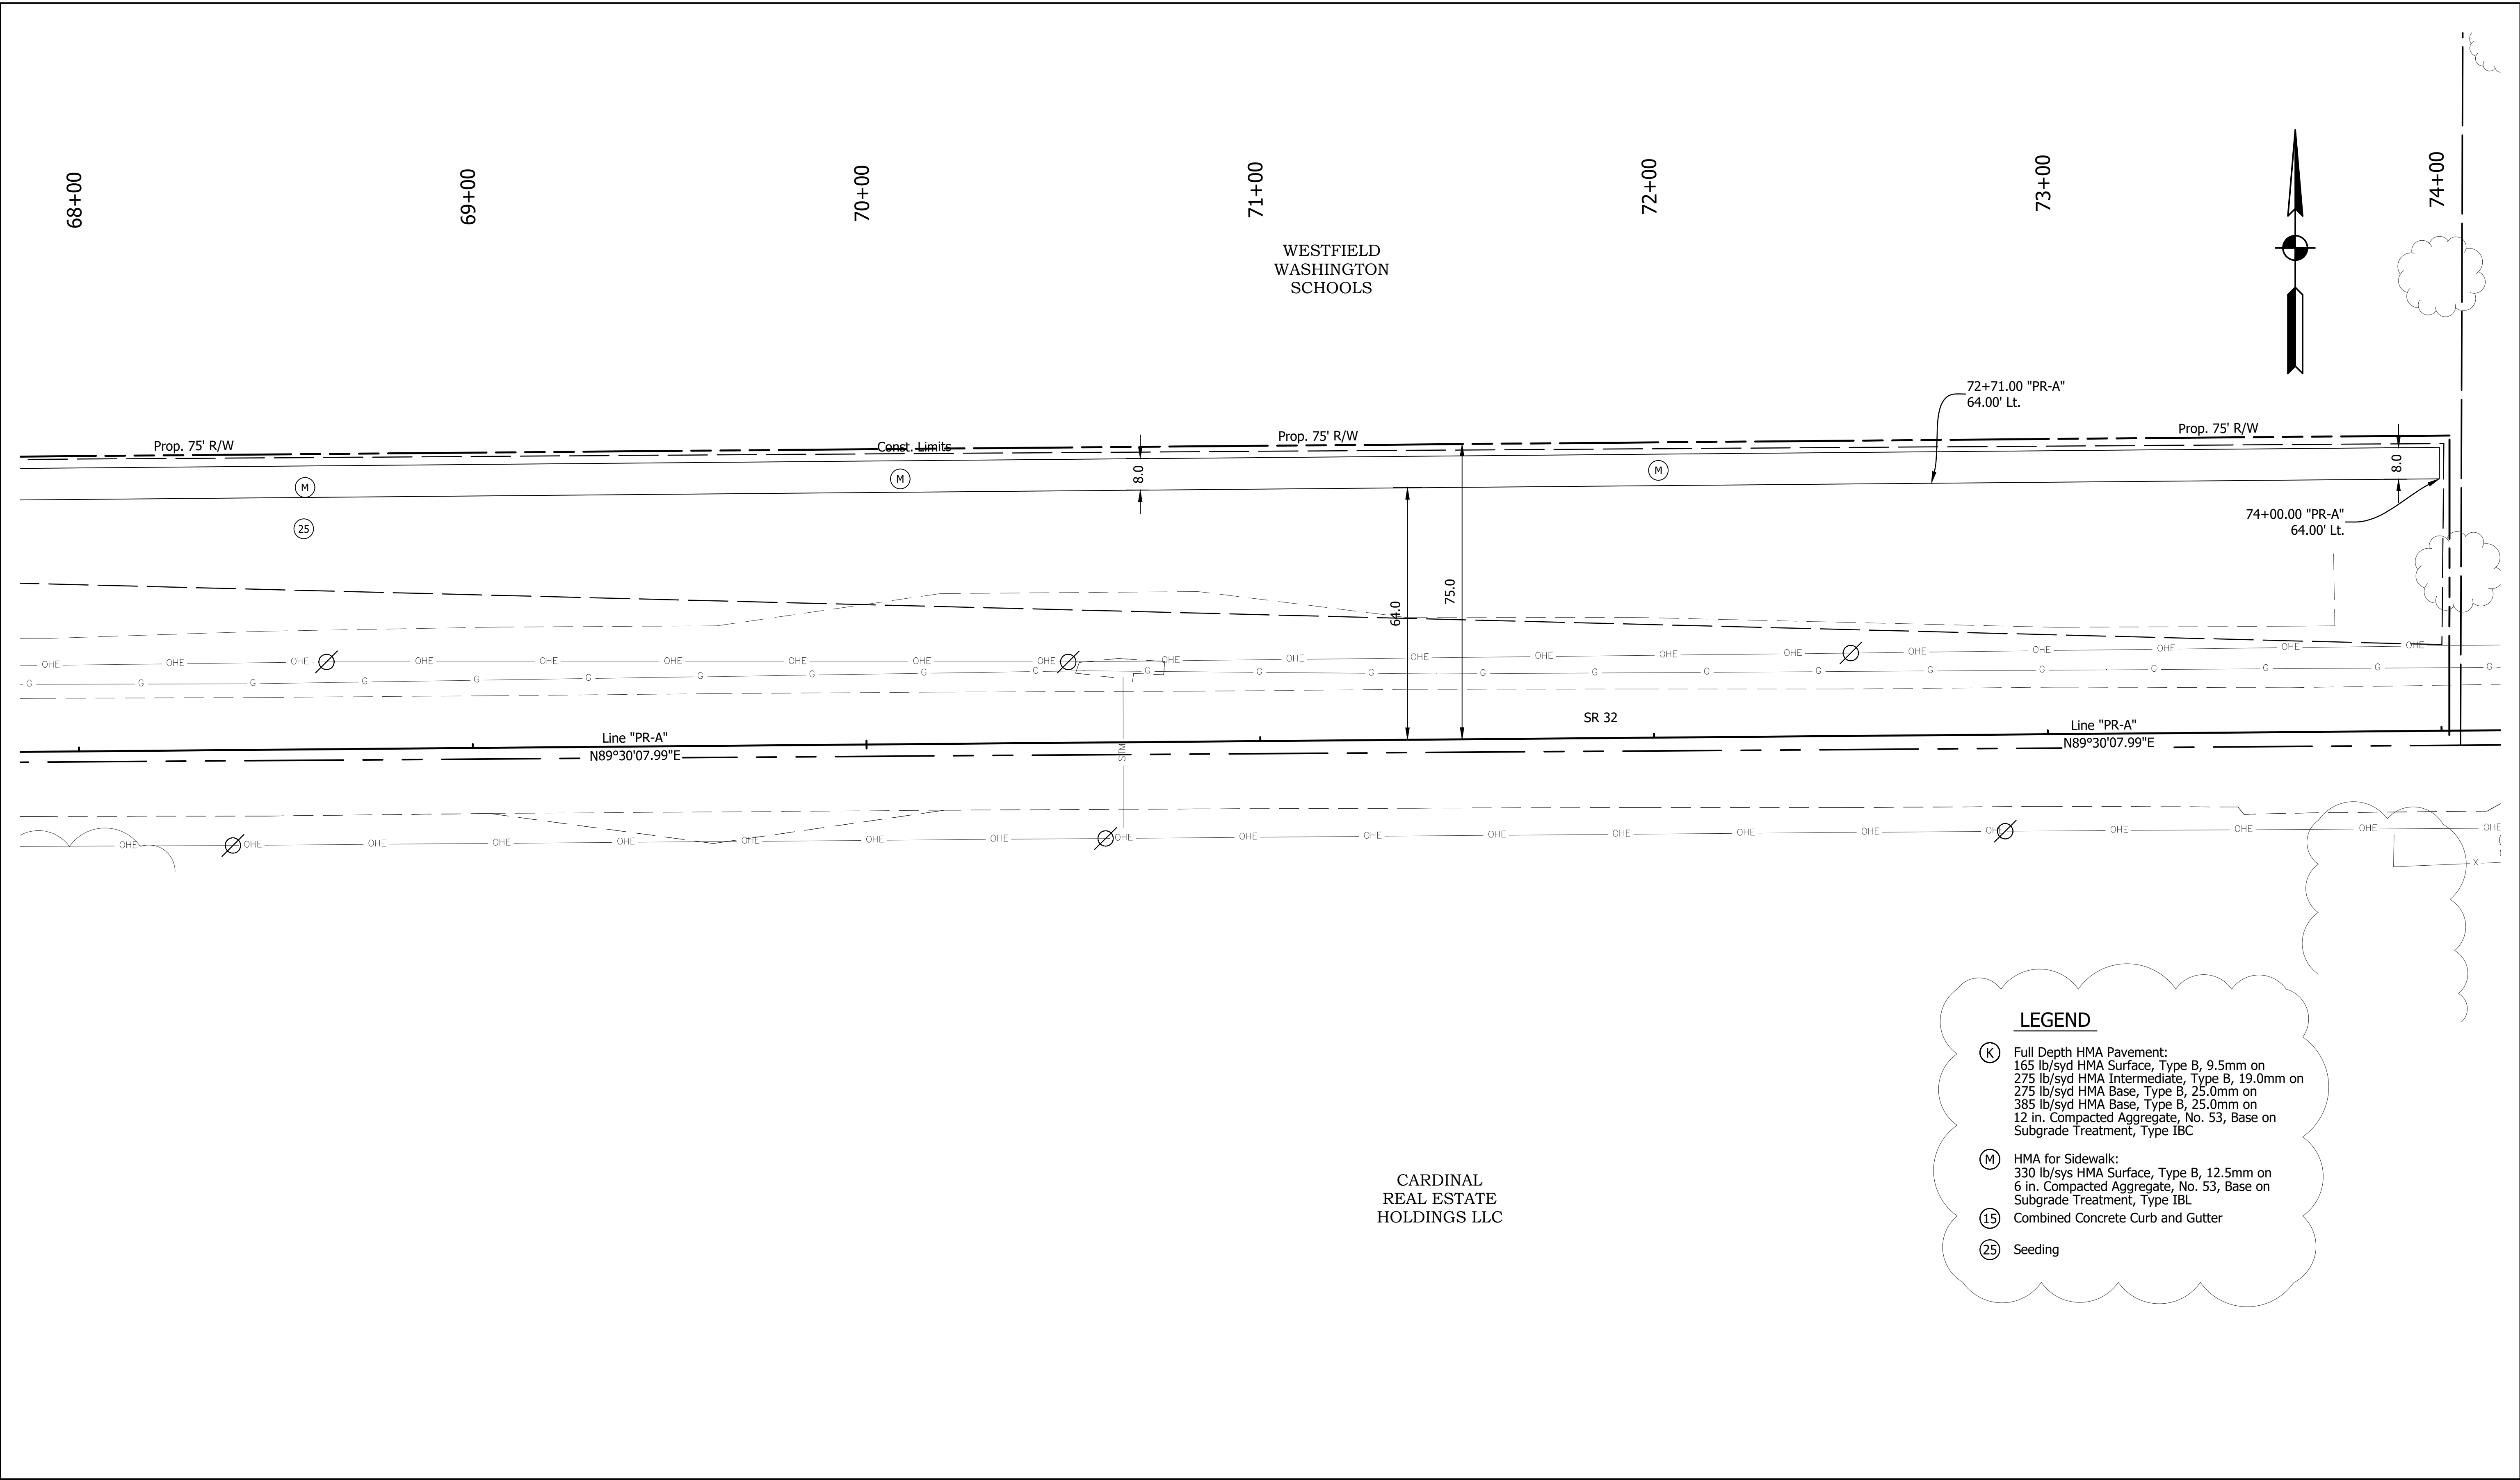


CARDINAL
REAL ESTATE
HOLDINGS LLC

LEGEND

- (K) Full Depth HMA Pavement:
165 lb/syd HMA Surface, Type B, 9.5mm on
275 lb/syd HMA Intermediate, Type B, 19.0mm on
275 lb/syd HMA Base, Type B, 25.0mm on
385 lb/syd HMA Base, Type B, 25.0mm on
12 in. Compacted Aggregate, No. 53, Base on
Subgrade Treatment, Type IBC
- (M) HMA for Sidewalk:
330 lb/sys HMA Surface, Type B, 12.5mm on
6 in. Compacted Aggregate, No. 53, Base on
Subgrade Treatment, Type IBL
- (15) Combined Concrete Curb and Gutter
- (25) Seeding

REVISIONS	
DATE	ITEM
Oct 2, 2025	Updated Legend

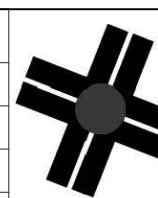


A&F ENGINEERING

Transportation & Site Engineering

Creating Order Since 1966

8365 Keystone Crossing, Suite 201, Indianapolis, IN. 46240 (317) 202-0864

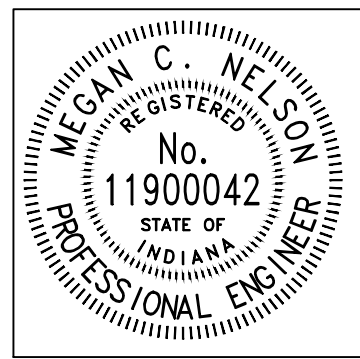





RECOMMENDED FOR APPROVAL		08/11/2025	
		DATE	
DESIGNED:	MCN	DRAWN:	AJG
CHECKED:	JAH	CHECKED:	JAH

WESTFIELD
WASHINGTON SCHOOLS

PLAN - LINE "PR-A"
STA. 68+00.00 TO STA. 74+00.00


HORIZONTAL SCALE 1" = 20'	BRIDGE FILE N/A
VERTICAL SCALE N/A	DESIGNATION --
SHEETS	
17	of 48
CONTRACT	
--	

Z:\2024\240787-CONTEXT DESIGN TRAFFIC SIGNAL, SR 32-CENTENNIAL RD PH5 1DWS\CENTENNIAL PLAN SET\240787-TYP CENTENNIAL.DWG

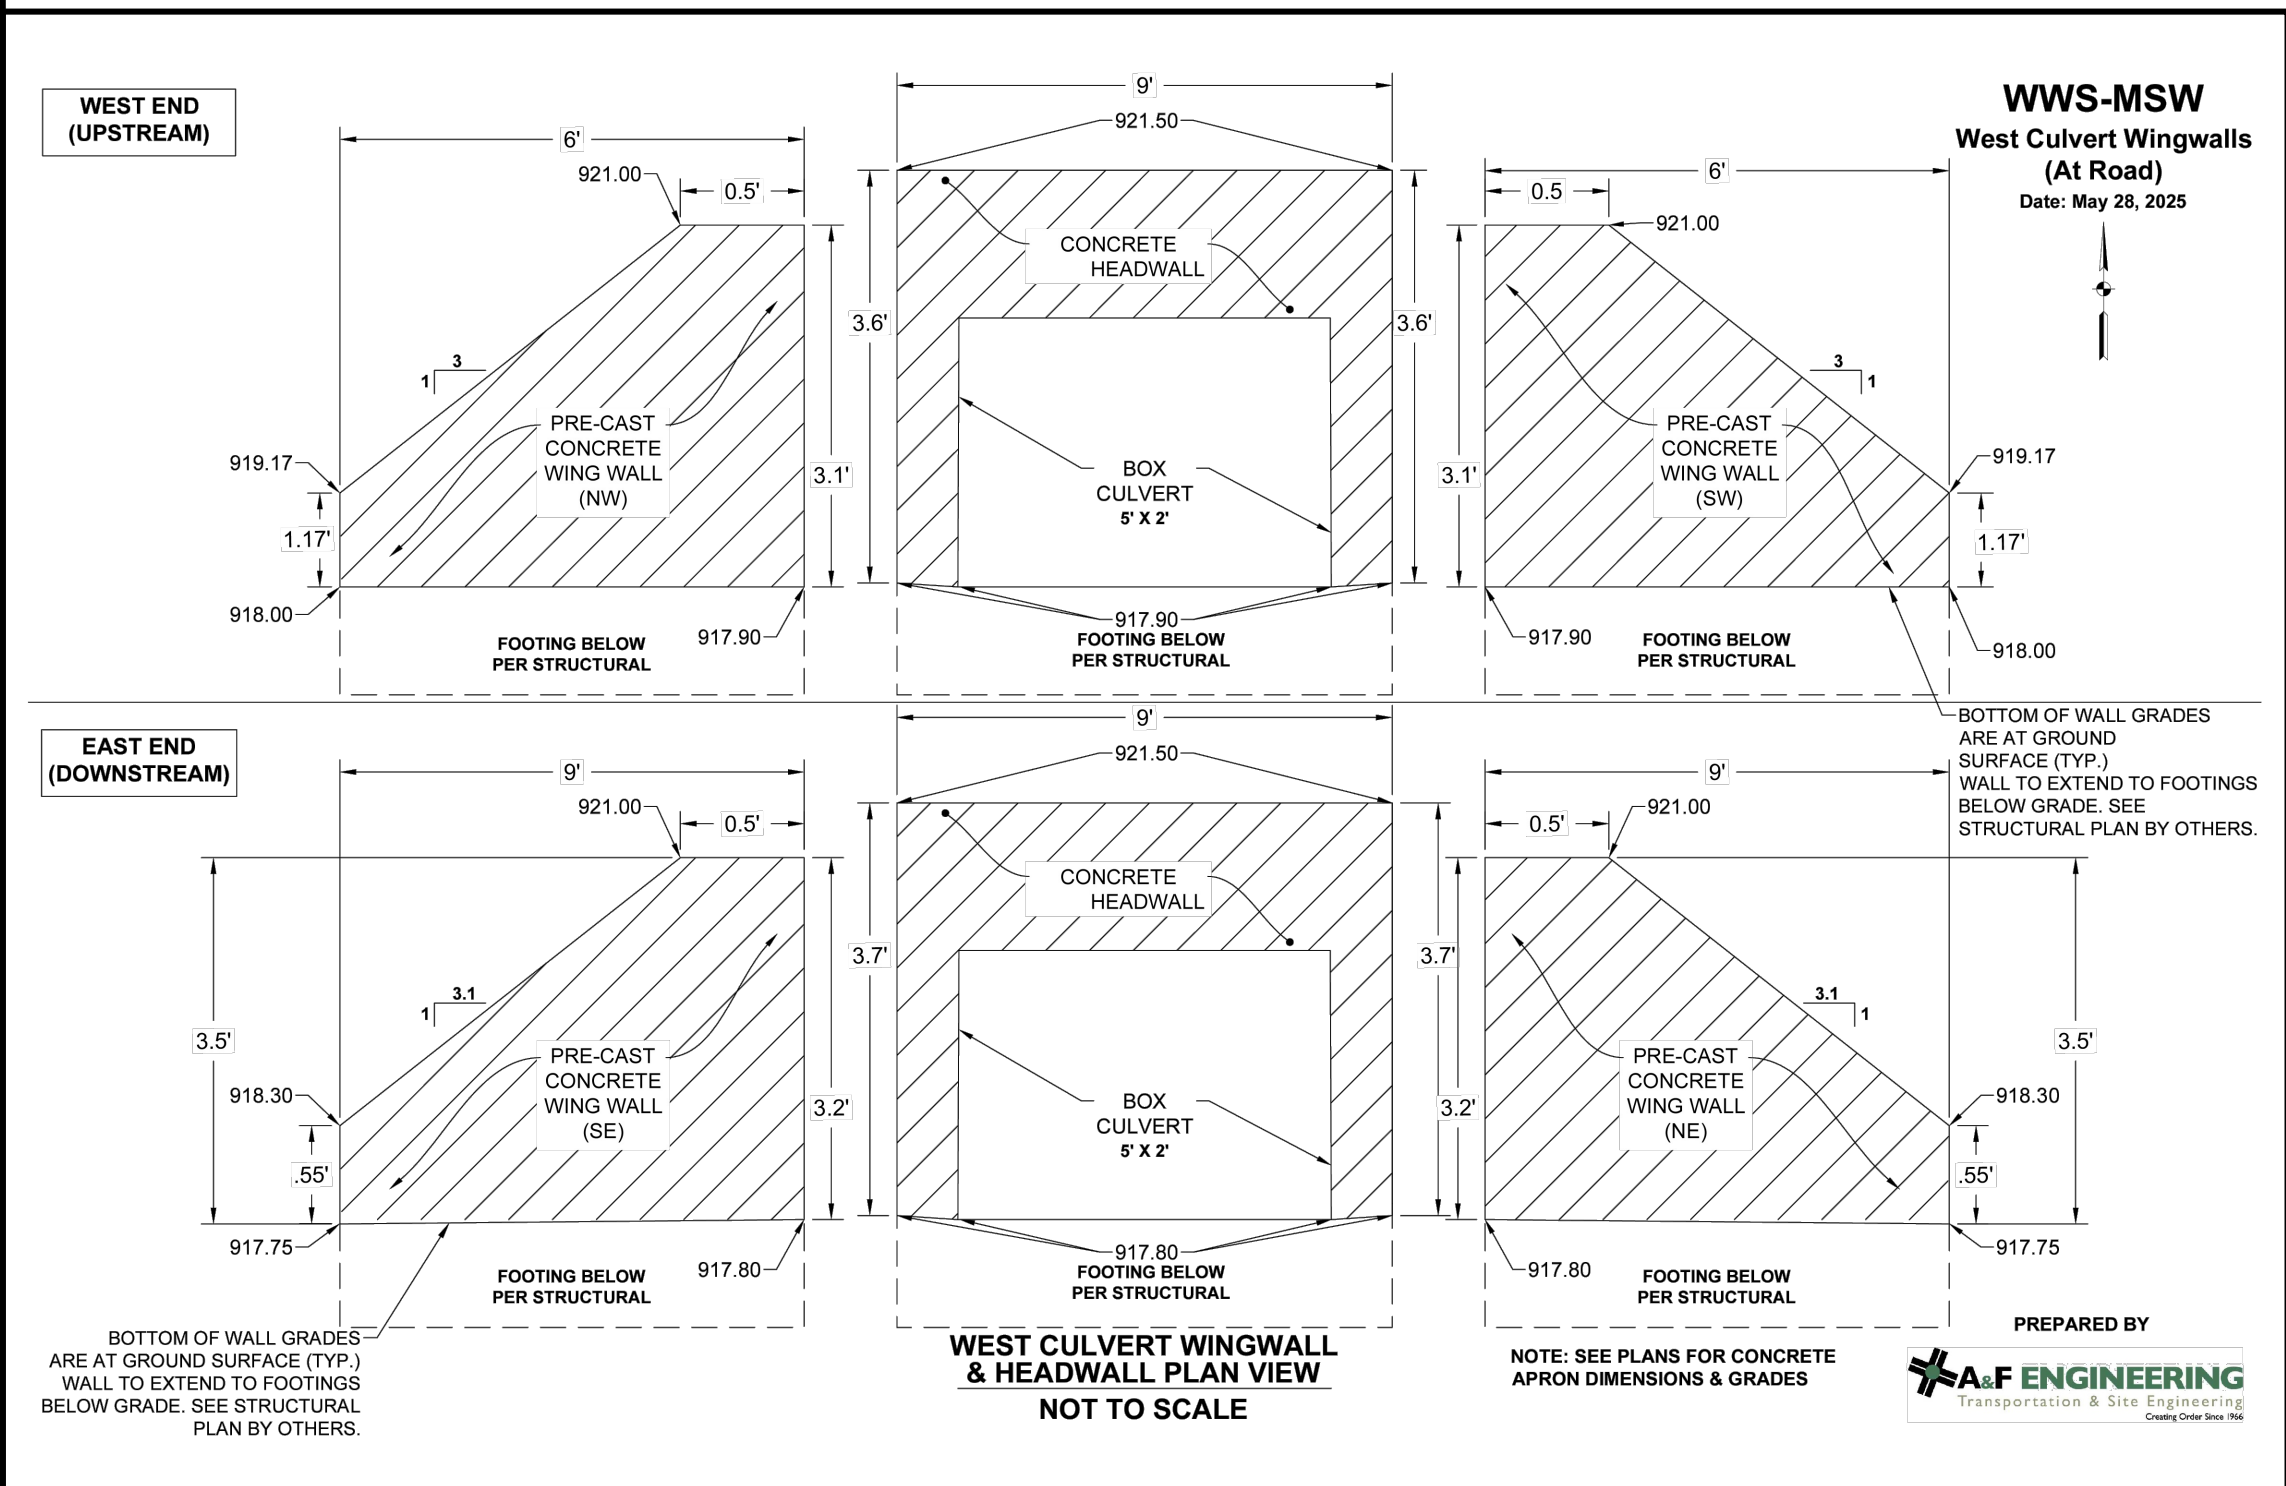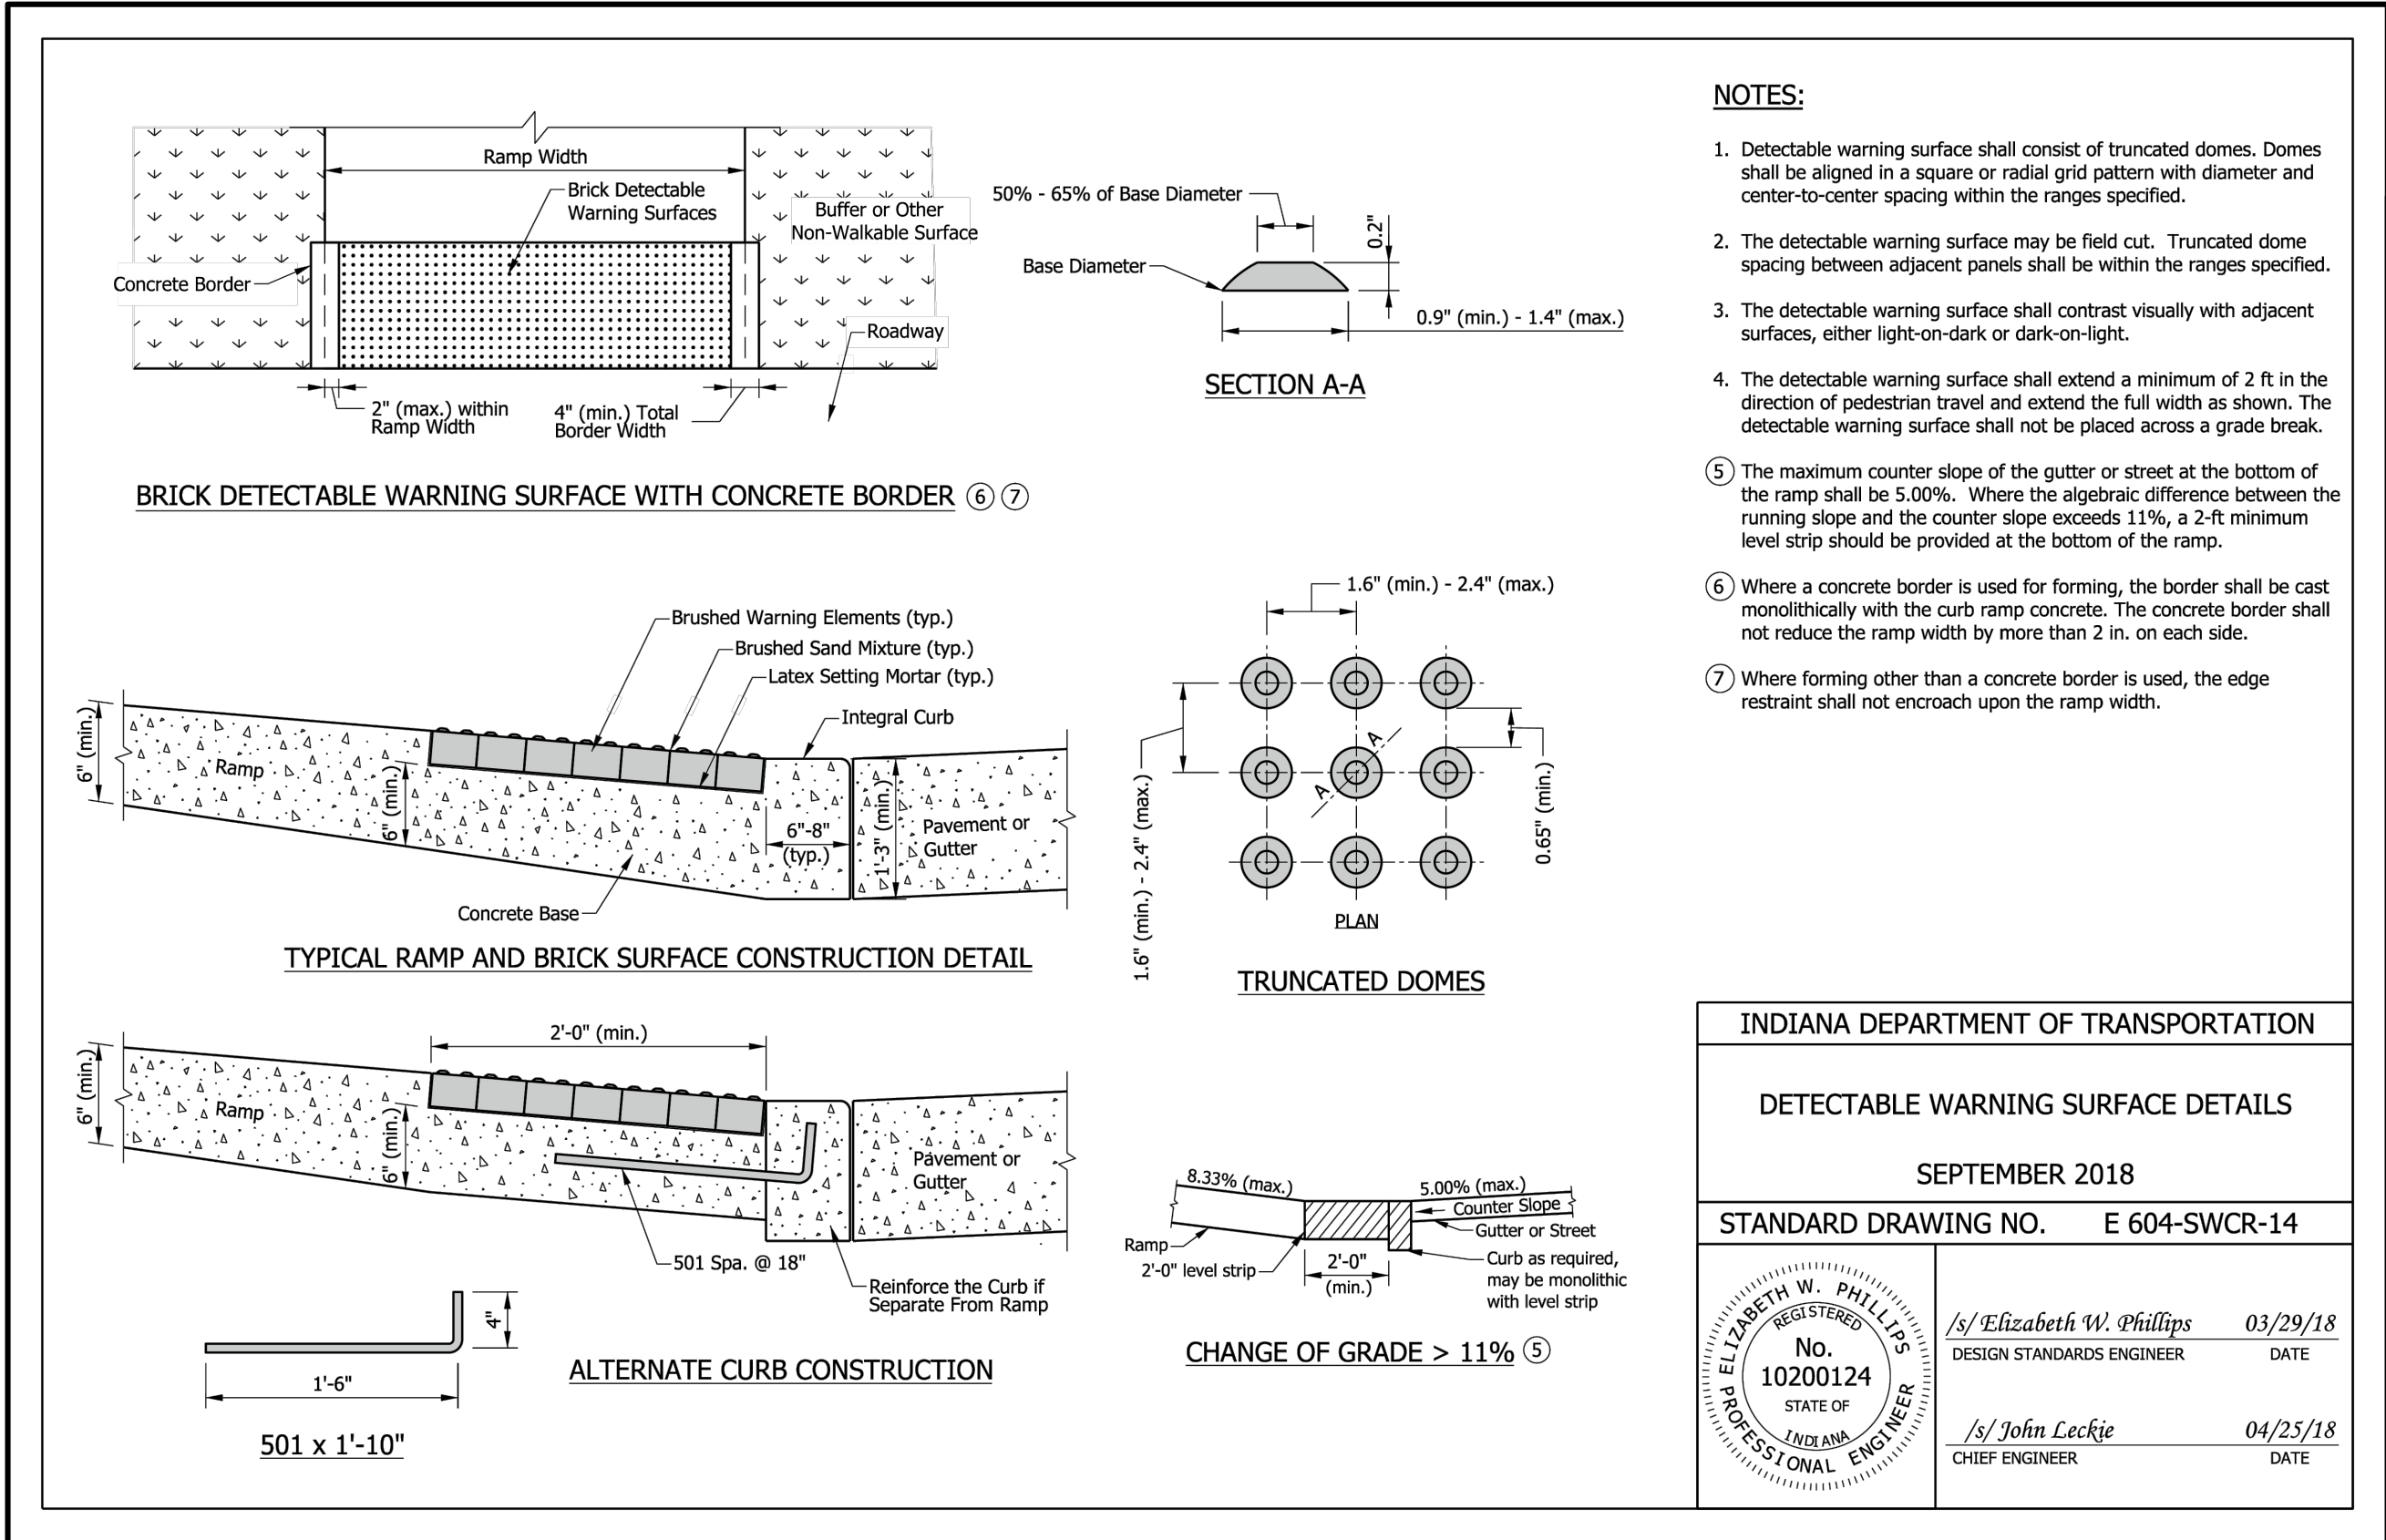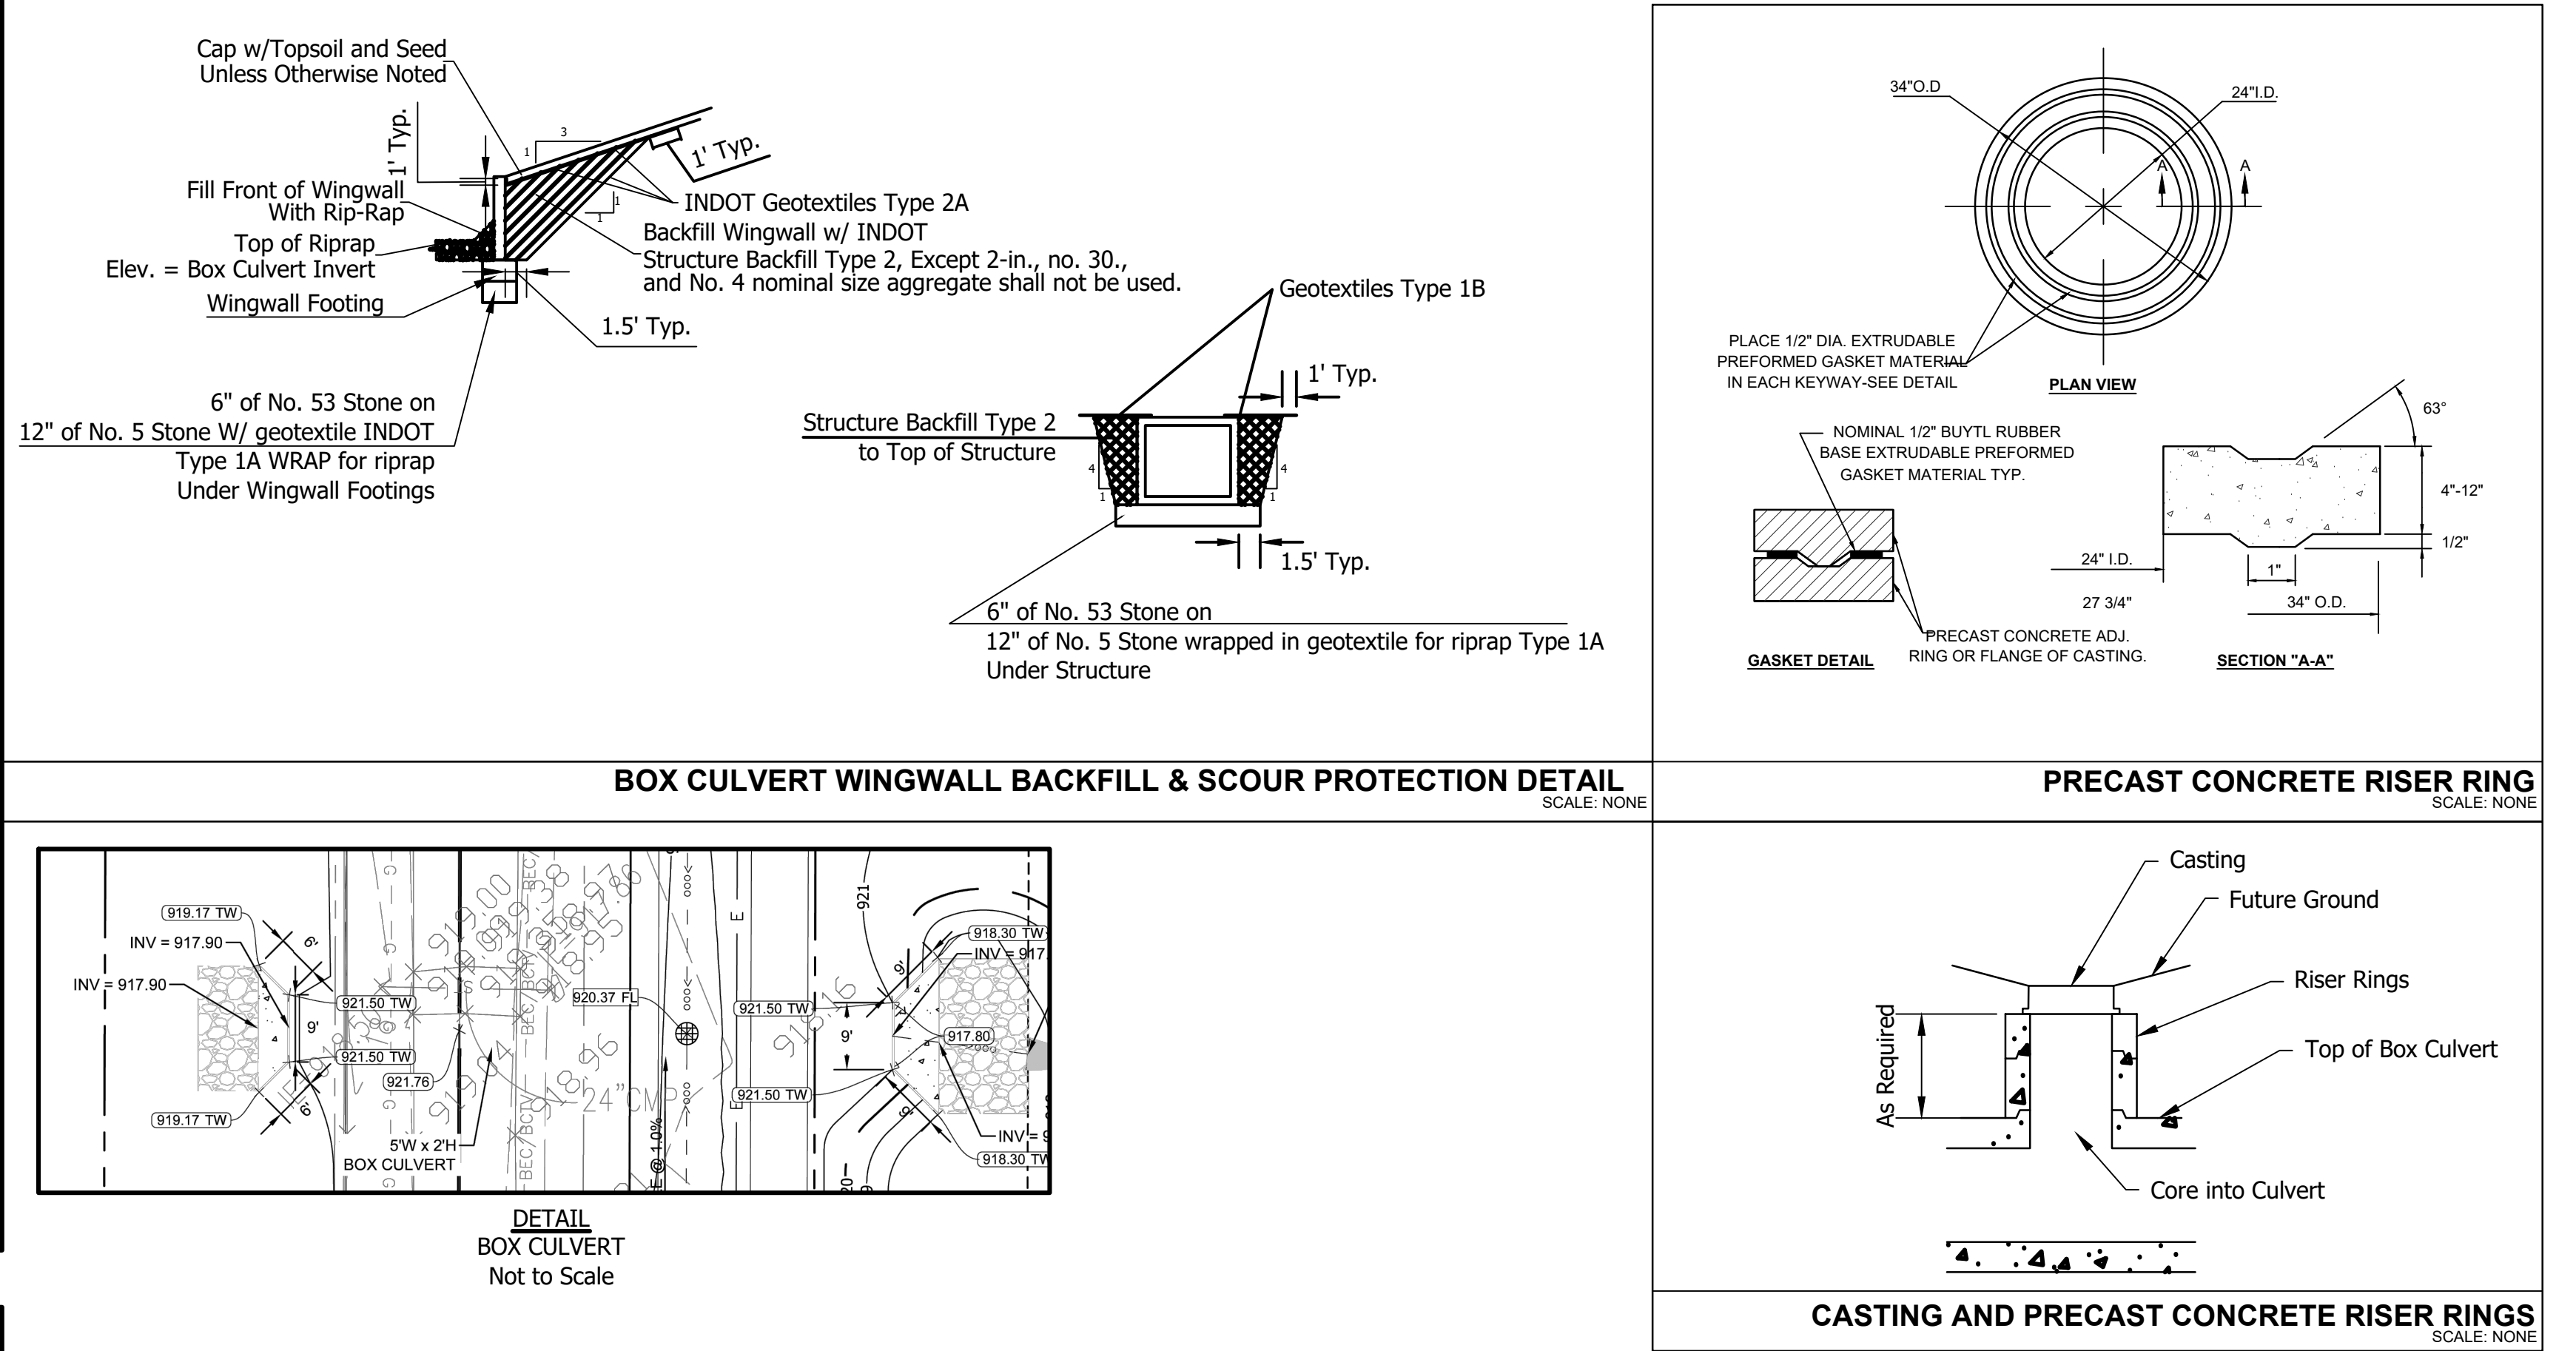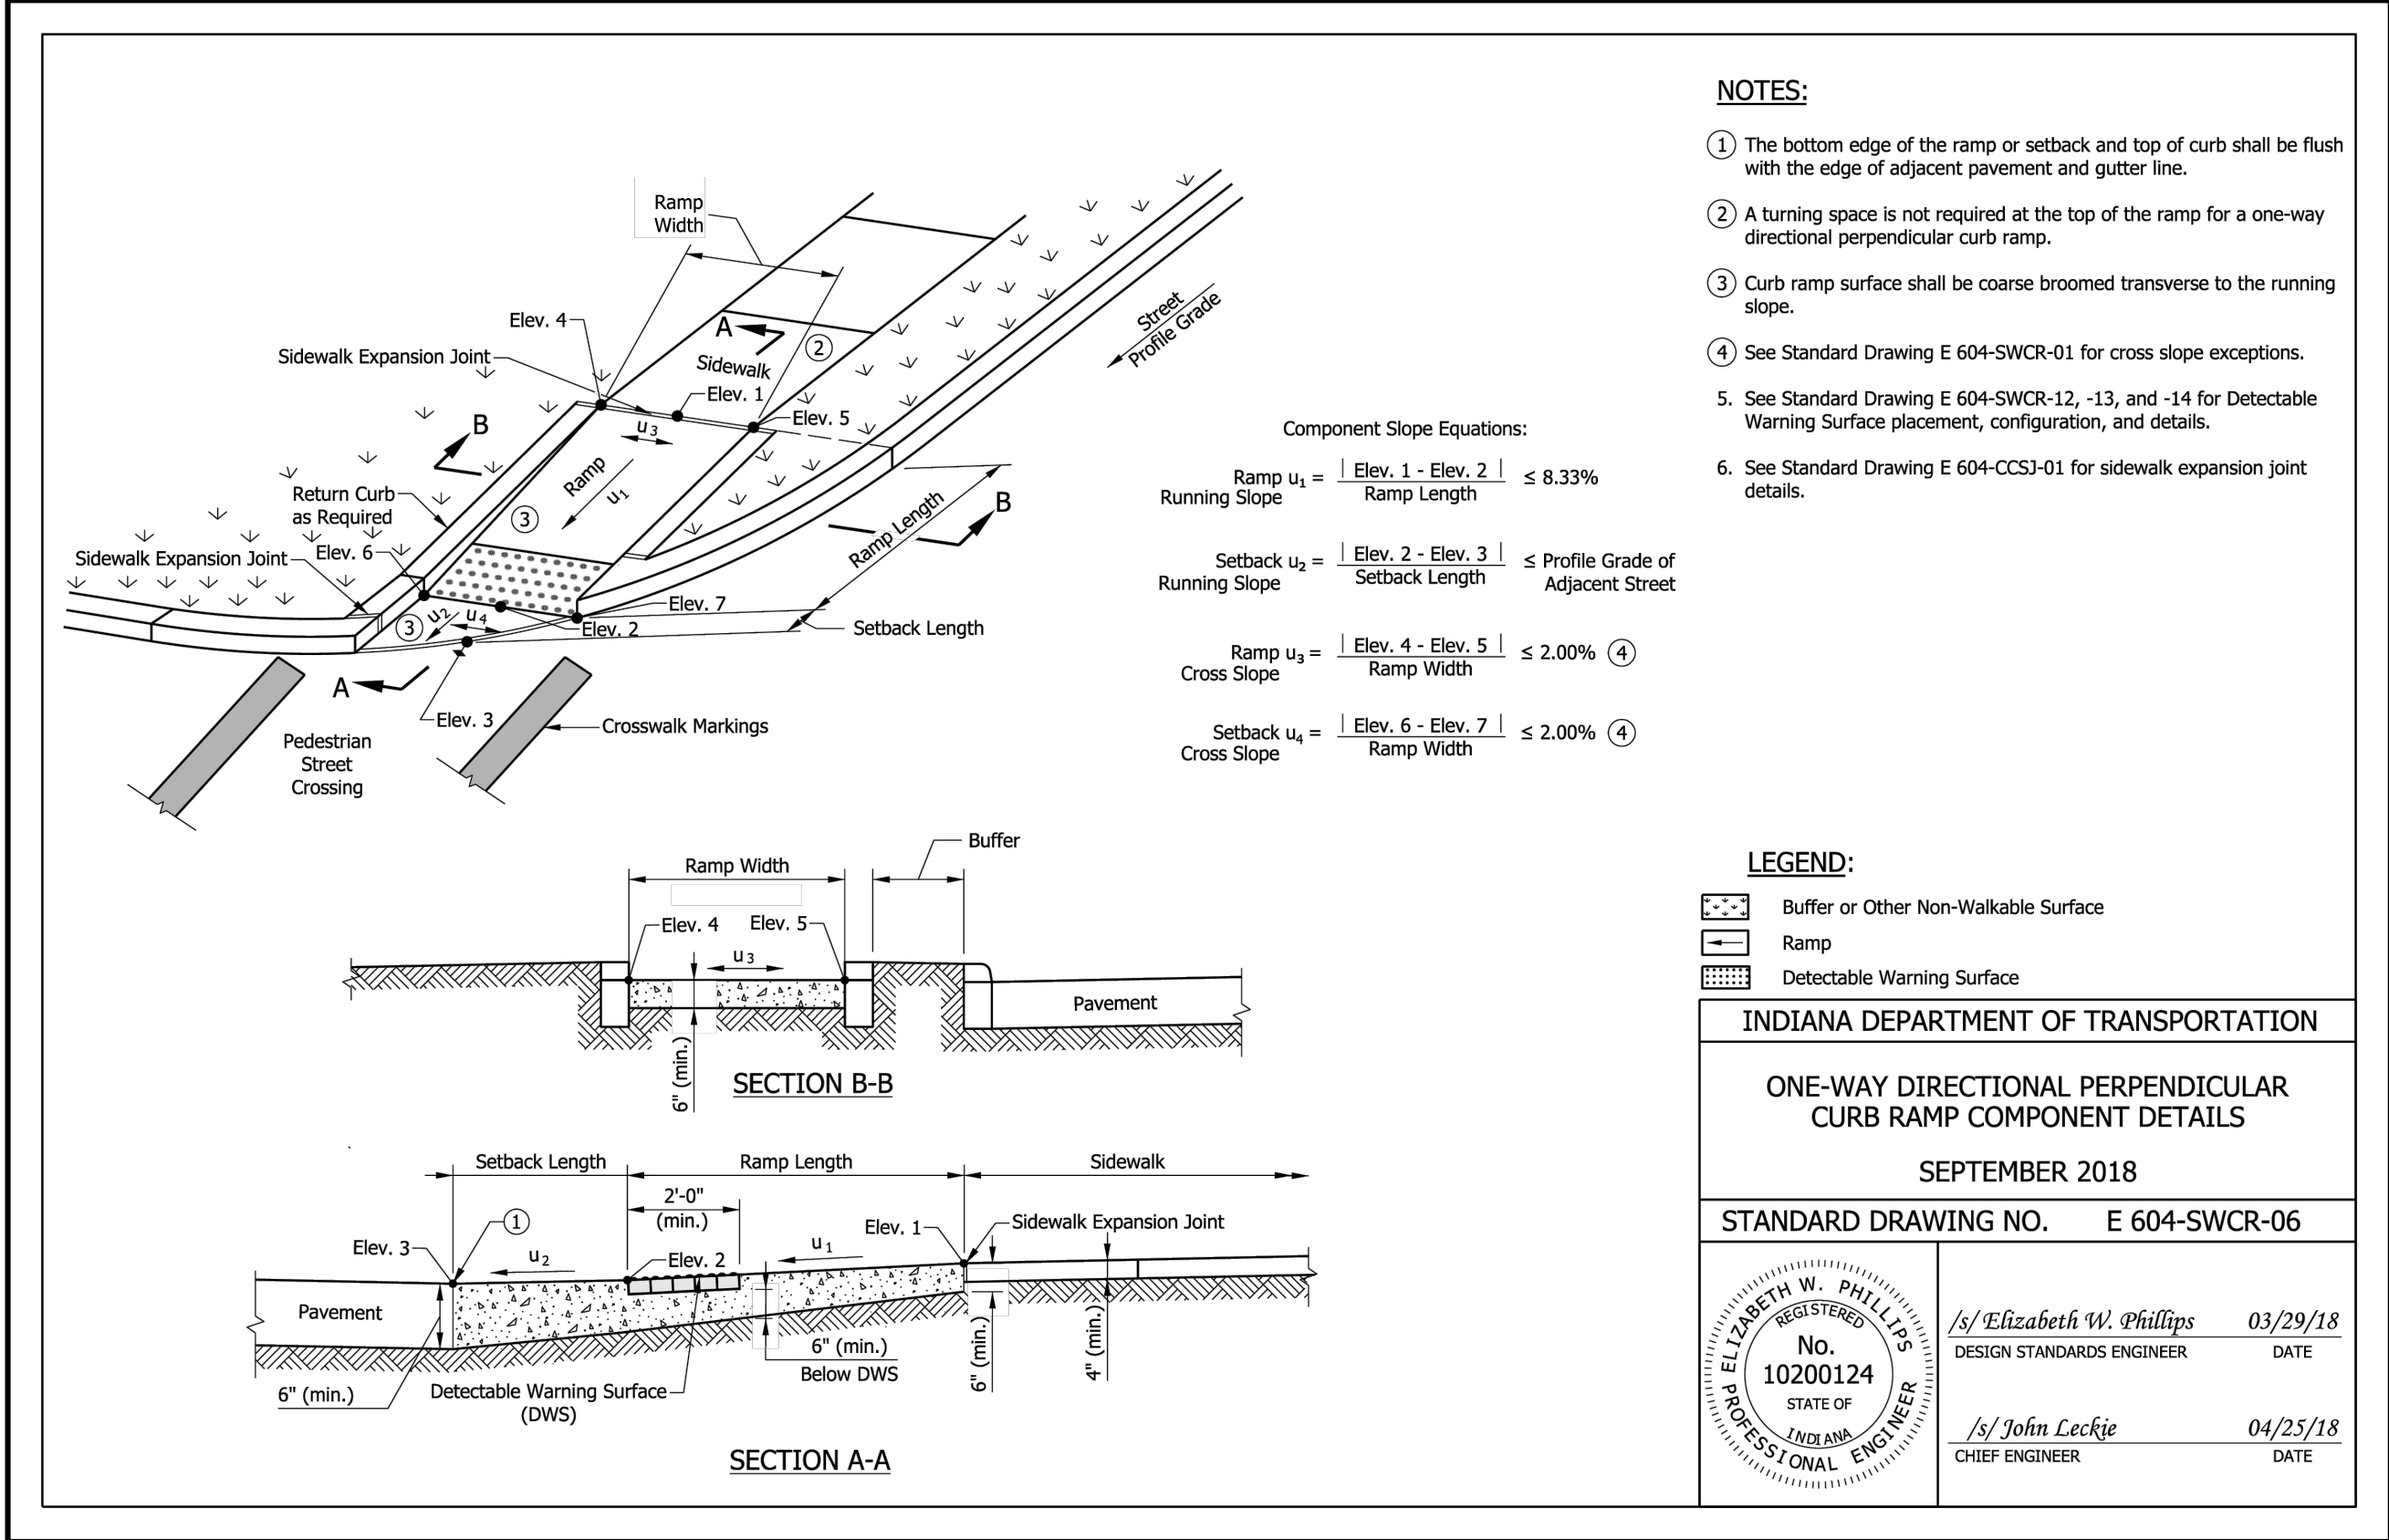

REVISIONS	
DATE	ITEM
Oct 2, 2025	Updated Str. 11A, Added detail notes to box culvert and casting

A&F ENGINEERING
Transportation & Site Engineering
Creating Order Since 1966
8365 Keystone Crossing, Suite 201, Indianapolis, IN. 46240 (317) 202-0864

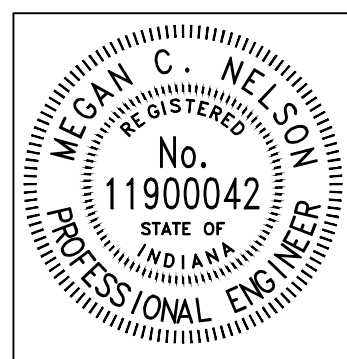


RECOMMENDED FOR APPROVAL	DESIGN ENGINEER	DATE
Megan C. Nelson		08/11/2025
DESIGNED: MCN	DRAWN: MCN	
CHECKED: JAH	CHECKED: JAH	

WESTFIELD WASHINGTON SCHOOLS
MISCELLANEOUS DETAILS


HORIZONTAL SCALE N/A	BRIDGE FILE N/A
VERTICAL SCALE N/A	DESIGNATION --
SHEETS	
24	of 48
CONTRACT	
--	

[illegible][illegible]

Z:\2024\240787-CONTEXT DESIGN TRAFFIC SIGNAL, SR 32-CENTENNIAL RD PH 1\DWG\CENTENNIAL PLAN SET\240787-CORRIDOR CENTENNIAL.DWG

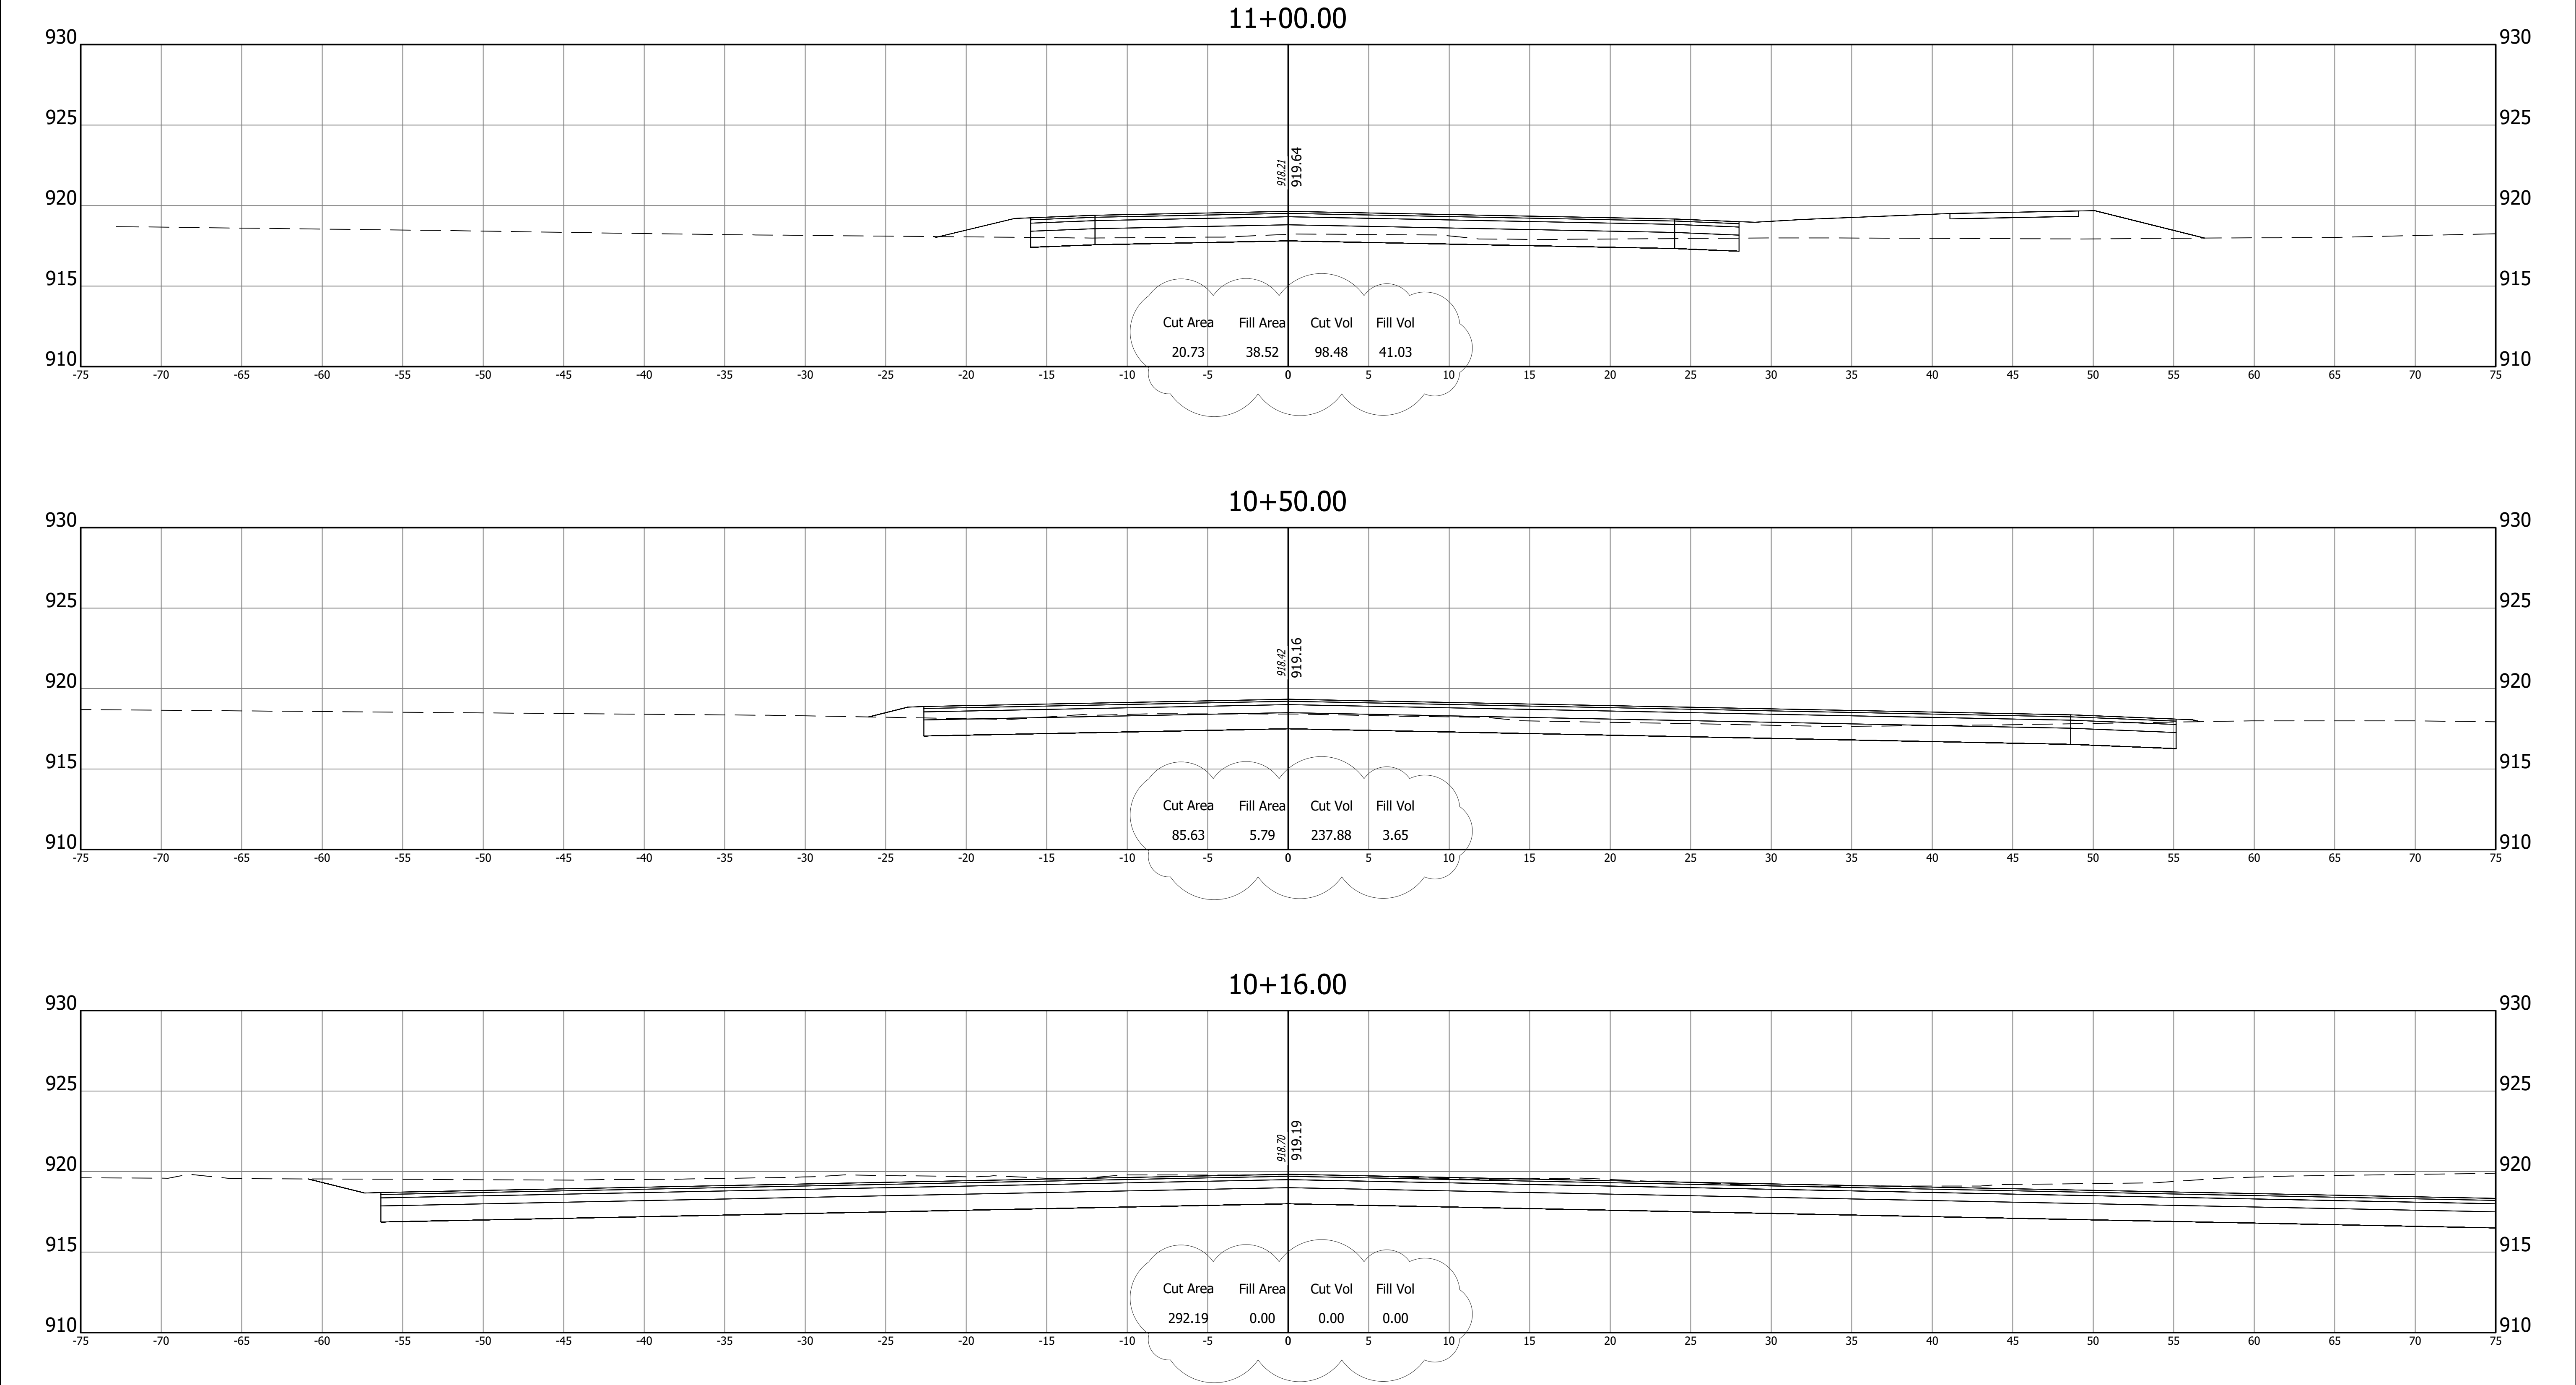

REVISIONS	
DATE	ITEM
Oct 2, 2025	Updated Earthwork

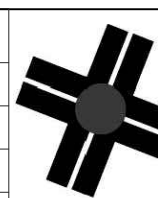


A&F ENGINEERING

Transportation & Site Engineering

Creating Order Since 1966

8365 Keystone Crossing, Suite 201, Indianapolis, IN. 46240 (317) 202-0864

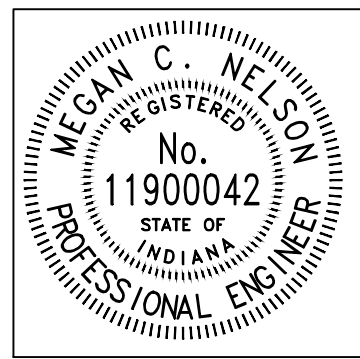


RECOMMENDED FOR APPROVAL		08/11/2025	
		DATE	
DESIGNED:	MCN	DRAWN:	AJG
CHECKED:	JAH	CHECKED:	JAH

WESTFIELD
WASHINGTON SCHOOLS


CROSS SECTIONS
LINE "PR-B"

HORIZONTAL SCALE 1"=5'	BRIDGE FILE N/A
VERTICAL SCALE 1"=5'	DESIGNATION --
SHEETS	
27	of 48
CONTRACT	
--	

Z:\2024\240787-CONTEXT DESIGN-TRAFFIC SIGNAL, SR 32-CENTENNIAL RD PH5 1.DWG\CENTENNIAL PLAN SET\240787-CORRIDOR CENTENNIAL.DWG

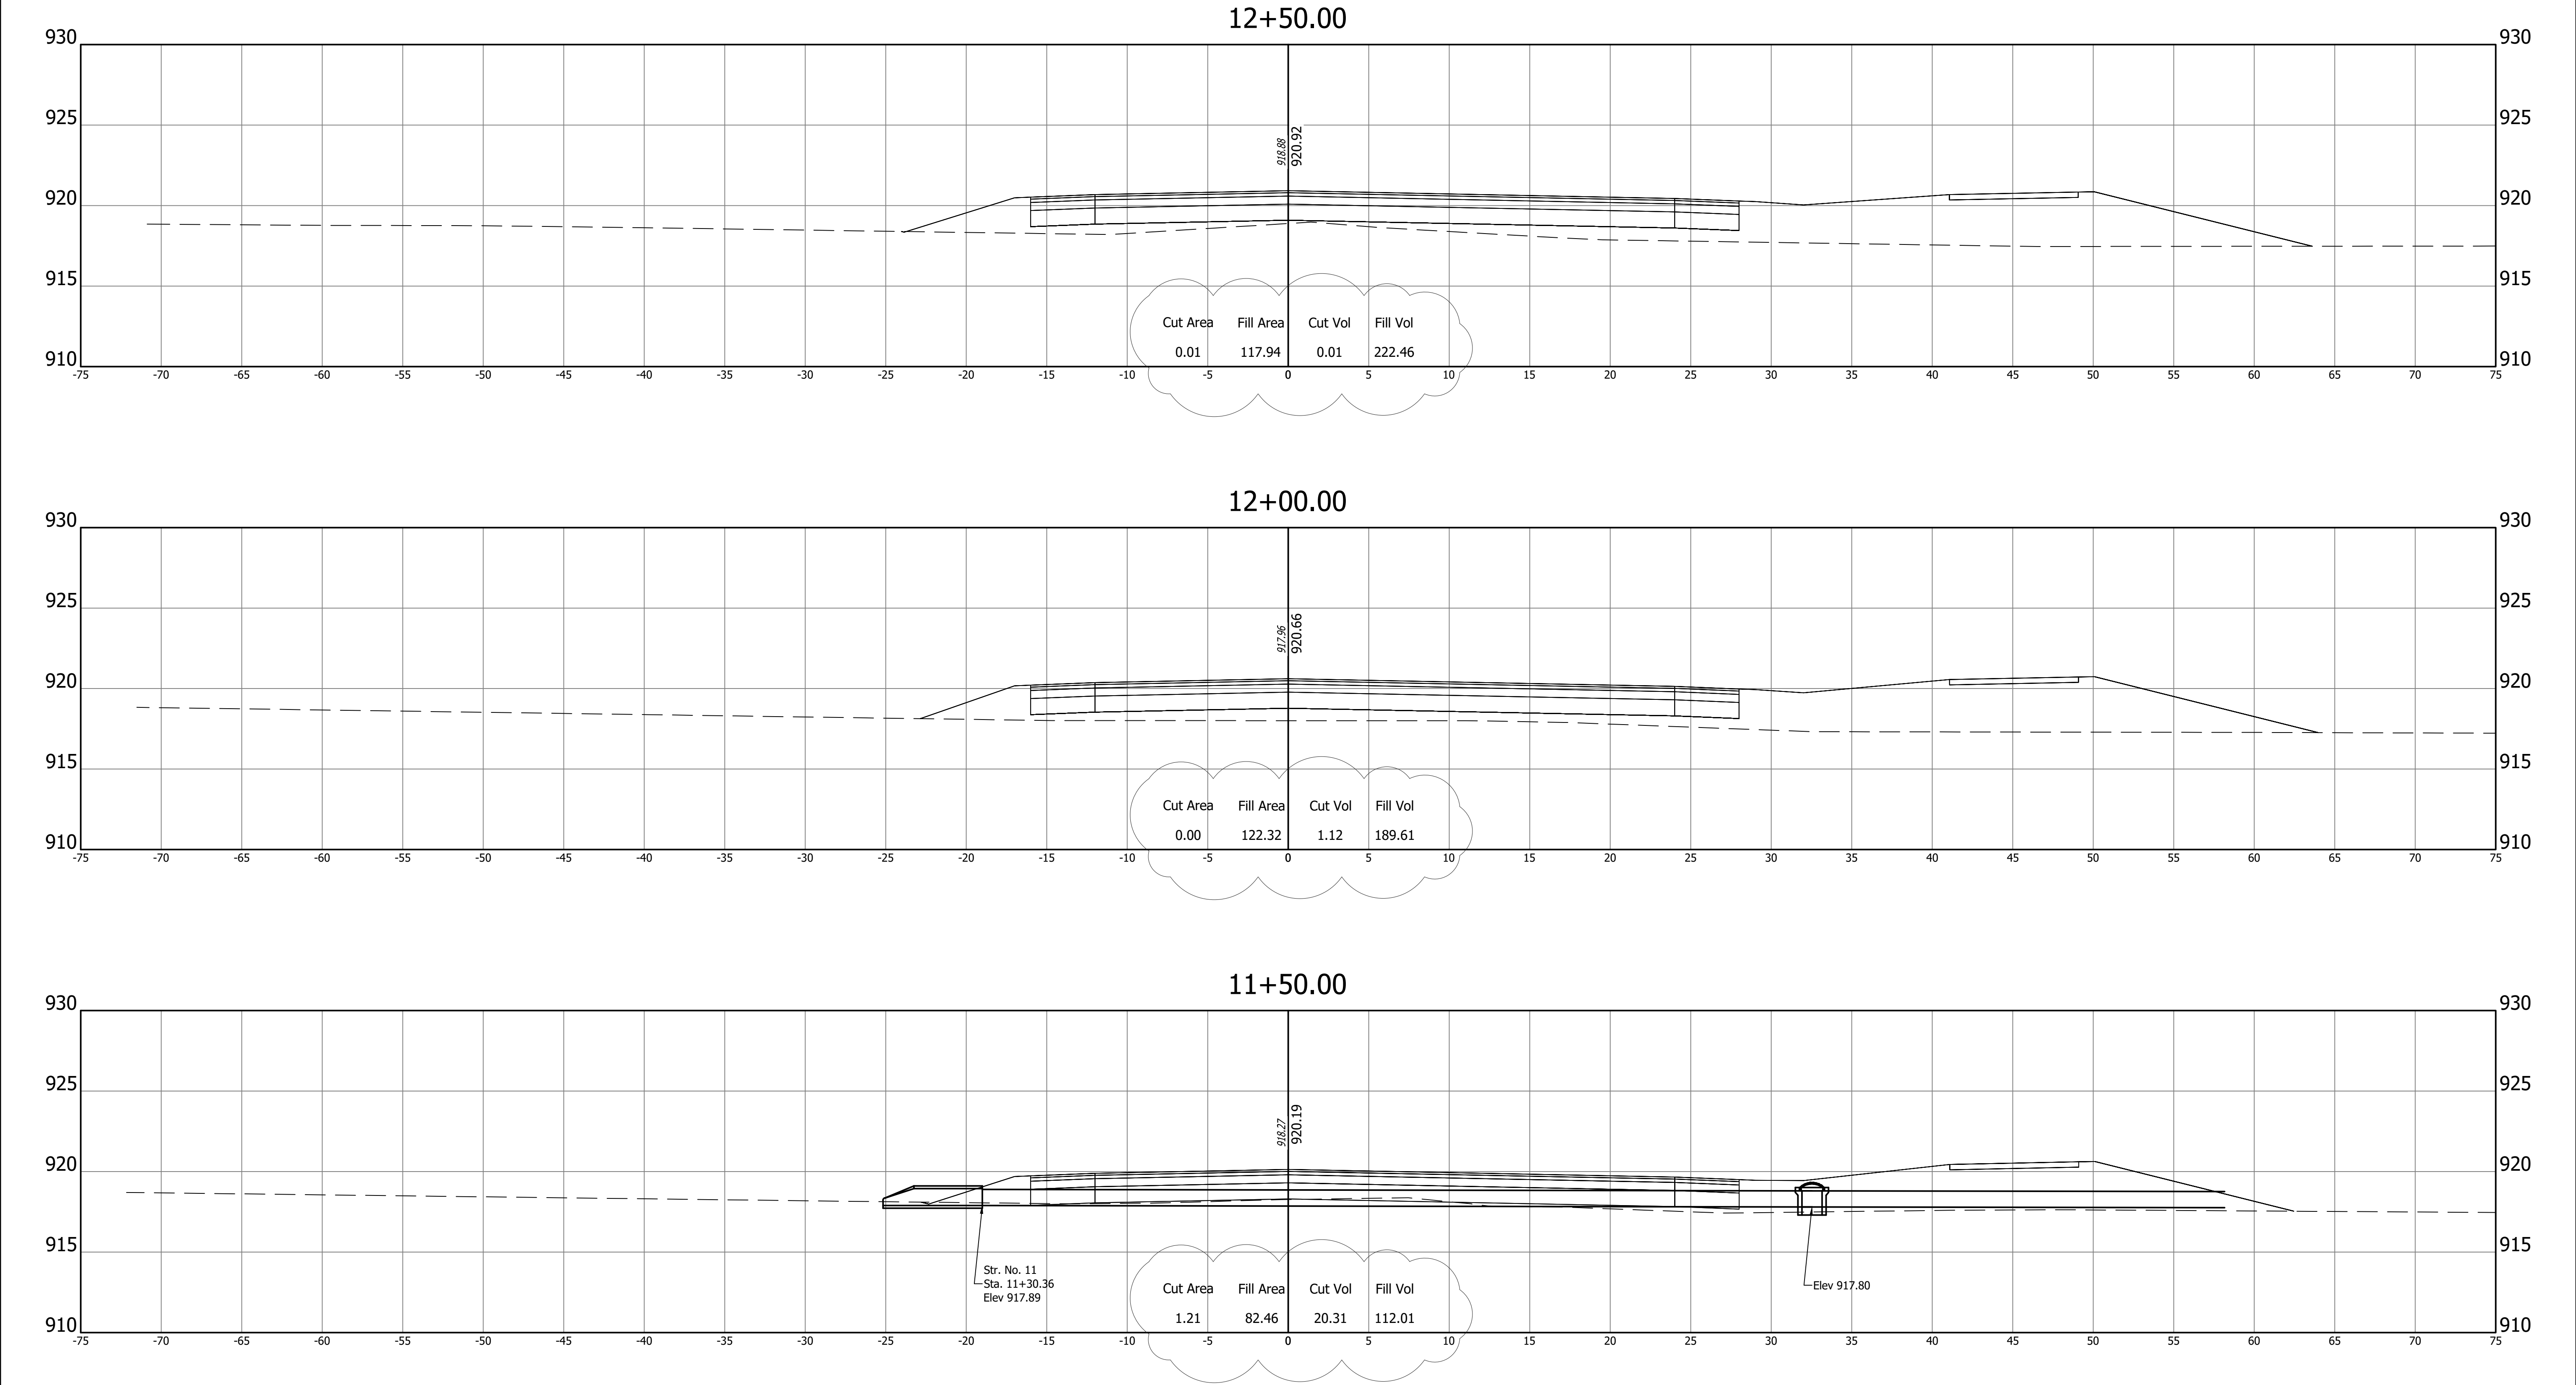

REVISIONS	
DATE	ITEM
Oct 2, 2025	Updated Earthwork

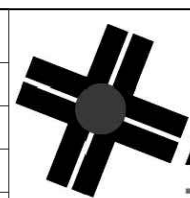


A&F ENGINEERING

Transportation & Site Engineering

Creating Order Since 1966

8365 Keystone Crossing, Suite 201, Indianapolis, IN. 46240 (317) 202-0864

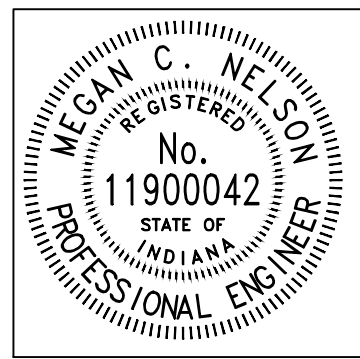


RECOMMENDED FOR APPROVAL		08/11/2025	
DESIGNED: MCN		DRAWN: AJG	
CHECKED: JAH		CHECKED: JAH	

WESTFIELD
WASHINGTON SCHOOLS


CROSS SECTIONS
LINE "PR-B"

HORIZONTAL SCALE 1"=5'	BRIDGE FILE N/A
VERTICAL SCALE 1"=5'	DESIGNATION --
SHEETS	
28 of 48	
CONTRACT	
--	


Z:\2024\240787-CONTEXT DESIGN TRAFFIC SIGNAL, SR 32-CENTENNIAL RD PH5 1.DWG\CENTENNIAL PLAN SET\240787-CORRIDOR CENTENNIAL.DWG

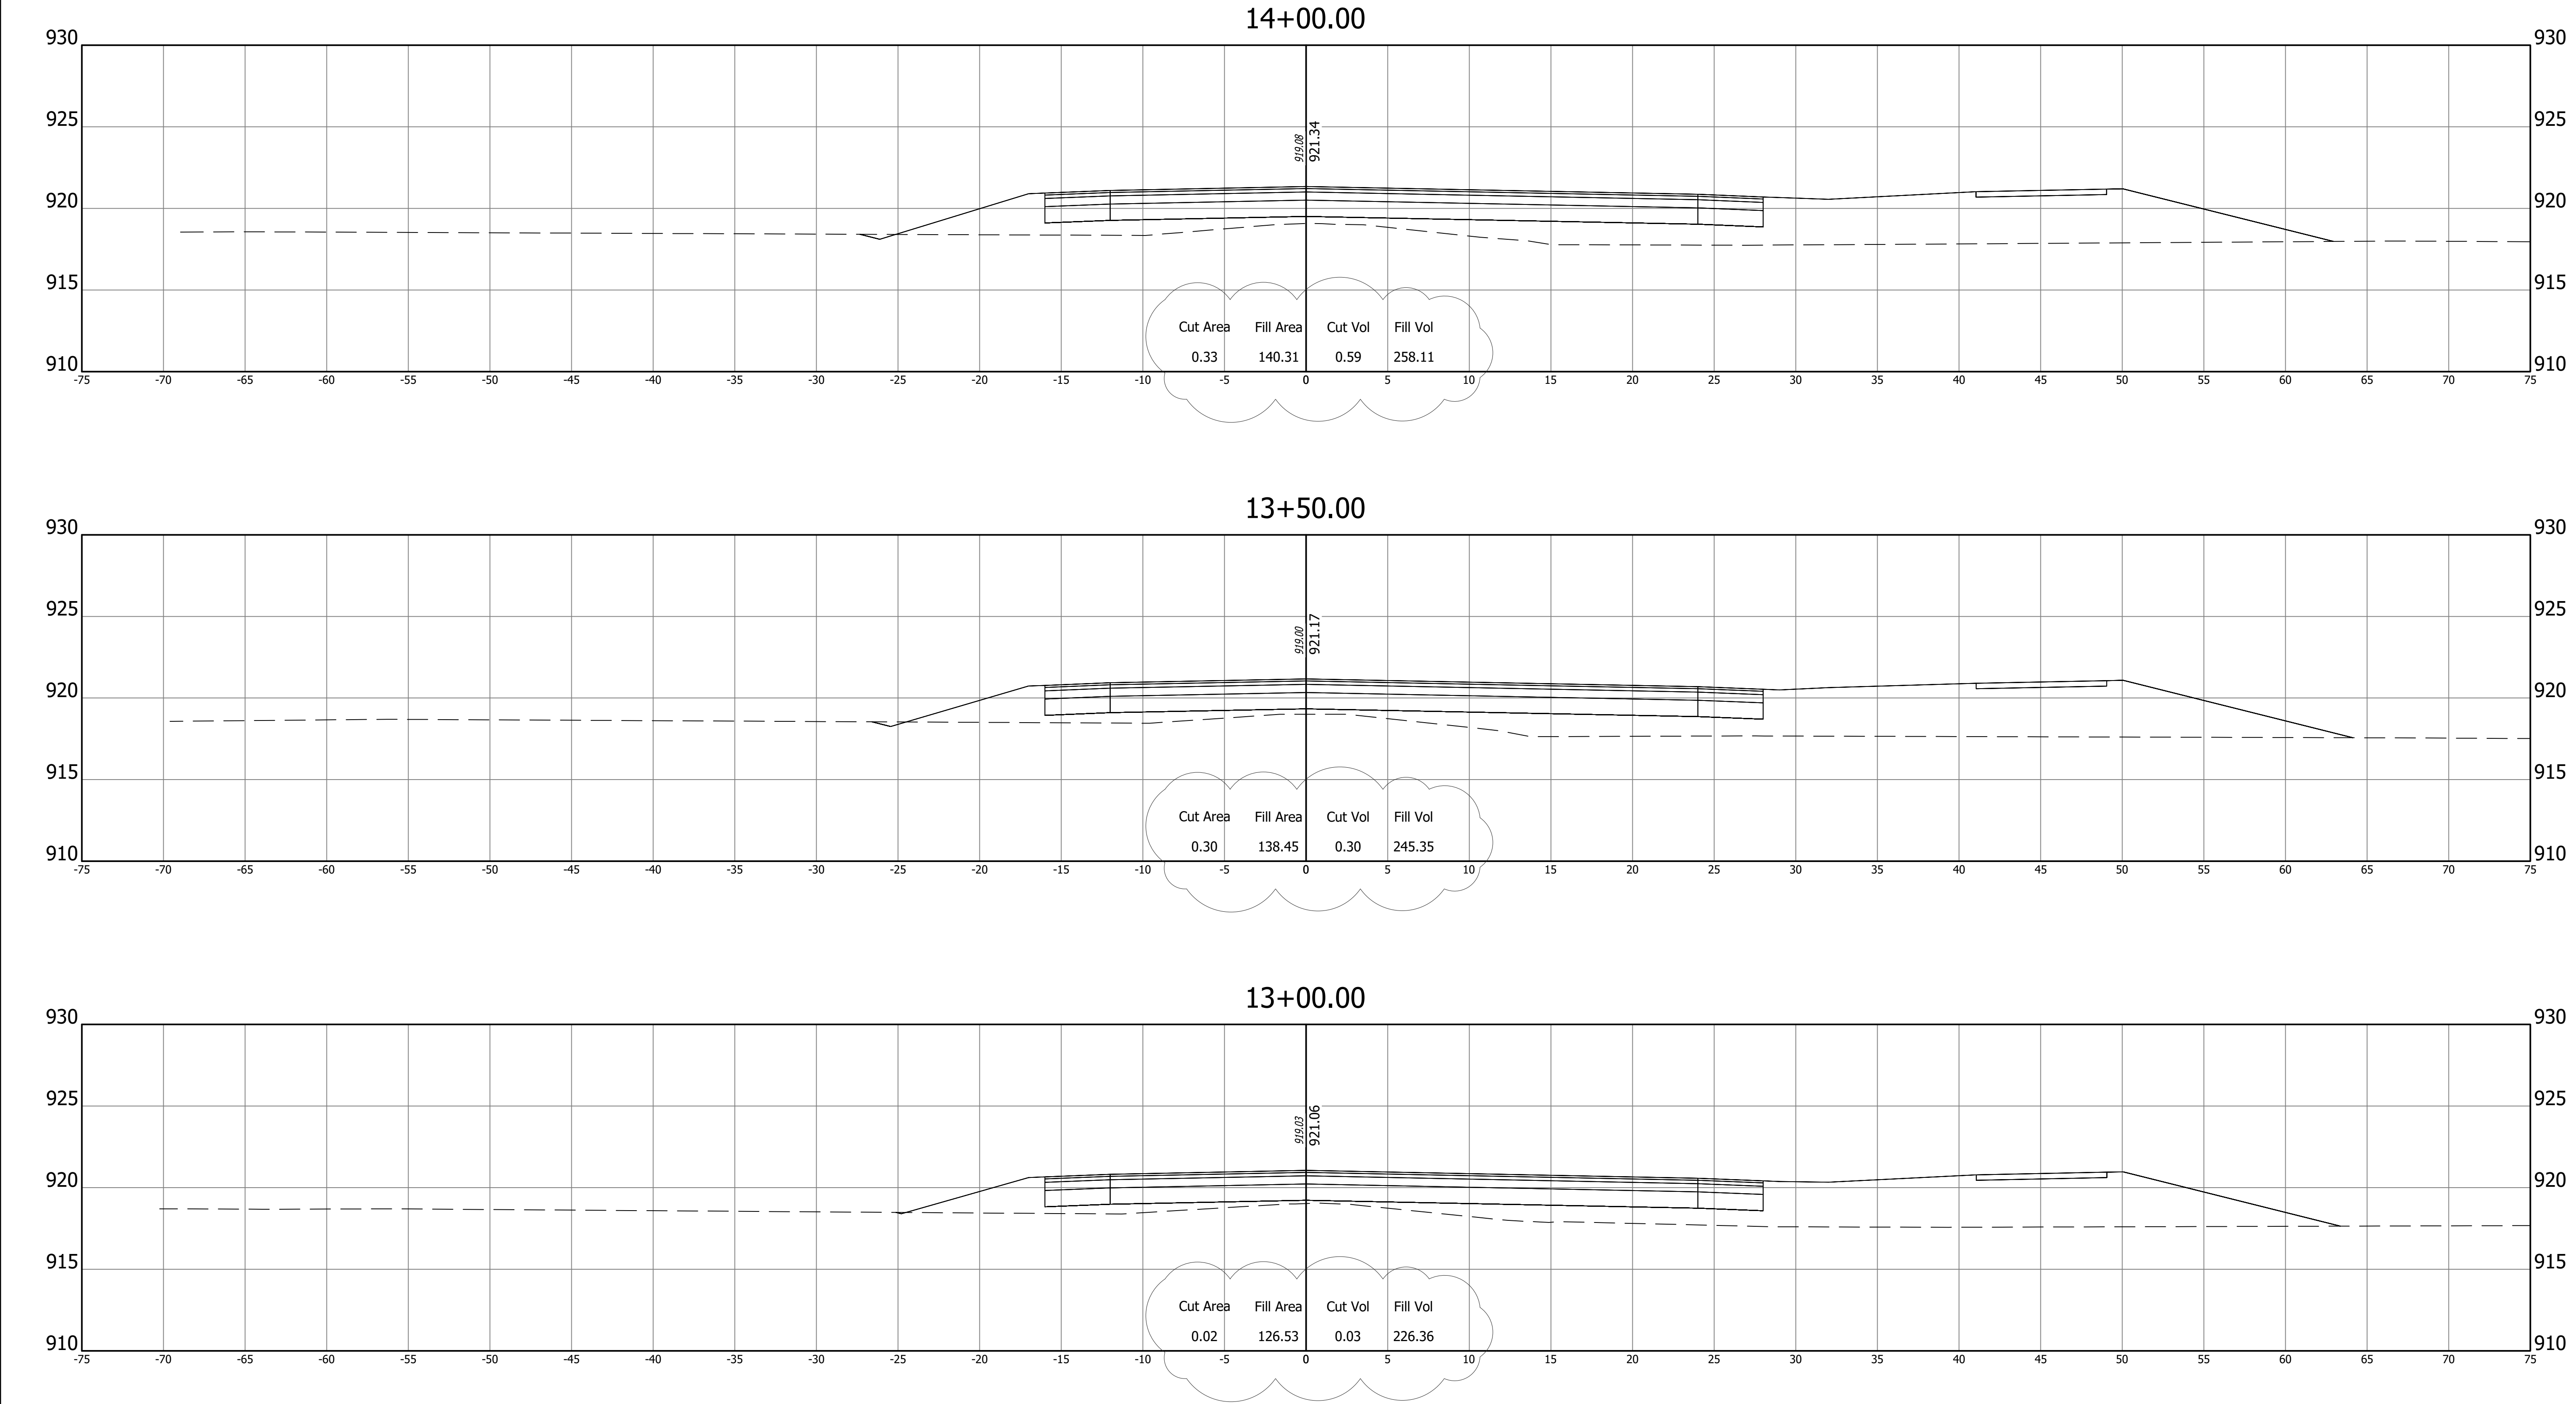

REVISIONS	
DATE	ITEM
Oct 2, 2025	Updated Earthwork

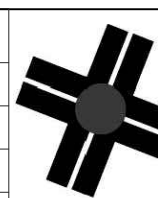

A&F ENGINEERING
Transportation & Site Engineering
Creating Order Since 1966
8365 Keystone Crossing, Suite 201, Indianapolis, IN. 46240 (317) 202-0864

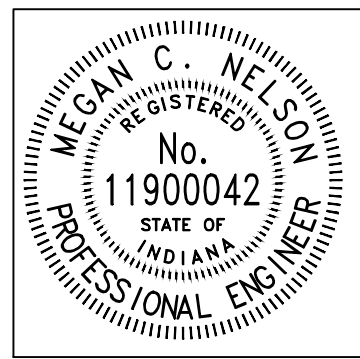


RECOMMENDED FOR APPROVAL		08/11/2025	
		DATE	
DESIGNED:	MCN	DRAWN:	AJG
CHECKED:	JAH	CHECKED:	JAH

WESTFIELD
WASHINGTON SCHOOLS


CROSS SECTIONS
LINE "PR-B"

HORIZONTAL SCALE 1"=5'	BRIDGE FILE N/A
VERTICAL SCALE 1"=5'	DESIGNATION --
SHEETS	
29	of 48
CONTRACT	
--	

Z:\2024\240787-CONTEXT DESIGN TRAFFIC SIGNAL, SR 32-CENTENNIAL RD PH5 1DWG\CENTENNIAL PLAN SET\240787-CORRIDOR CENTENNIAL.DWG

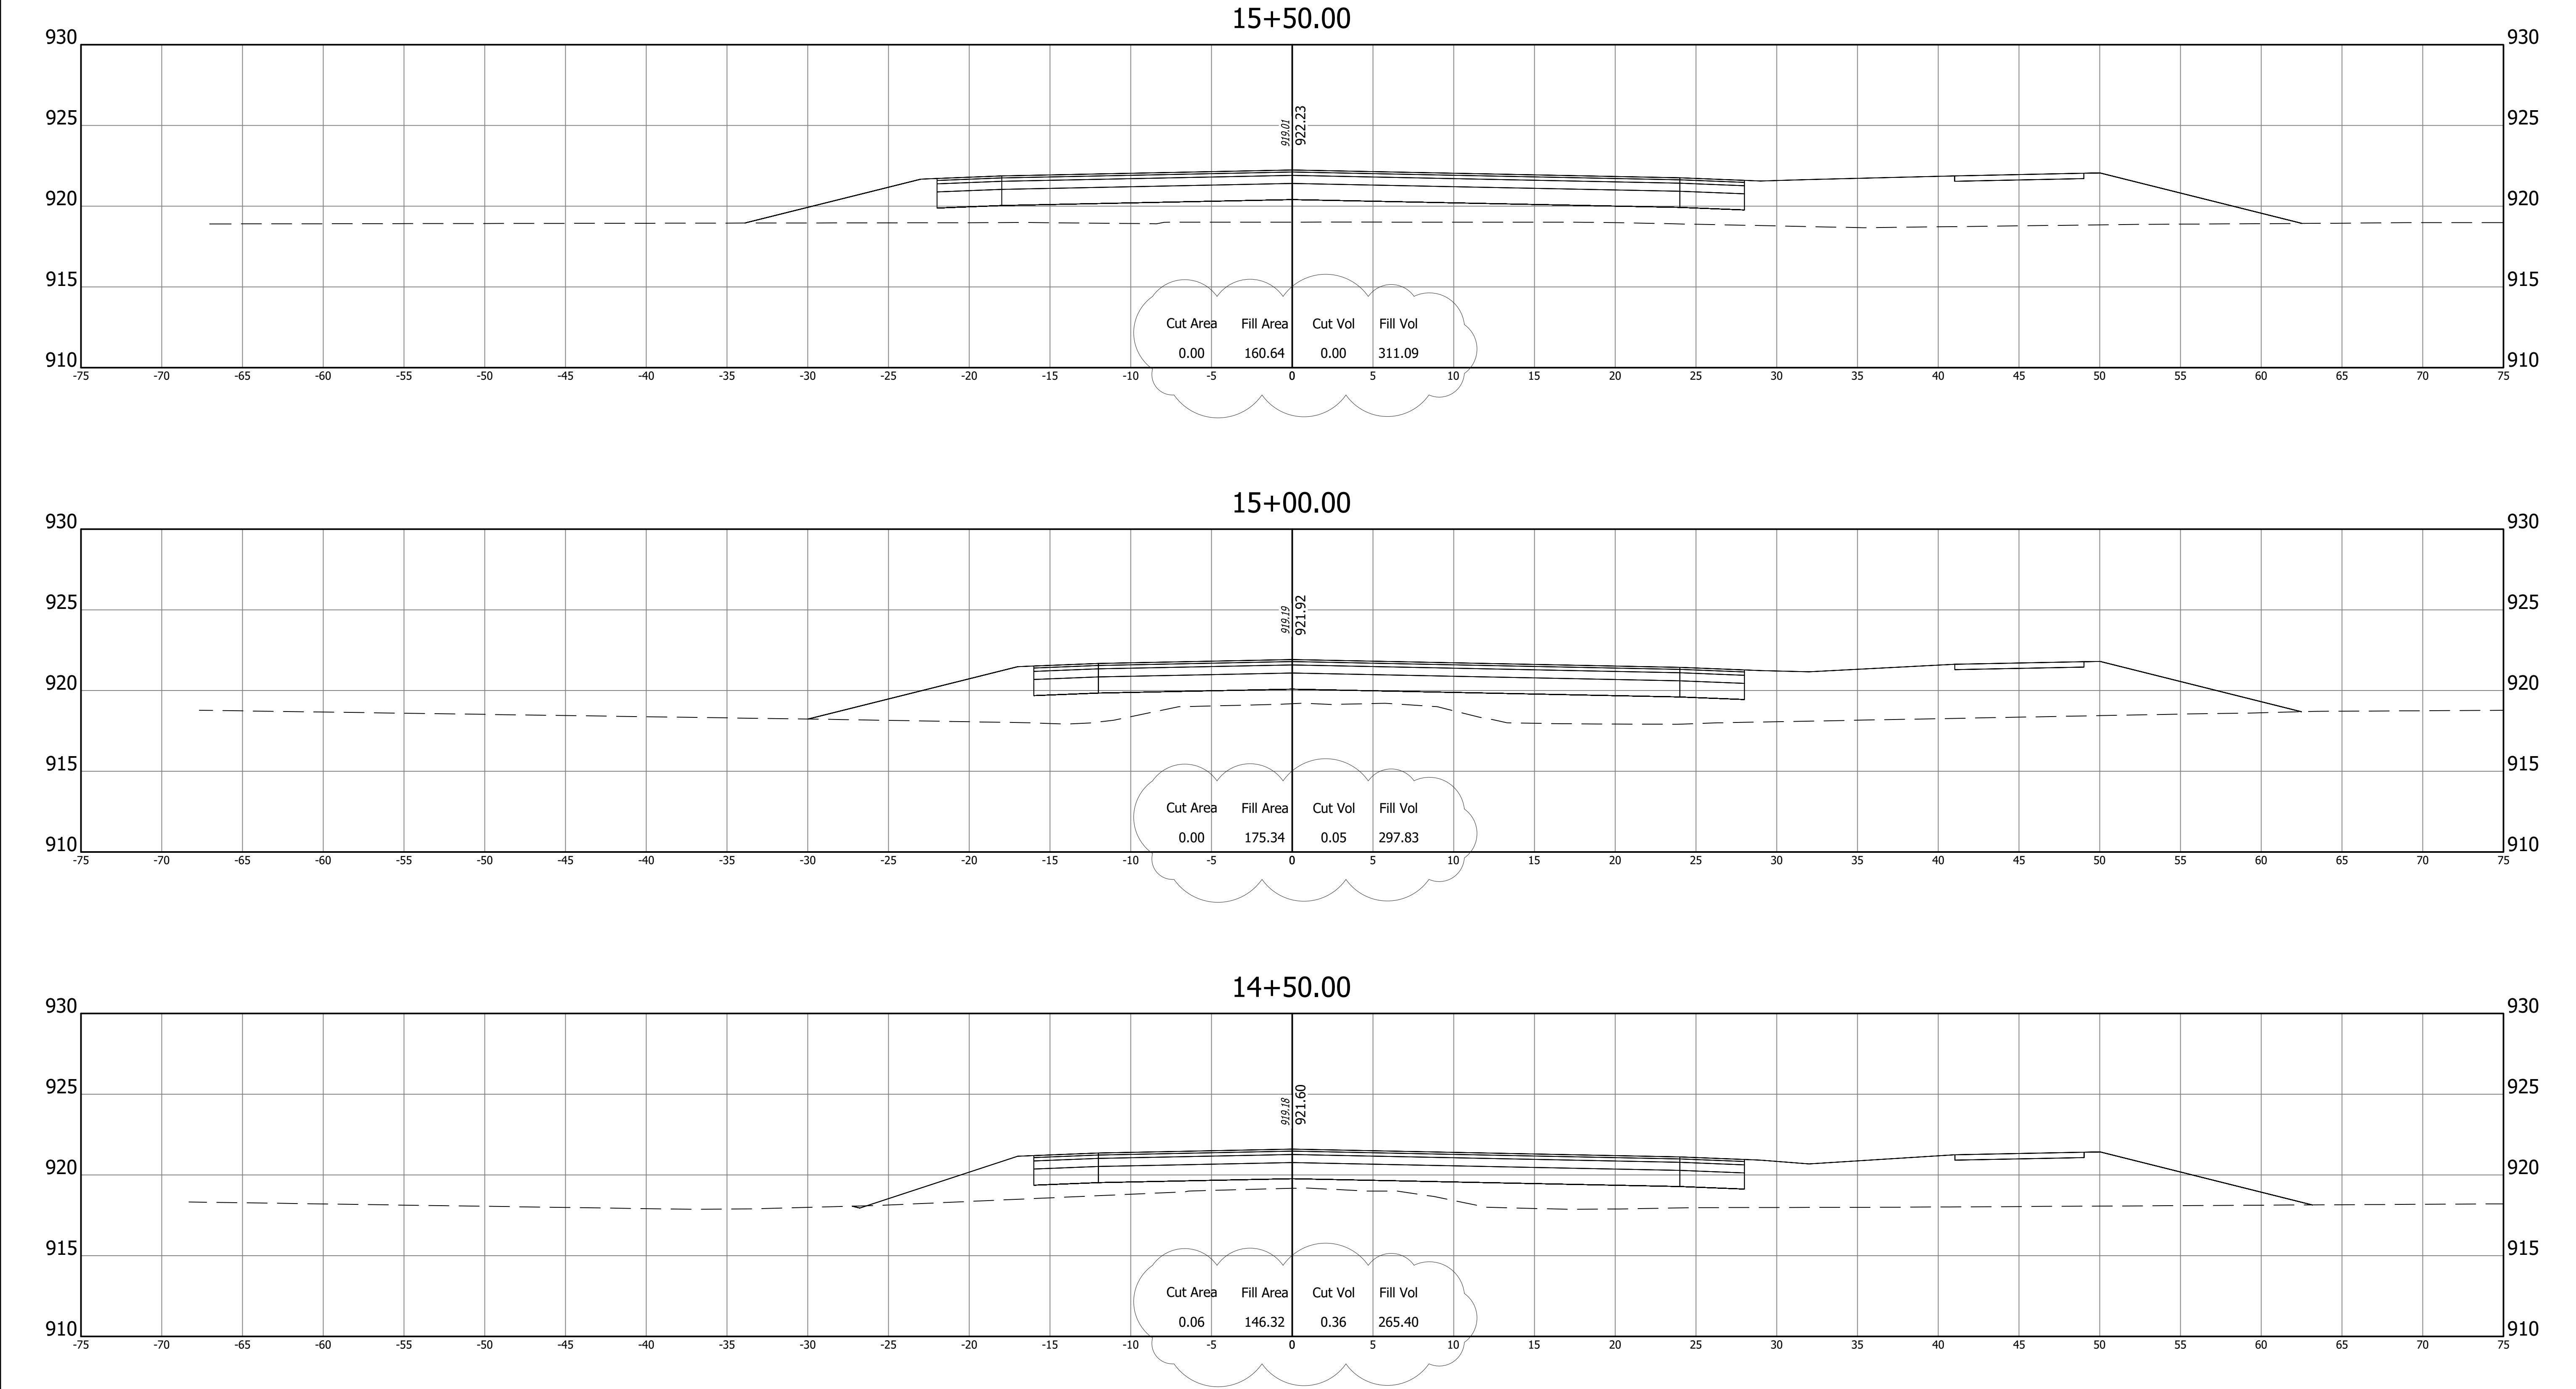

REVISIONS	
DATE	ITEM
Oct 2, 2025	Updated Earthwork

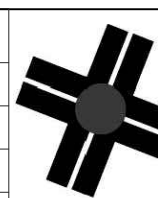


A&F ENGINEERING

Transportation & Site Engineering

Creating Order Since 1966

8365 Keystone Crossing, Suite 201, Indianapolis, IN. 46240 (317) 202-0864

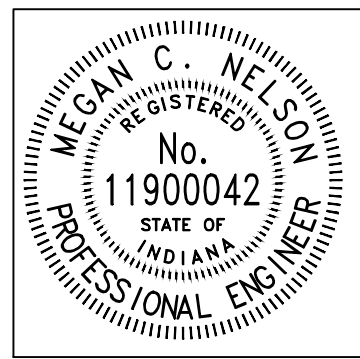




RECOMMENDED FOR APPROVAL		08/11/2025	
		DATE	
DESIGNED:	MCN	DRAWN:	AJG
CHECKED:	JAH	CHECKED:	JAH

WESTFIELD
WASHINGTON SCHOOLS


CROSS SECTIONS
LINE "PR-B"

HORIZONTAL SCALE 1"=5'	BRIDGE FILE N/A
VERTICAL SCALE 1"=5'	DESIGNATION --
SHEETS	
30	of 48
CONTRACT	
--	

Z:\2024\240787-CONTEXT DESIGN\TRAFFIC SIGNAL, SR 32-CENTENNIAL RD PH5 1.DWG\CENTENNIAL PLAN SET\240787-CORRIDOR CENTENNIAL.DWG

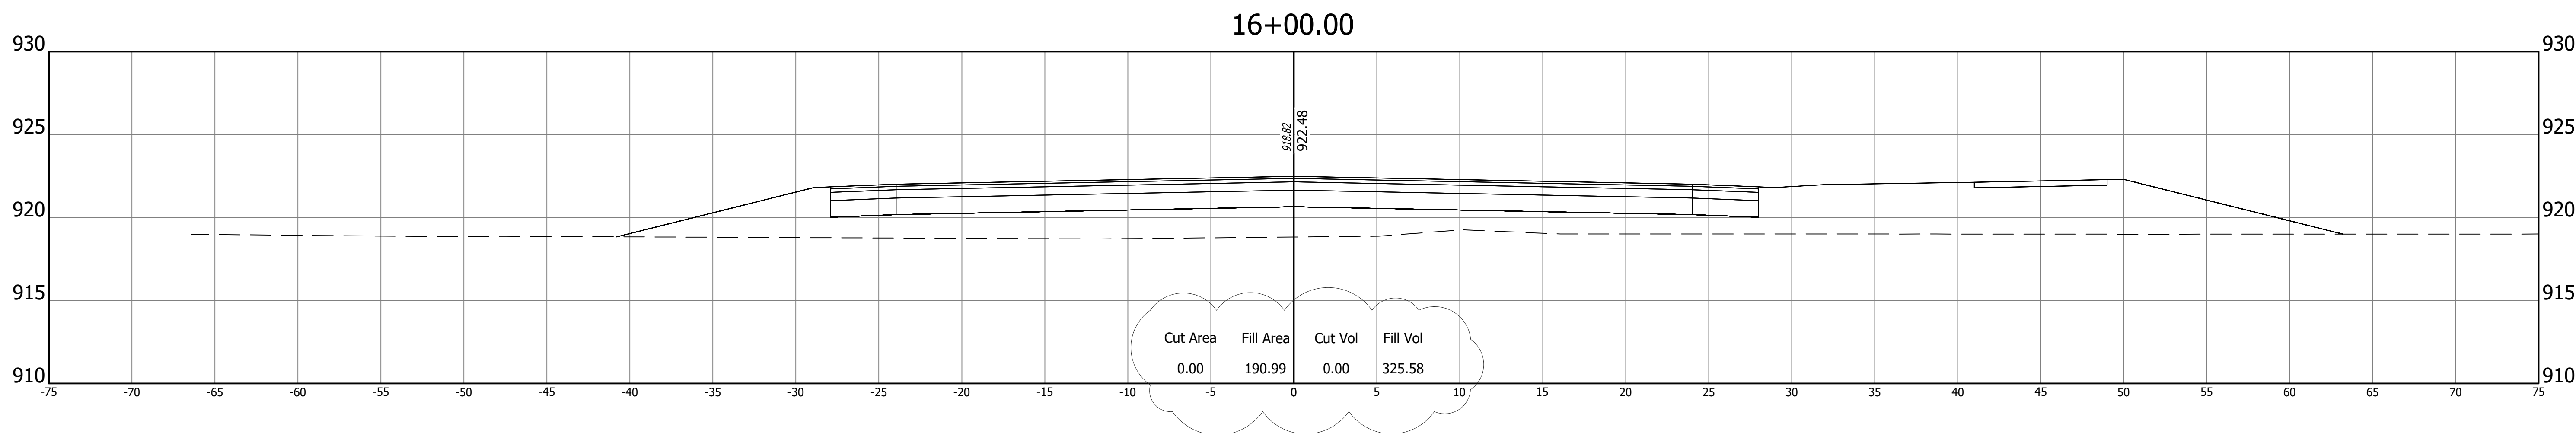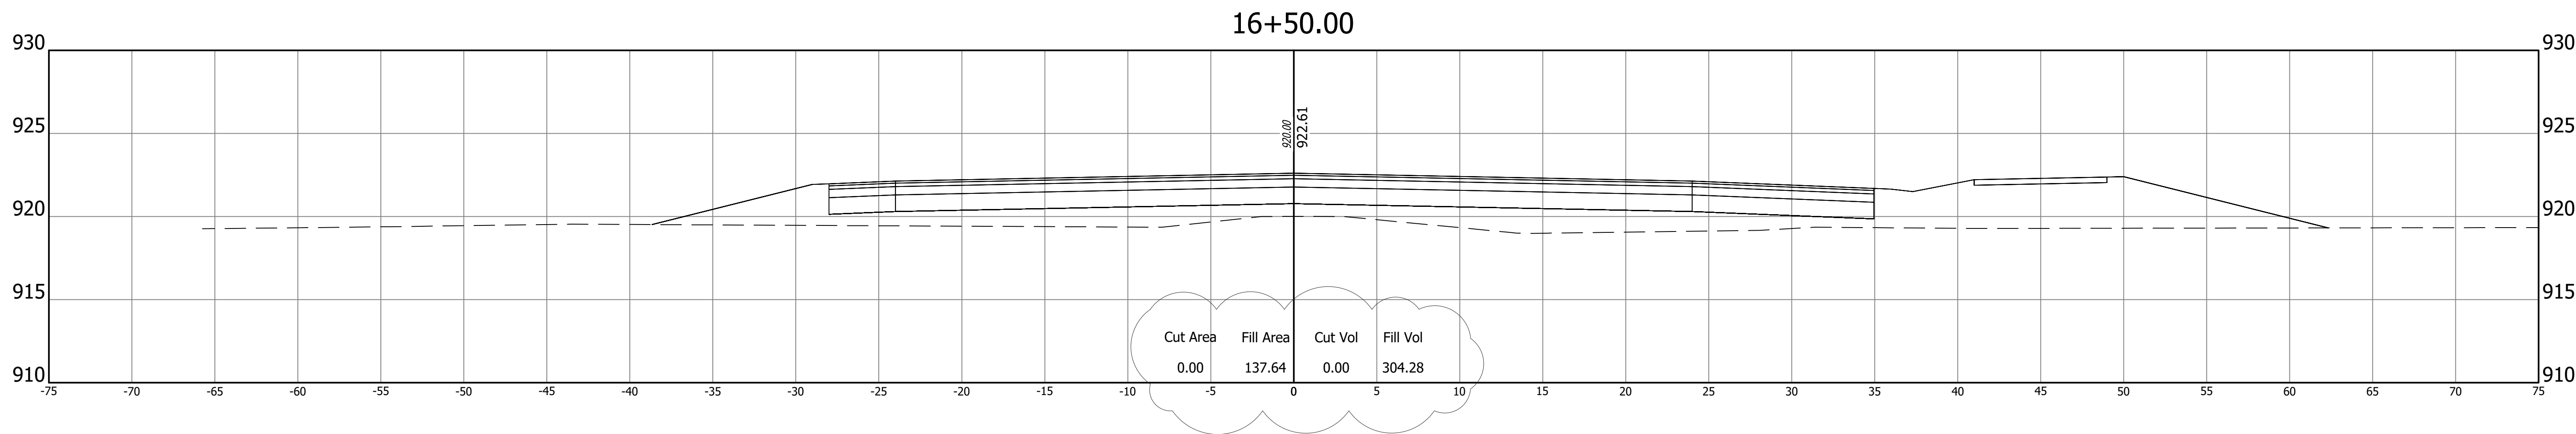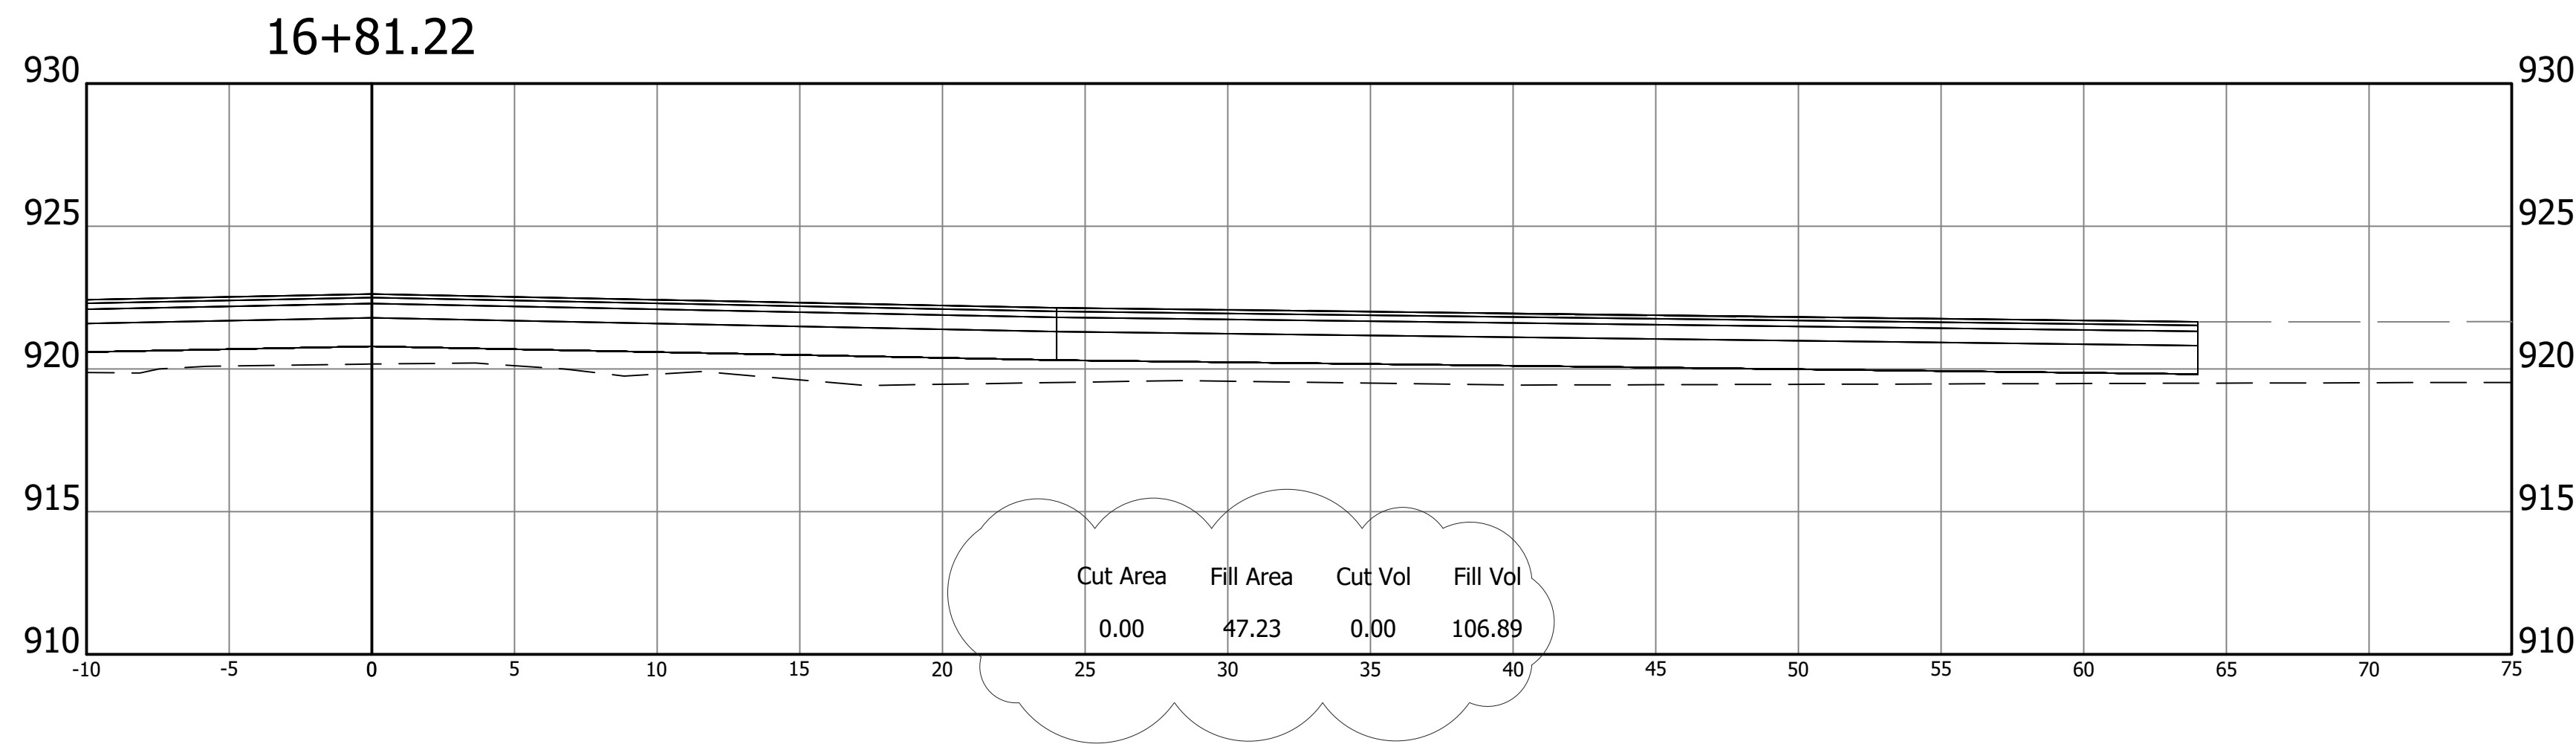

REVISIONS	
DATE	ITEM
Oct 2, 2025	Updated Earthwork

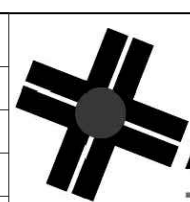


A&F ENGINEERING

Transportation & Site Engineering

Creating Order Since 1966

8365 Keystone Crossing, Suite 201, Indianapolis, IN. 46240 (317) 202-0864

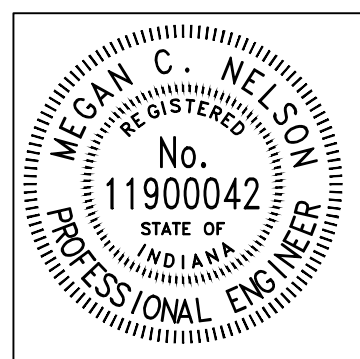


RECOMMENDED FOR APPROVAL		08/11/2025	
		DATE	
DESIGNED:	MCN	DRAWN:	AJG
CHECKED:	JAH	CHECKED:	JAH


WESTFIELD WASHINGTON SCHOOLS	
CROSS SECTIONS LINE "PR-B"	

HORIZONTAL SCALE	BRIDGE FILE		
1"=5'	N/A		
VERTICAL SCALE	DESIGNATION		
1"=5'	--		
SHEETS			
31 of 48			
CONTRACT			
--			

Z:\2024\240787-CONTEXT DESIGN-TRAFFIC SIGNAL, SR 32-CENTENNIAL RD PH5 1DWG\CENTENNIAL PLAN SET\240787-CORRIDOR CENTENNIAL.DWG

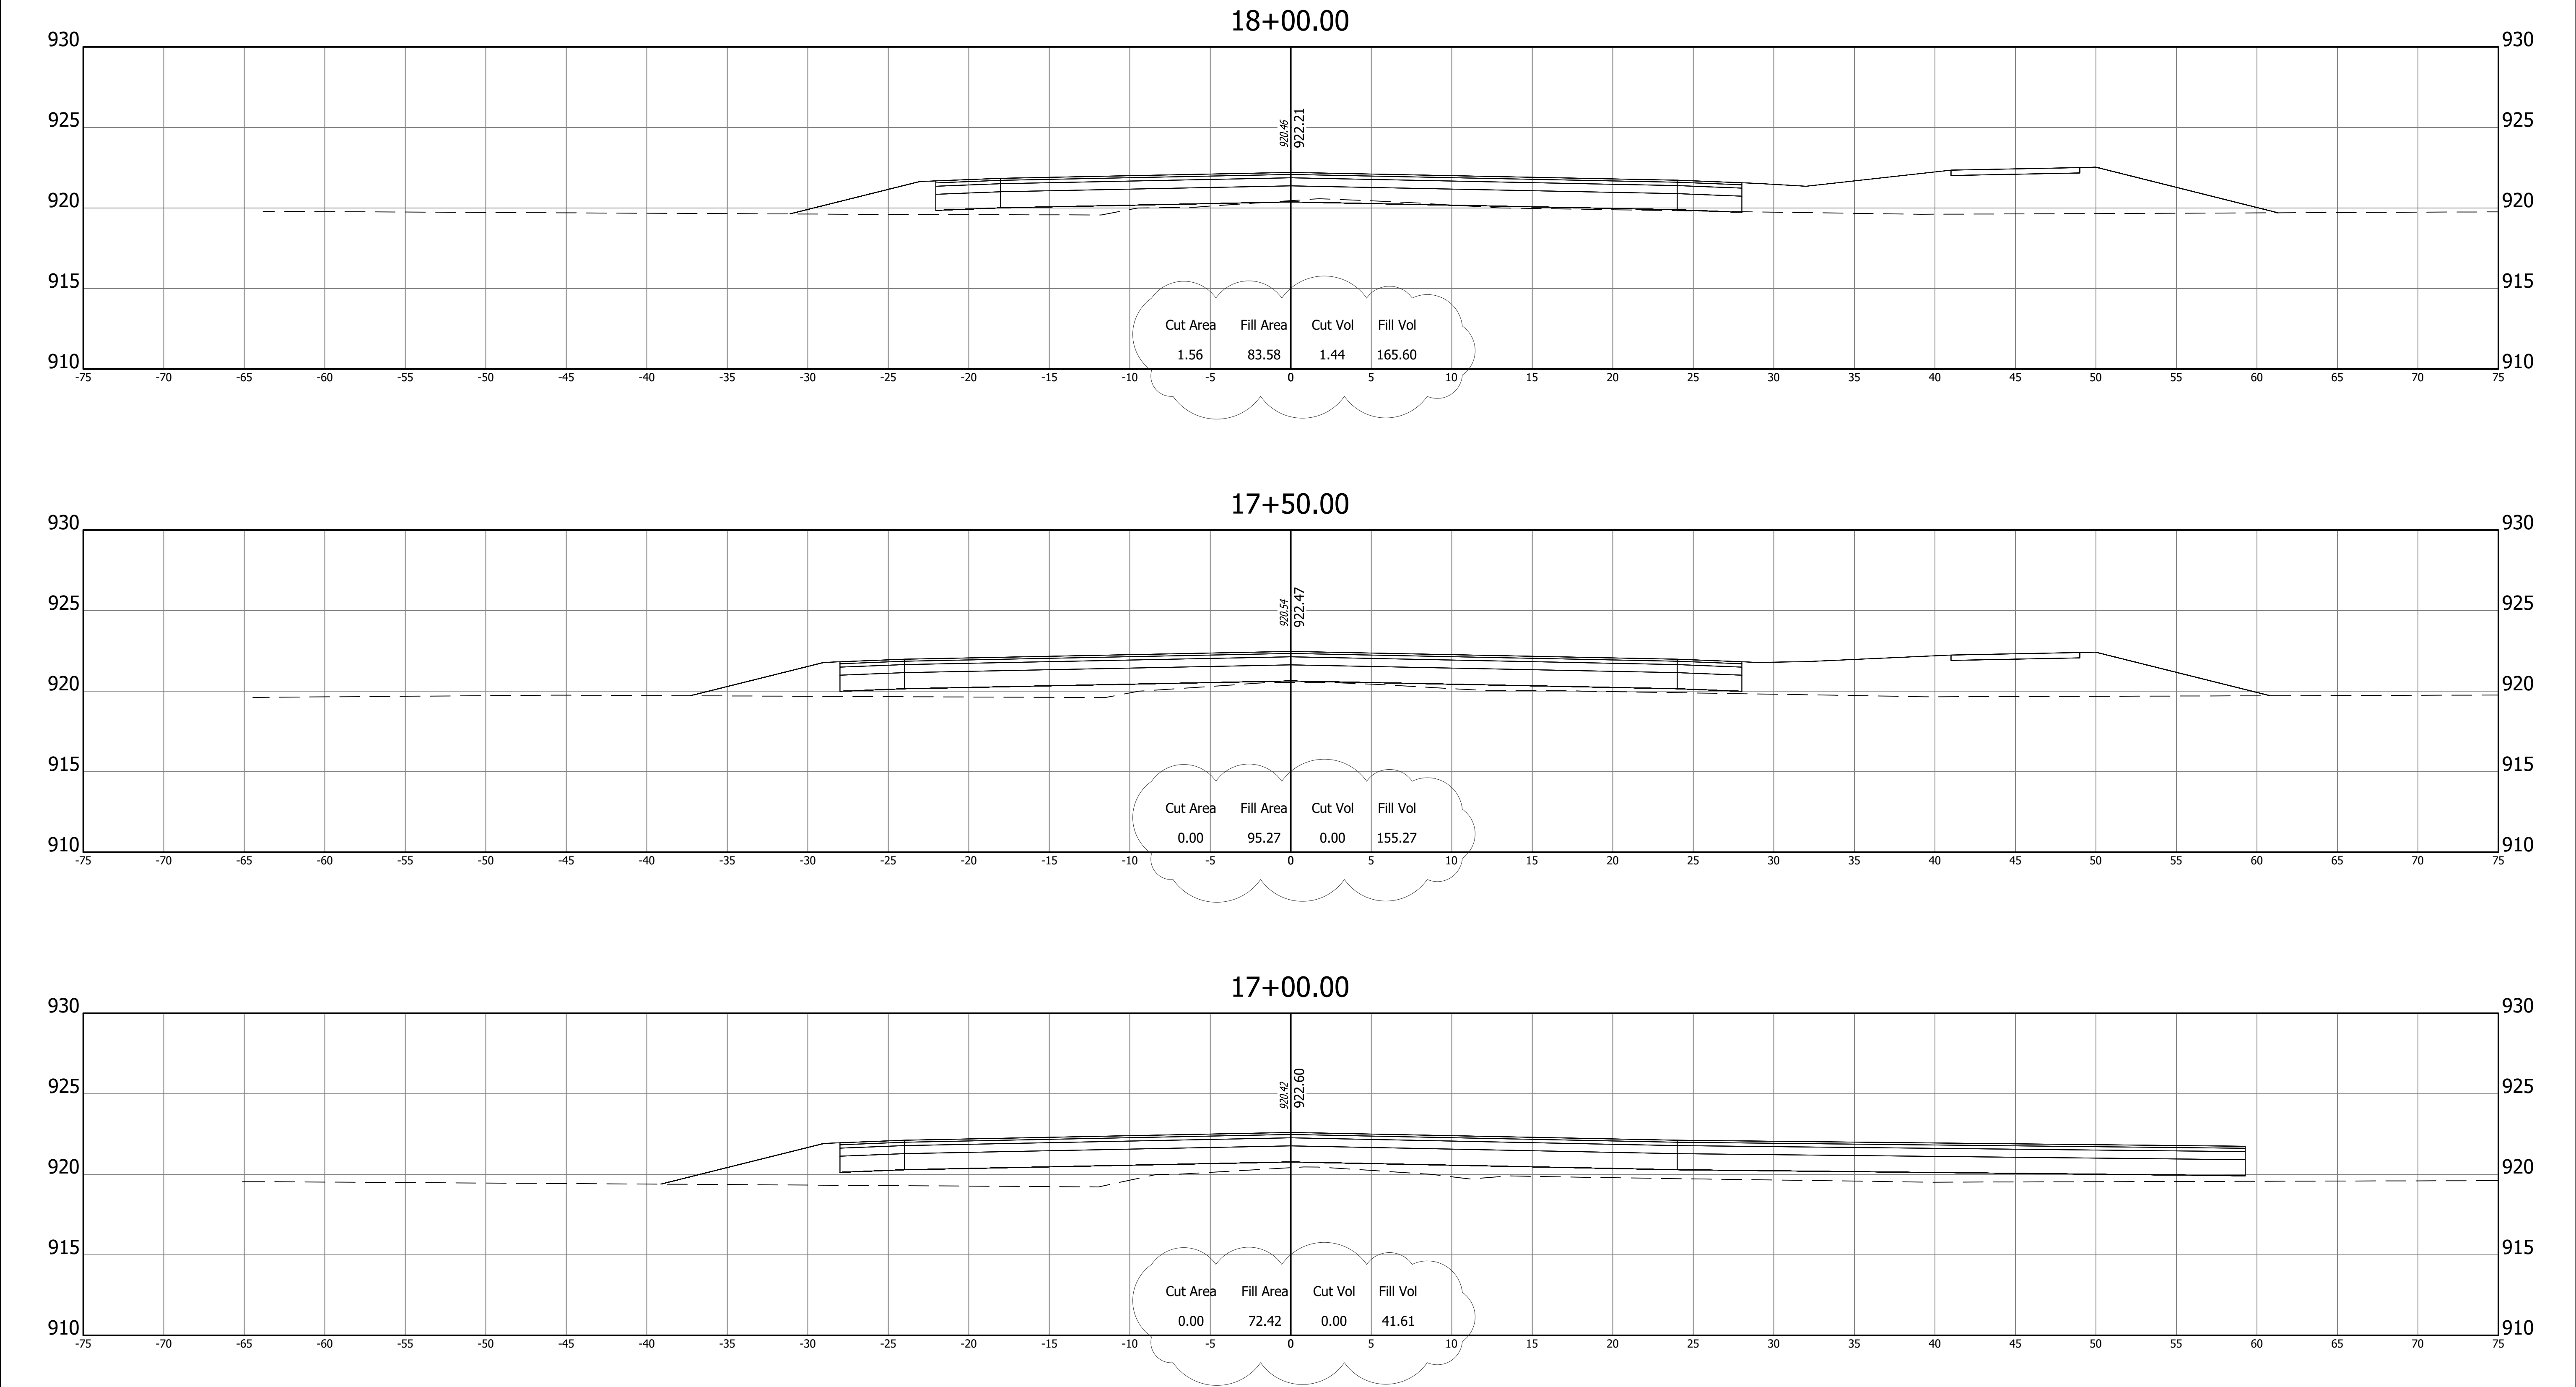

REVISIONS	
DATE	ITEM
Oct 2, 2025	Updated Earthwork

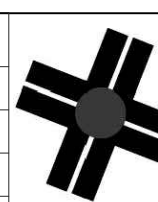


A&F ENGINEERING

Transportation & Site Engineering

Creating Order Since 1966

8365 Keystone Crossing, Suite 201, Indianapolis, IN. 46240 (317) 202-0864

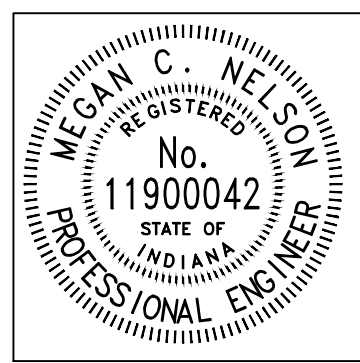




RECOMMENDED FOR APPROVAL		08/11/2025	
DESIGNED: MCN		DRAWN: AJG	
CHECKED: JAH		CHECKED: JAH	

WESTFIELD
WASHINGTON SCHOOLS


CROSS SECTIONS
LINE "PR-B"


HORIZONTAL SCALE 1"=5'	BRIDGE FILE N/A
VERTICAL SCALE 1"=5'	DESIGNATION --
SHEETS	
32	of 48
CONTRACT	
--	

Z:\2024\240787-CONTEXT DESIGN TRAFFIC SIGNAL, SR 32-CENTENNIAL RD PH5 1D.WG\CENTENNIAL PLAN SET\240787-CORRIDOR CENTENNIAL.DWG

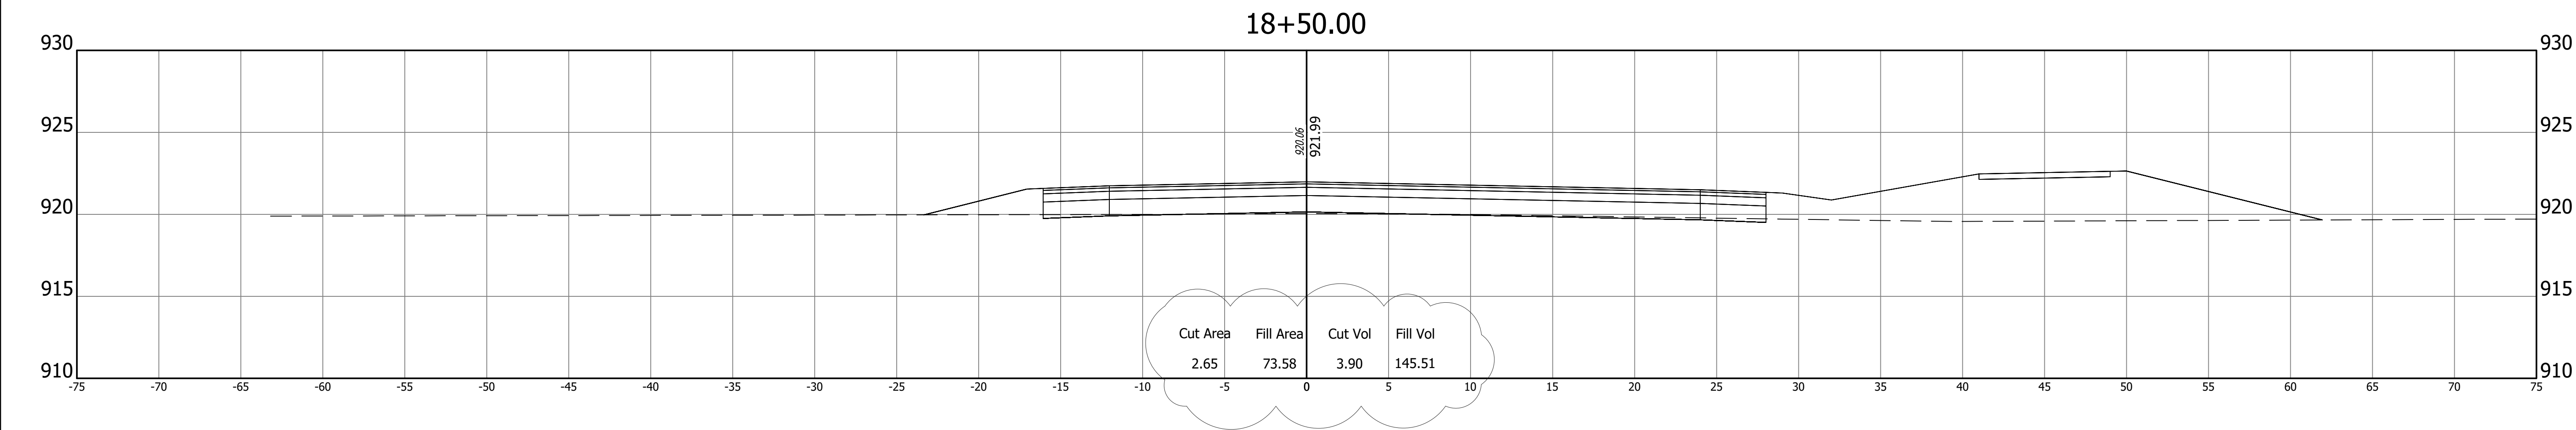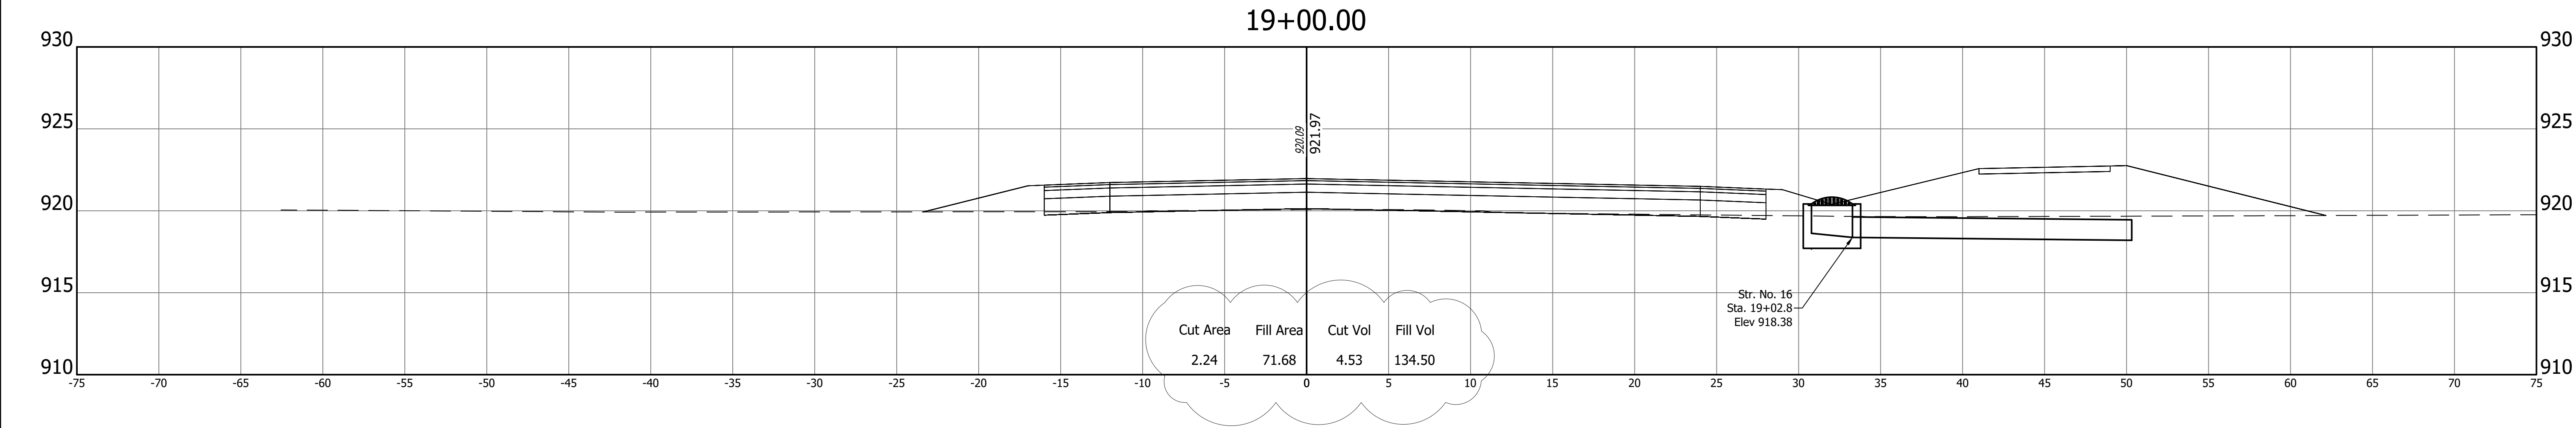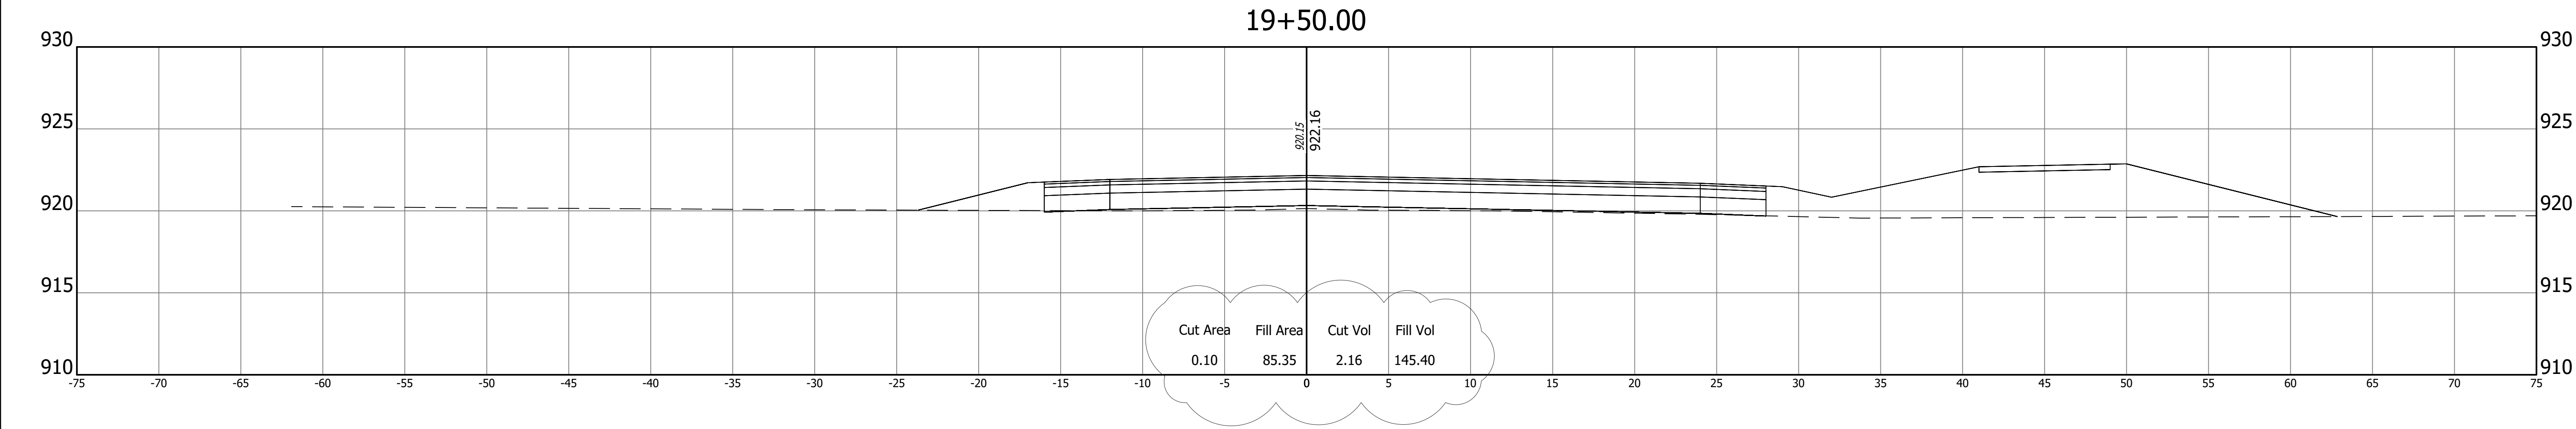

REVISIONS	
DATE	ITEM
Oct 2, 2025	Updated Earthwork

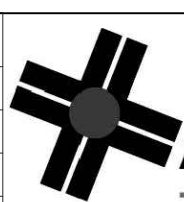**A&F ENGINEERING**
Transportation & Site Engineering
Creating Order Since 1966
8365 Keystone Crossing, Suite 201, Indianapolis, IN. 46240 (317) 202-0864

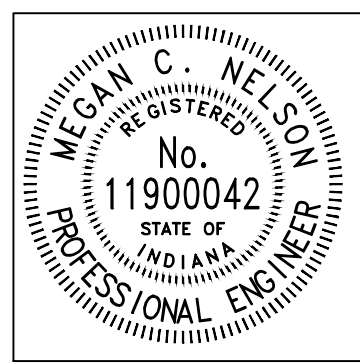



RECOMMENDED FOR APPROVAL		08/11/2025	
		DATE	
DESIGNED:	MCN	DRAWN:	AJG
CHECKED:	JAH	CHECKED:	JAH

WESTFIELD WASHINGTON SCHOOLS	
CROSS SECTIONS LINE "PR-B"	

HORIZONTAL SCALE	BRIDGE FILE		
1"=5'	N/A		
VERTICAL SCALE	DESIGNATION		
1"=5'	--		
	SHEETS		
	33	of	48
	CONTRACT		
	--		

Z:\2024\240787-CONTEXT DESIGN TRAFFIC SIGNAL, SR 32-CENTENNIAL RD PH5 1D.WG\CENTENNIAL PLAN SET\240787-CORRIDOR CENTENNIAL.DWG

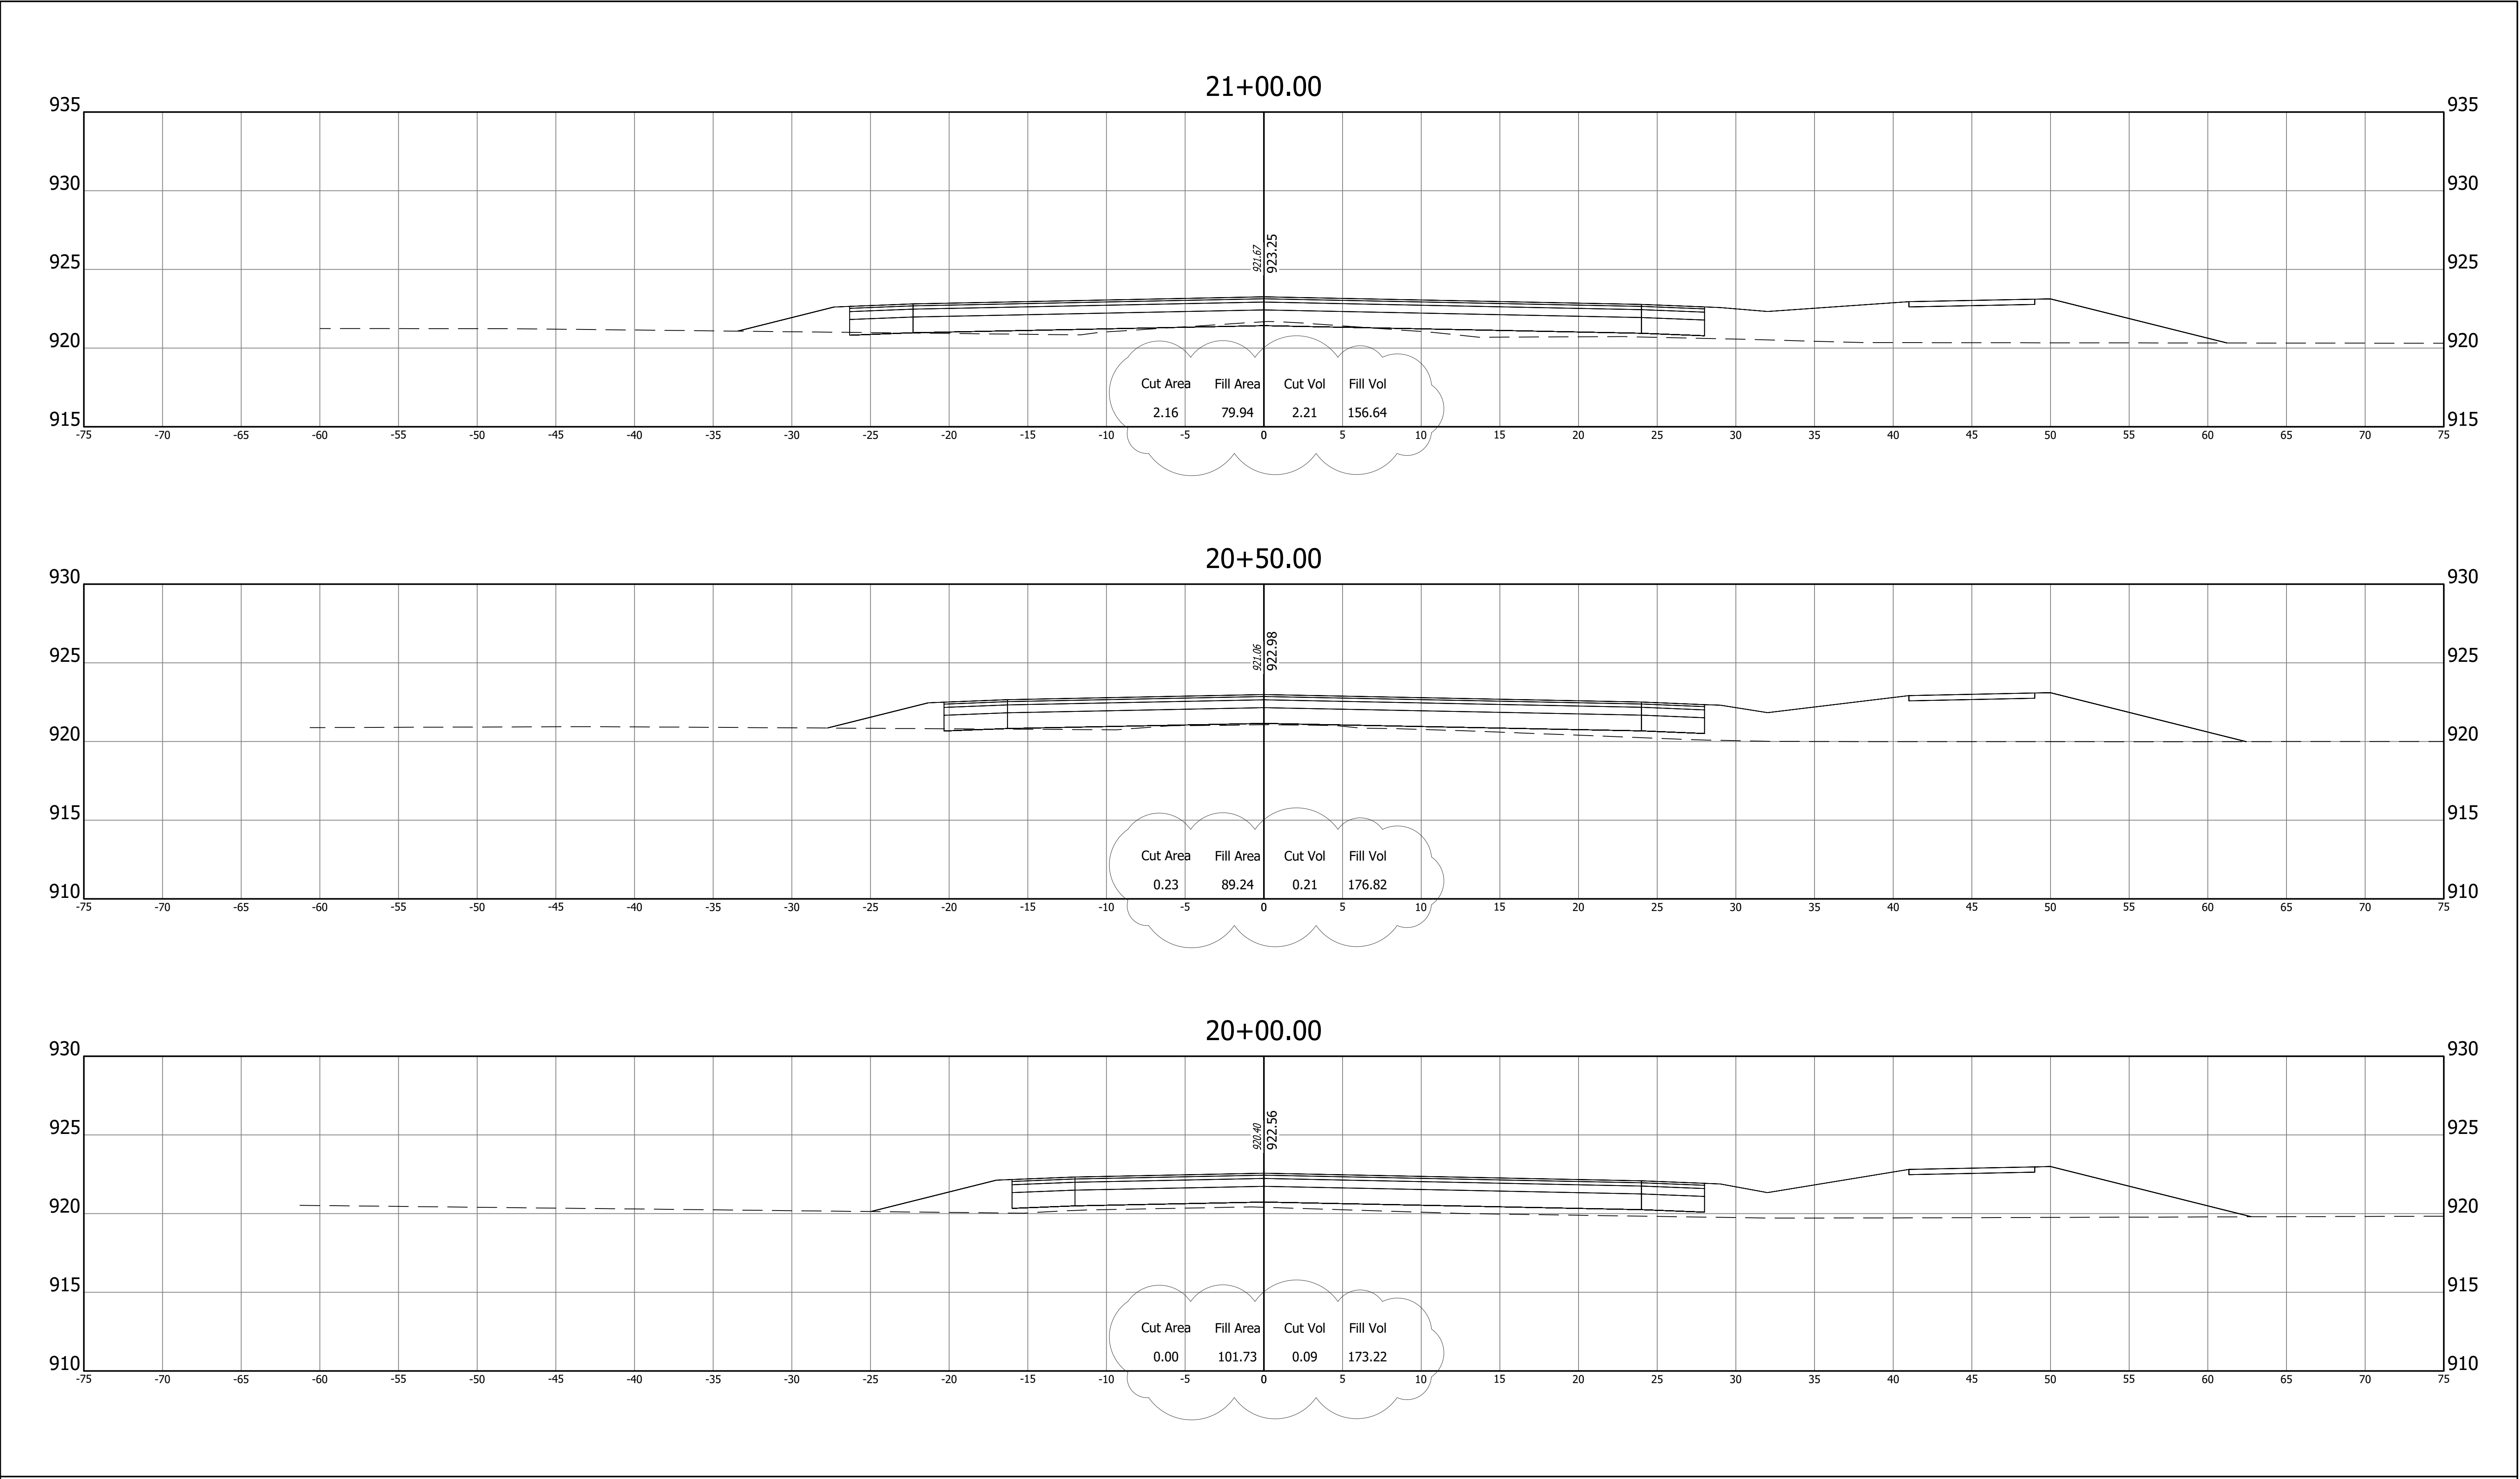


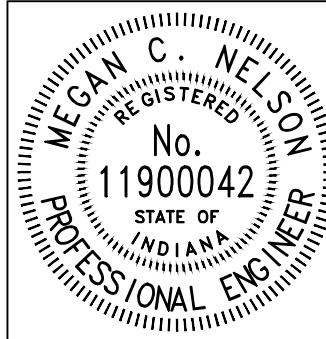
REVISIONS		 A&F ENGINEERING Transportation & Site Engineering Creating Order Since 1966 8365 Keystone Crossing, Suite 201, Indianapolis, IN. 46240 (317) 202-0864		RECOMMENDED FOR APPROVAL  08/11/2025 DESIGN ENGINEER DATE		WESTFIELD WASHINGTON SCHOOLS		HORIZONTAL SCALE 1"=5'		BRIDGE FILE N/A	
DATE	ITEM							VERTICAL SCALE 1"=5'		DESIGNATION --	
Oct 2, 2025	Updated Earthwork									SHEETS	
										34 of 48	
										CONTRACT	
										--	

DESIGNED: MCN	DRAWN: AJG
CHECKED: JAH	CHECKED: JAH

CROSS SECTIONS LINE "PR-B"	
-------------------------------	--


Z:\1202\12\240787-CONTEXT DESIGN-TRAFFIC SIGNAL, SR 32-CENTENNIAL RD PH15 1D\DWG\CENTENNIAL PLAN SET\240787-CORRIDOR CENTENNIAL.DWG

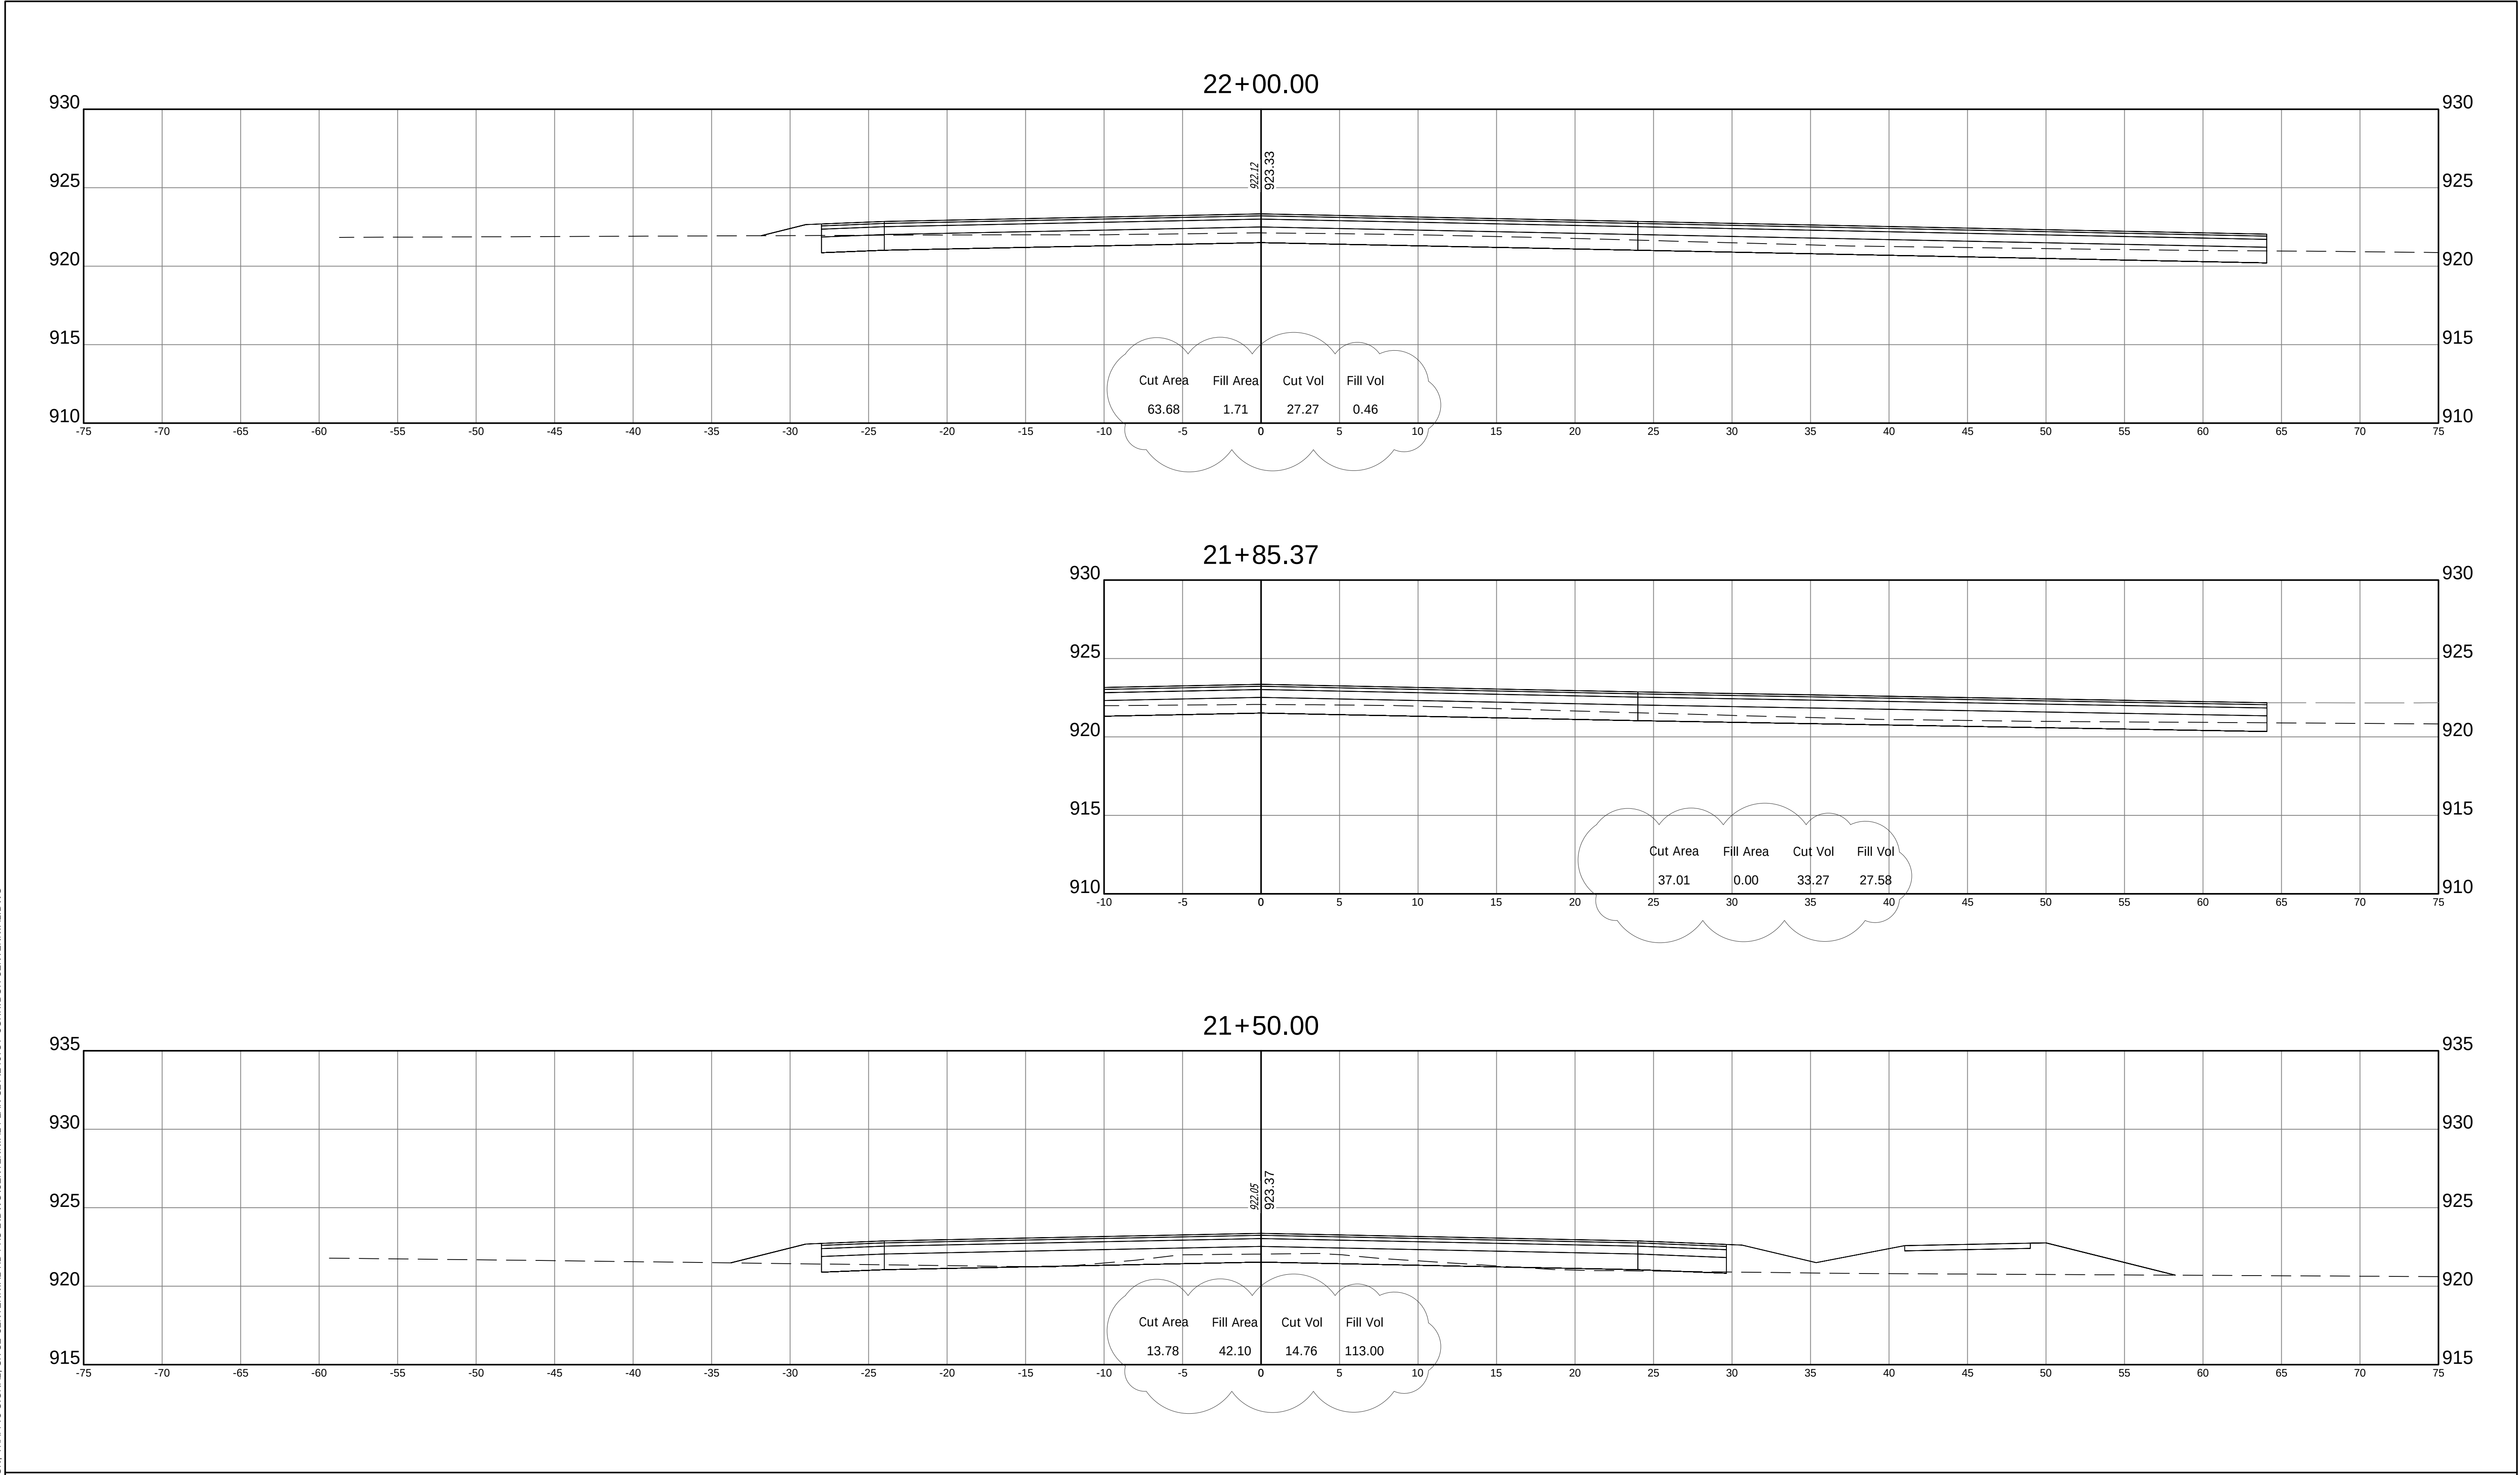

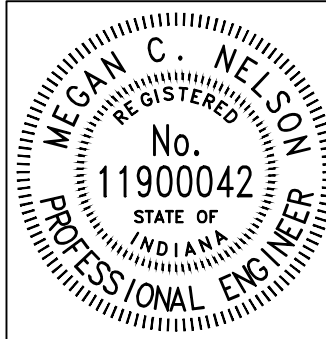
REVISIONS		 A&F ENGINEERING Transportation & Site Engineering Creating Order Since 1966 8365 Keystone Crossing, Suite 201, Indianapolis, IN. 46240 (317) 202-0864		RECOMMENDED FOR APPROVAL  DESIGN ENGINEER DATE 08/11/2025		WESTFIELD WASHINGTON SCHOOLS		HORIZONTAL SCALE 1"=5'		BRIDGE FILE N/A	
DATE: Oct 2, 2025 ITEM: Updated Earthwork				DESIGNED: MCN CHECKED: JAH		DRAWN: AJG CHECKED: JAH		VERTICAL SCALE 1"=5'		DESIGNATION --	
										SHEETS 35 of 48	
										CONTRACT --	

CROSS SECTIONS
LINE "PR-B"

Z:\2024\240787-CONTEXT DESIGN TRAFFIC SIGNAL, SR 32-CENTENNIAL RD PH5 1D\DWG\CENTENNIAL PLAN SET\240787-CORRIDOR CENTENNIAL.DWG

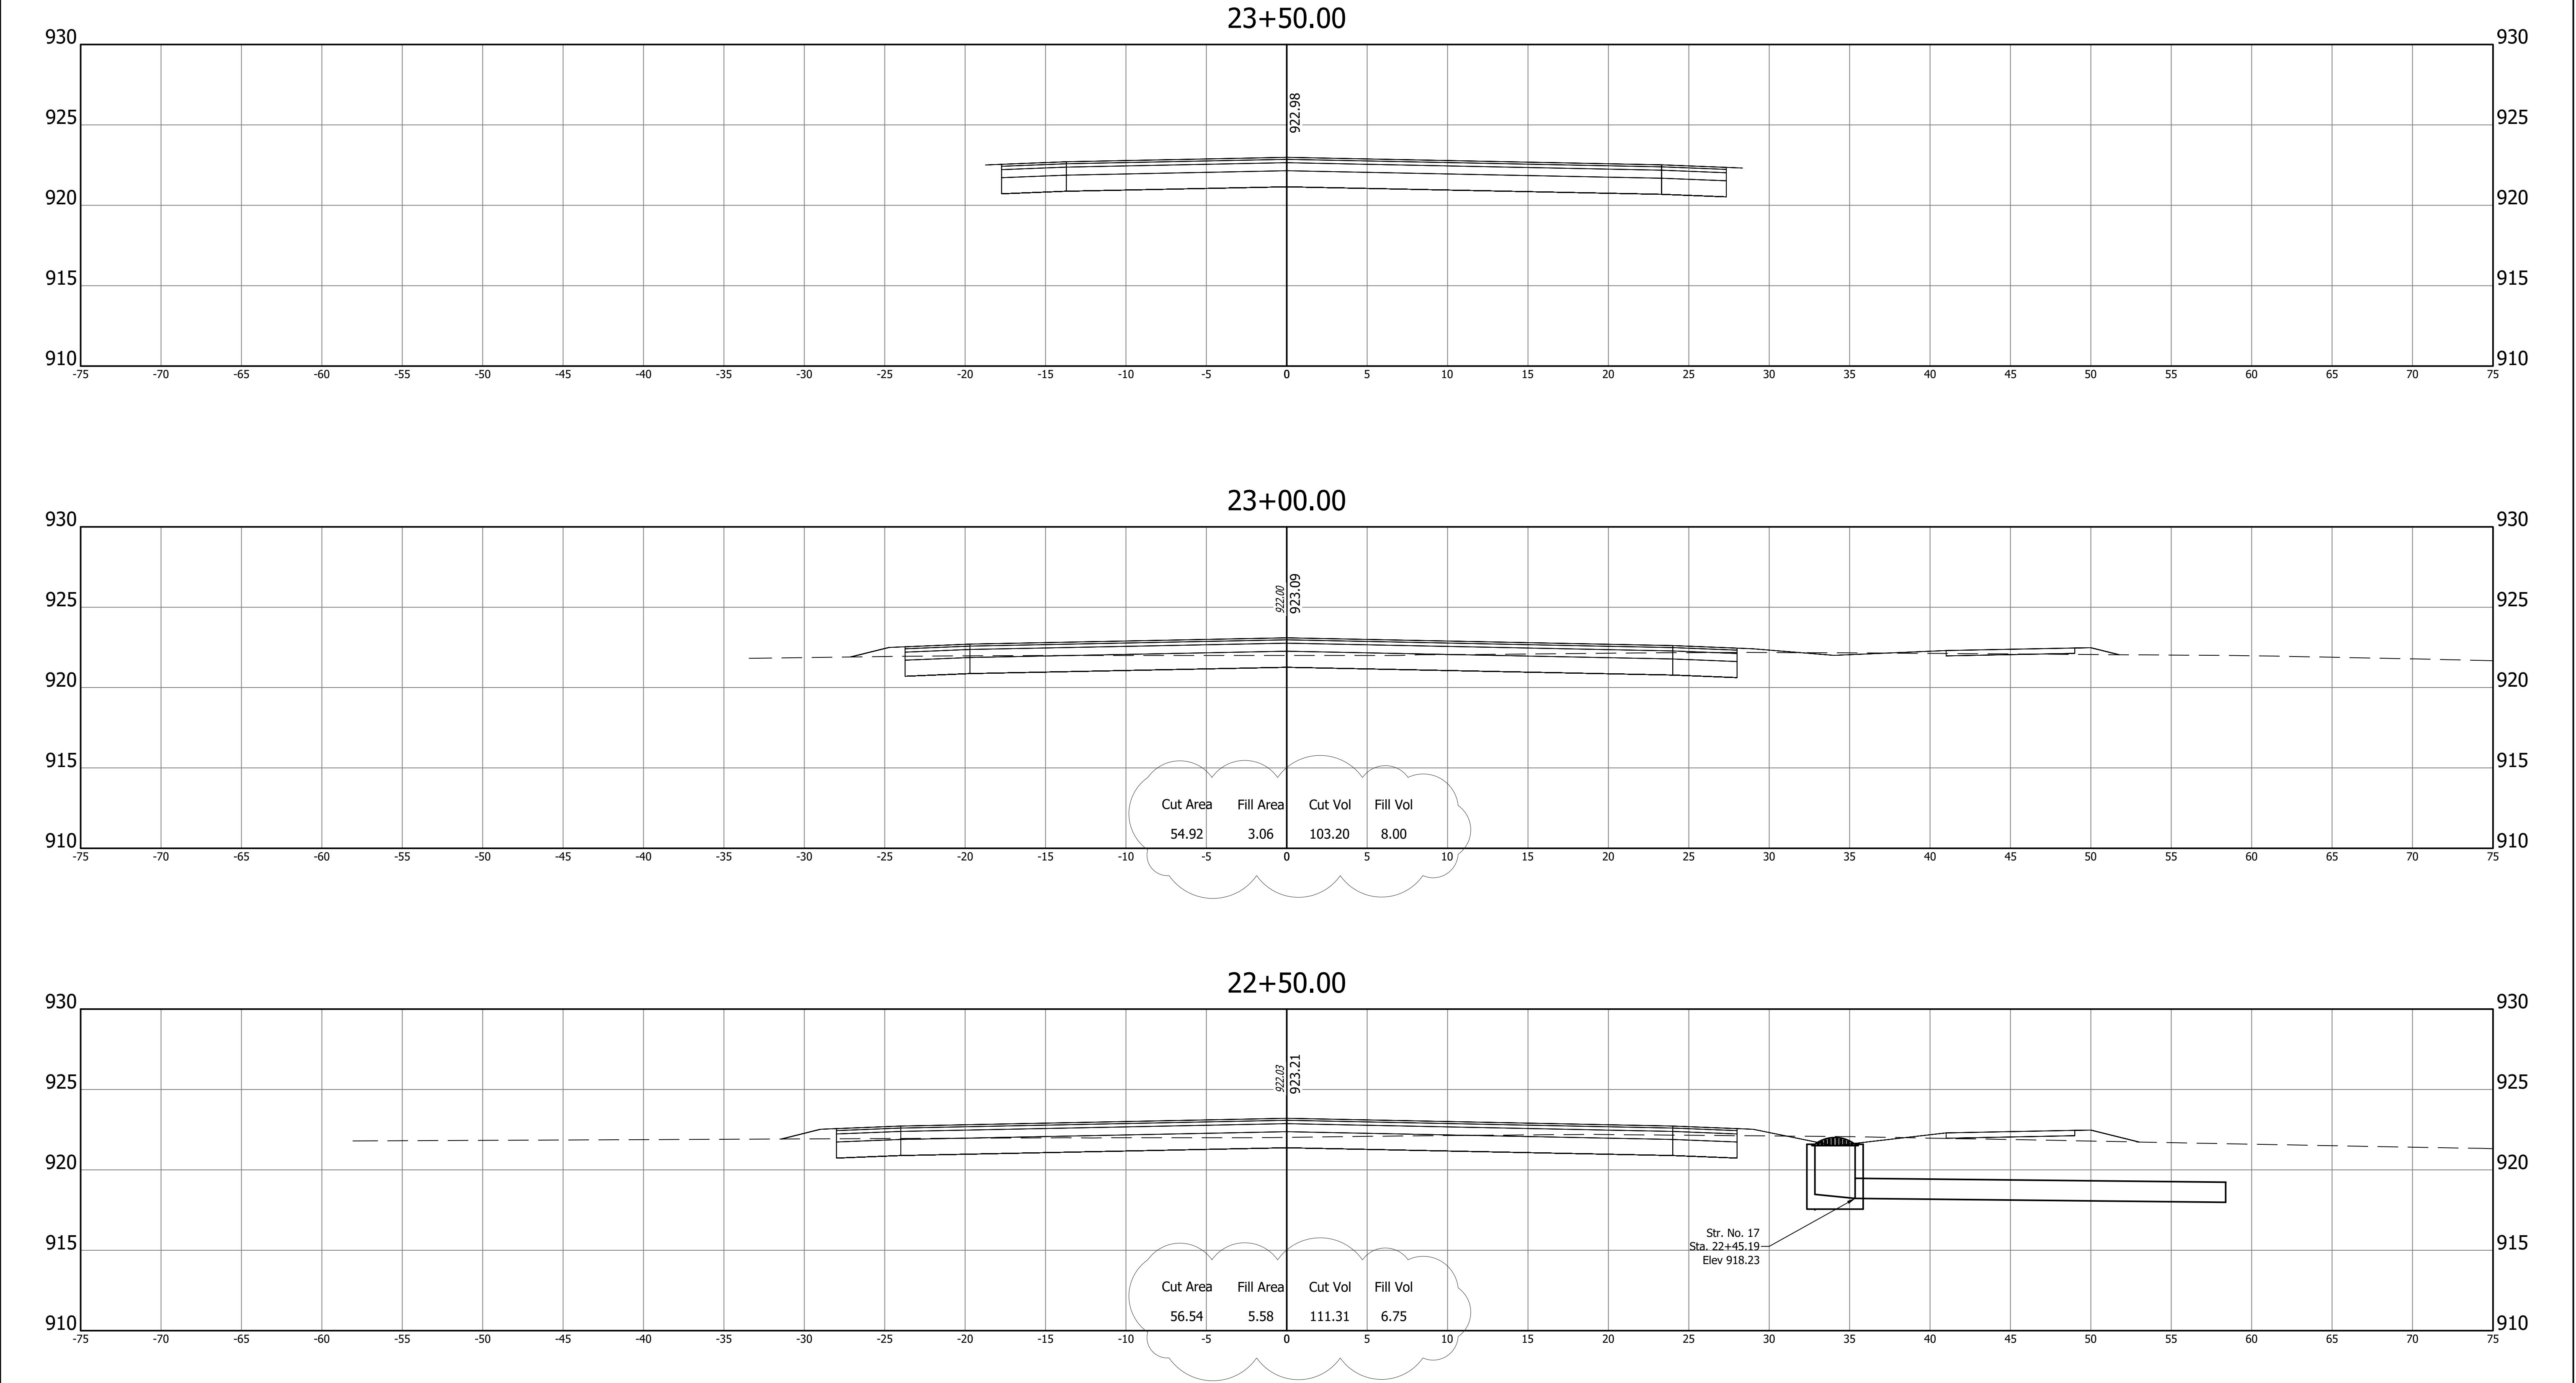

REVISIONS	
DATE	ITEM
Oct 2, 2025	Updated Earthwork

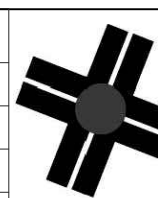


A&F ENGINEERING

Transportation & Site Engineering

Creating Order Since 1966

8365 Keystone Crossing, Suite 201, Indianapolis, IN. 46240 (317) 202-0864

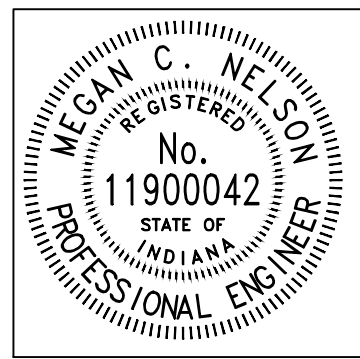


RECOMMENDED FOR APPROVAL		08/11/2025	
		DATE	
DESIGNED:	MCN	DRAWN:	AJG
CHECKED:	JAH	CHECKED:	JAH


WESTFIELD WASHINGTON SCHOOLS	
CROSS SECTIONS LINE "PR-B"	

HORIZONTAL SCALE 1"=5'	BRIDGE FILE N/A
VERTICAL SCALE 1"=5'	DESIGNATION --
SHEETS	
36	of 48
CONTRACT	
--	

Z:\2024\240787-CONTEXT DESIGN-TRAFFIC SIGNAL, SR 32-CENTENNIAL RD PH5 1\DWG\CENTENNIAL PLAN SET\240787-CORRIDOR CENTENNIAL.DWG

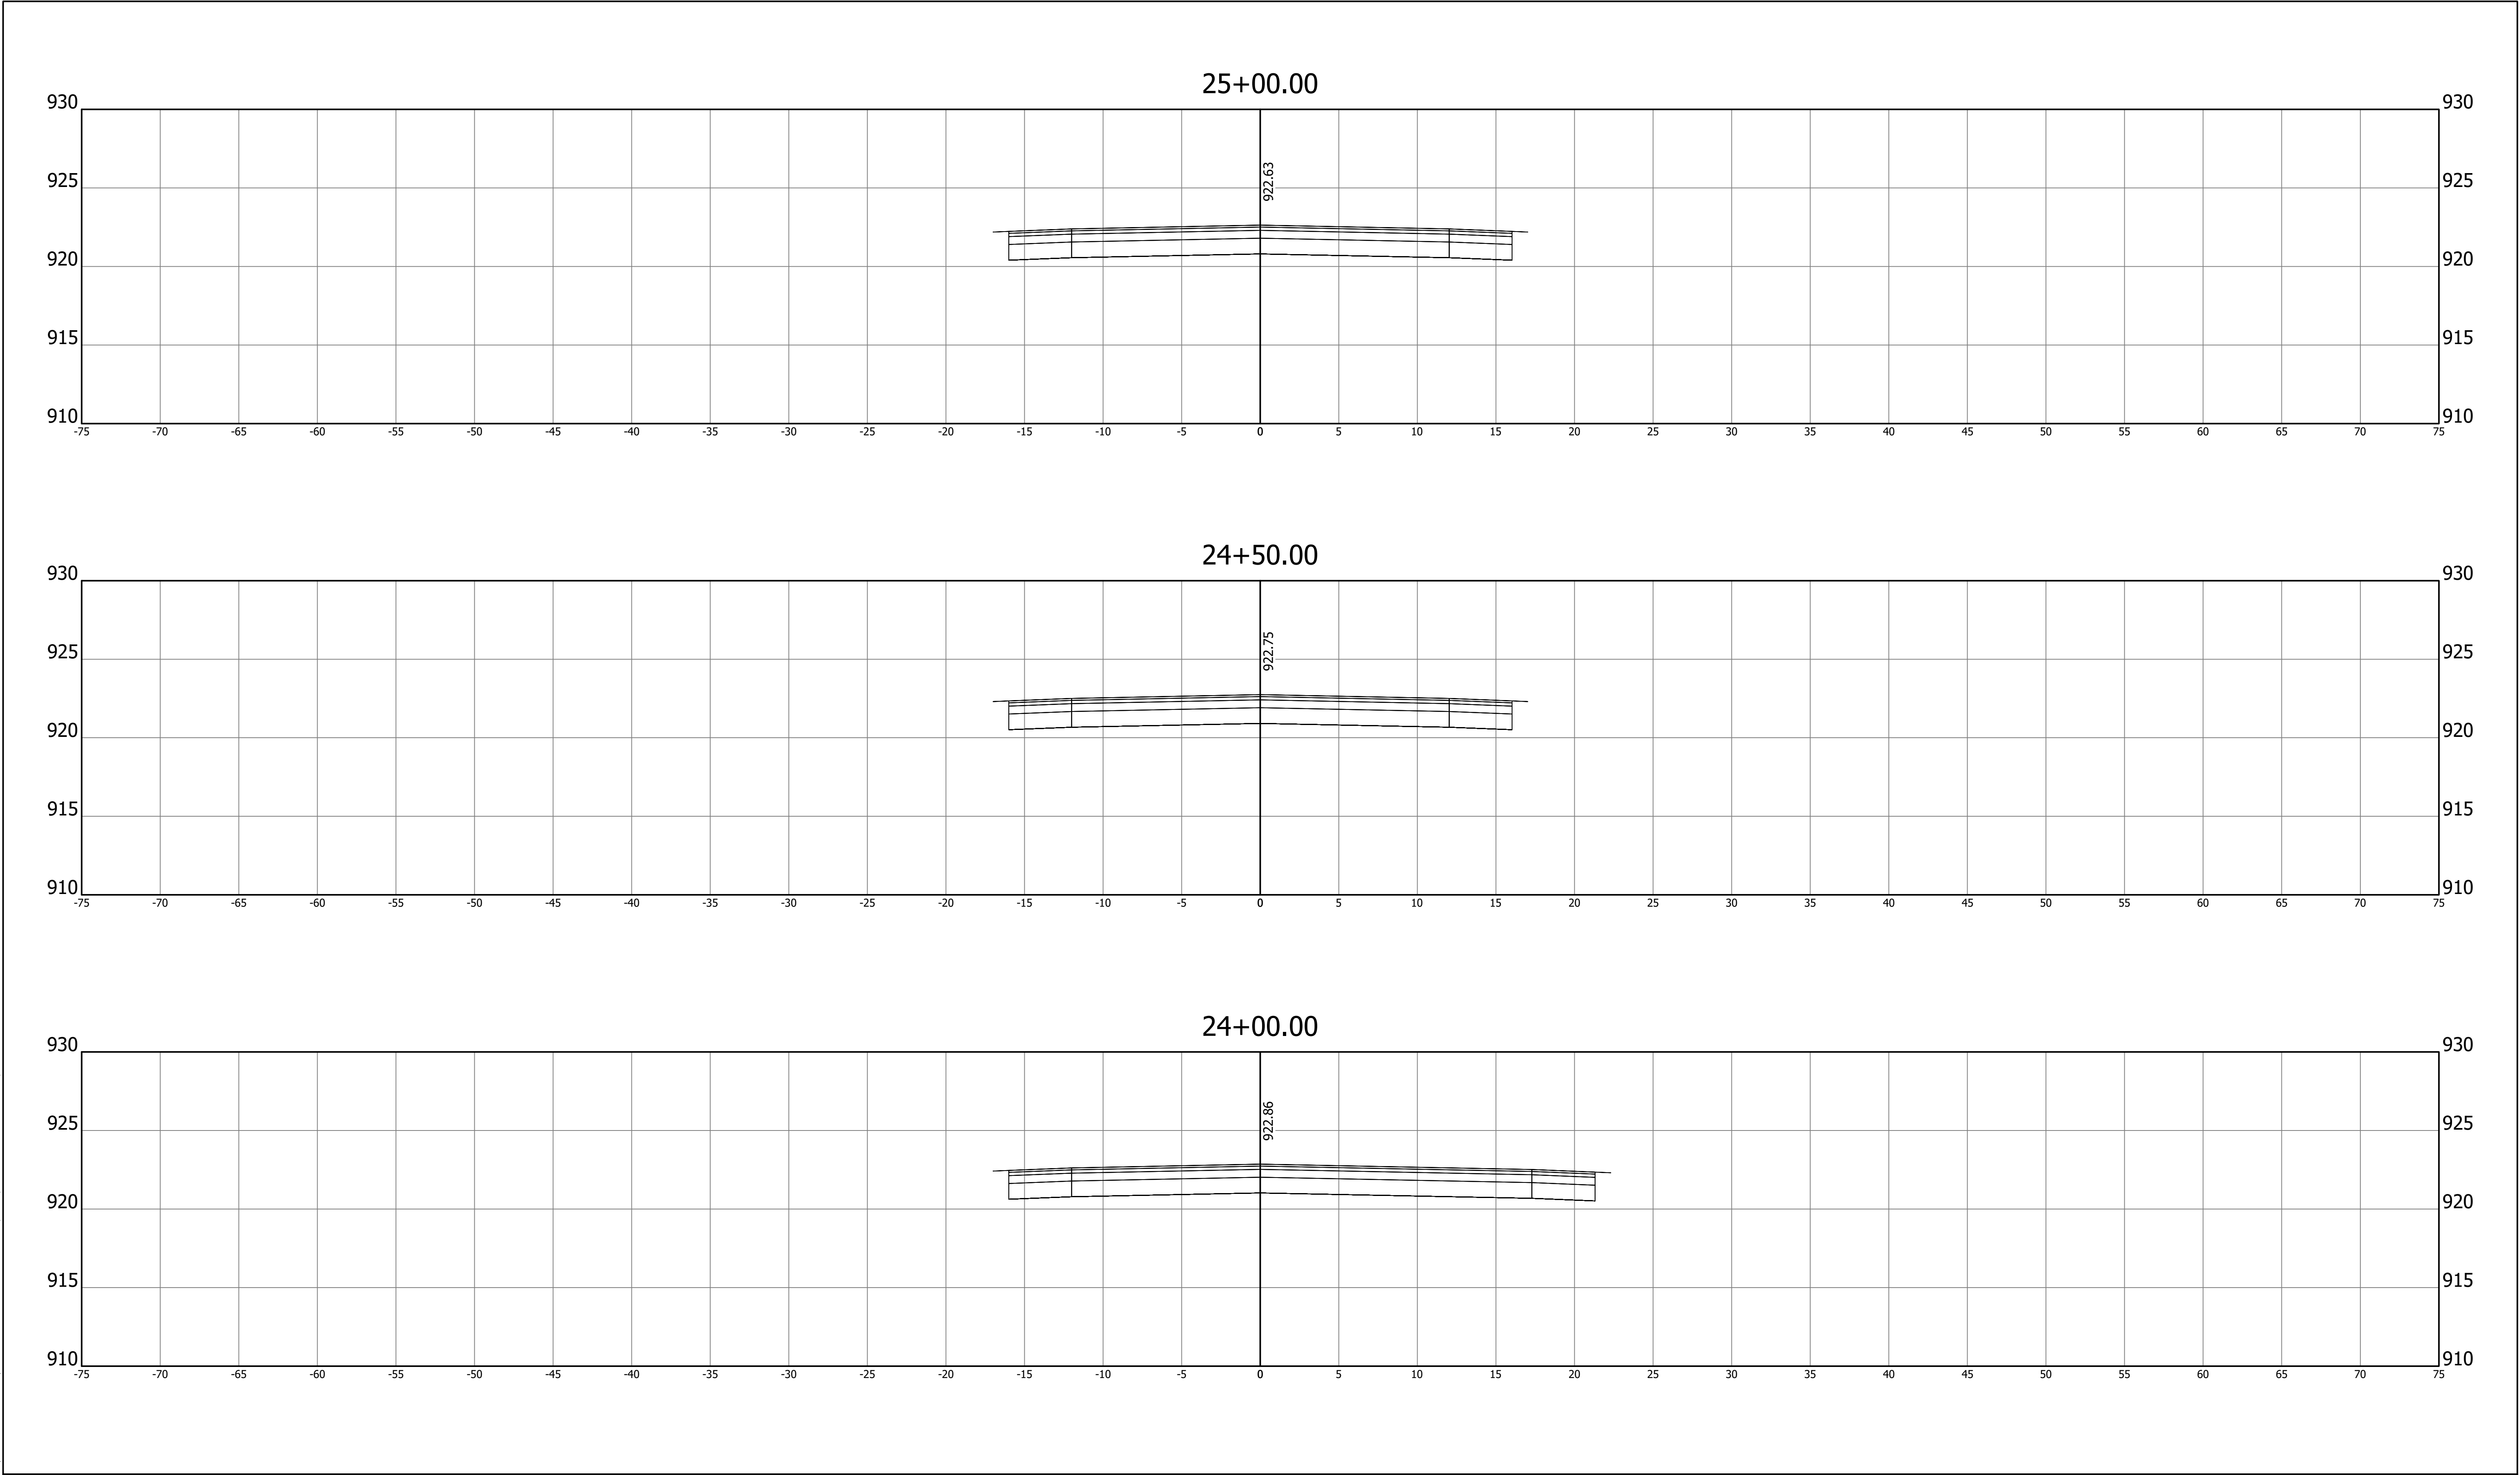

REVISIONS	
DATE	ITEM
Oct 2, 2025	Updated Earthwork

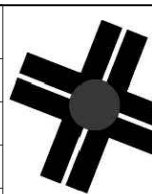



A&F ENGINEERING

Transportation & Site Engineering

Creating Order Since 1966

 8365 Keystone Crossing, Suite 201, Indianapolis, IN. 46240 (317) 202-0864

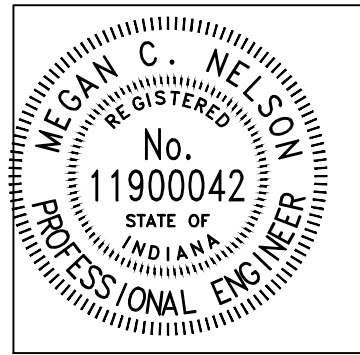


RECOMMENDED FOR APPROVAL		08/11/2025	
		DATE	
DESIGNED: MCN		DRAWN: AJG	
CHECKED: JAH		CHECKED: JAH	


WESTFIELD WASHINGTON SCHOOLS
CROSS SECTIONS LINE "PR-B"

HORIZONTAL SCALE	BRIDGE FILE		
1"=5'	N/A		
VERTICAL SCALE	DESIGNATION		
1"=5'	--		
	SHEETS		
	37	of	48
	CONTRACT		
	--		

Z:\2024\240787-CONTEXT DESIGN TRAFFIC SIGNAL SR 32-CENTENNIAL RD PH5 1.DWG(CENTENNIAL PLAN SET)240787-CORRIDOR CENTENNIAL.DWG

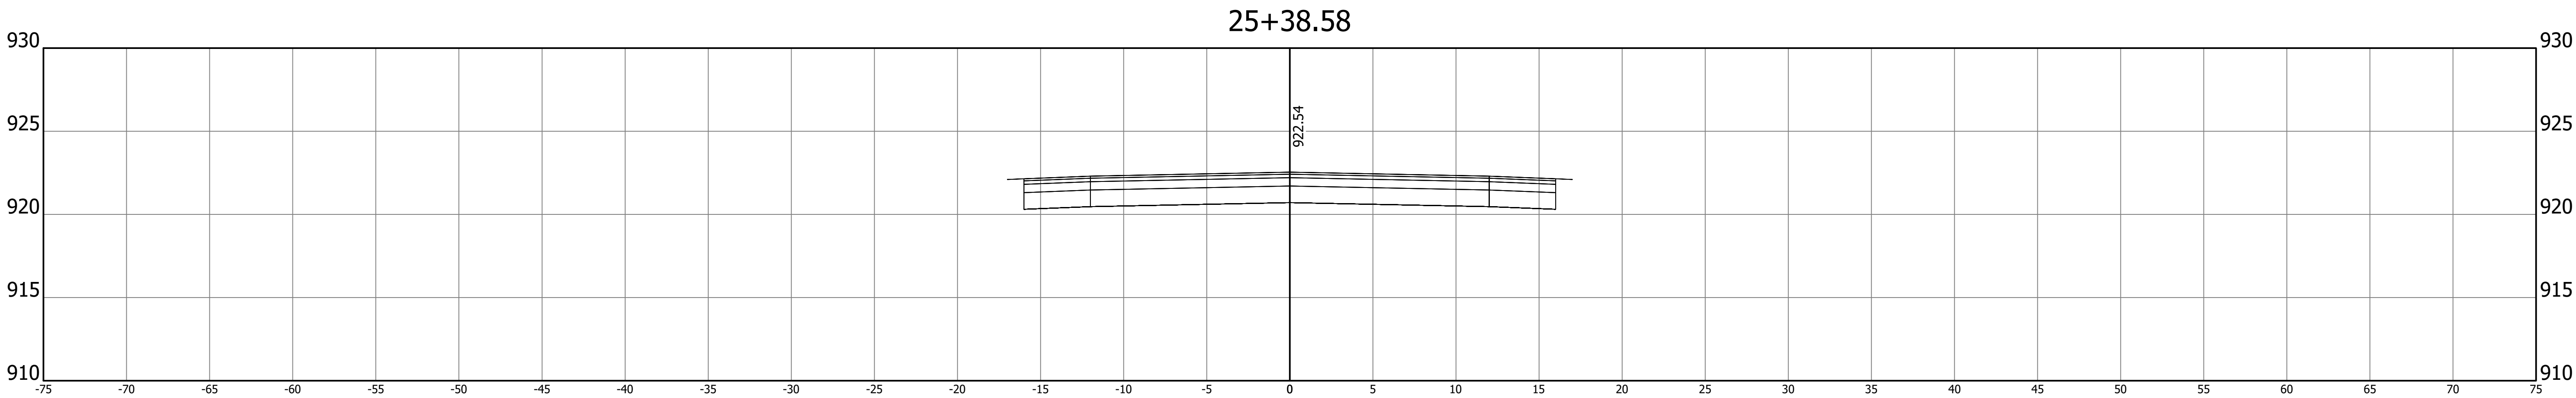

REVISIONS	
DATE	ITEM
Oct 2, 2025	Updated Earthwork

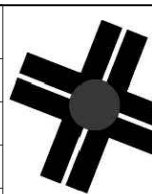


A&F ENGINEERING

Transportation & Site Engineering

Creating Order Since 1966

8365 Keystone Crossing, Suite 201, Indianapolis, IN. 46240 (317) 202-0864

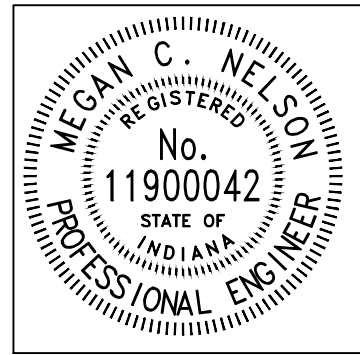


RECOMMENDED FOR APPROVAL		08/11/2025	
<i>Megan C. Nelson</i>		DATE	
DESIGNED: MCN		DRAWN: AJG	
CHECKED: JAH		CHECKED: JAH	


WESTFIELD WASHINGTON SCHOOLS	HORIZONTAL SCALE		BRIDGE FILE	
	1"=5'		N/A	
CROSS SECTIONS LINE "PR-B"	VERTICAL SCALE		DESIGNATION	
	1"=5'		--	
		SHEETS		
		38	of	48
		CONTRACT		
		--		

HORIZONTAL SCALE		BRIDGE FILE	
1"=5'		N/A	
VERTICAL SCALE		DESIGNATION	
1"=5'		--	
		SHEETS	
		38	of 48
		CONTRACT	
		--	


Z:\2024\240787-CONTEXT DESIGN TRAFFIC SIGNAL, SR 32-CENTENNIAL RD PH5 1.DWG\CENTENNIAL PLAN SET\240787-CORRIDOR CENTENNIAL.DWG

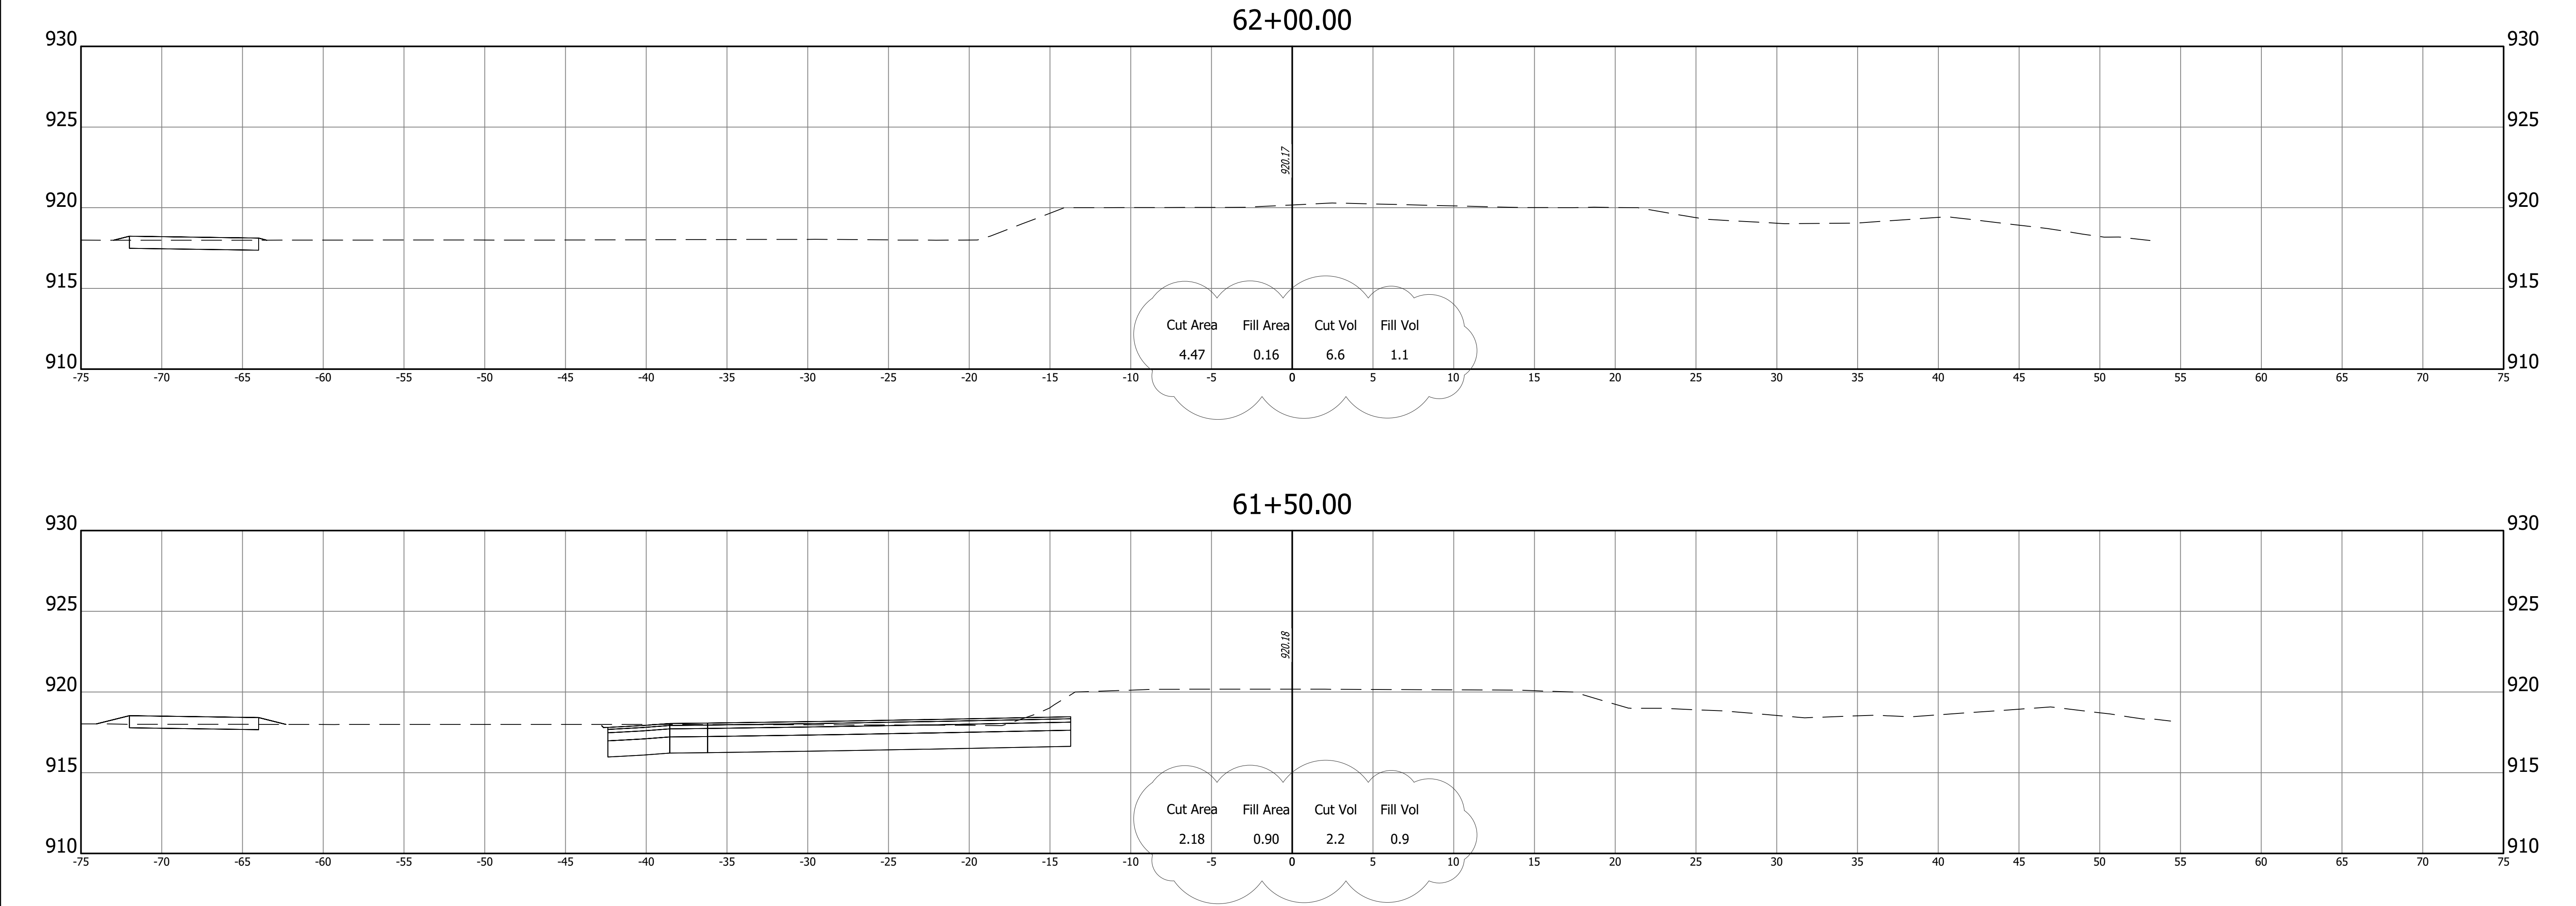

REVISIONS	
DATE	ITEM
Oct 2, 2025	Updated Earthwork

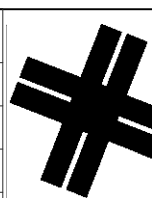


A&F ENGINEERING
Transportation & Site Engineering
Creating Order Since 1966
8365 Keystone Crossing, Suite 201, Indianapolis, IN. 46240 (317) 202-0864

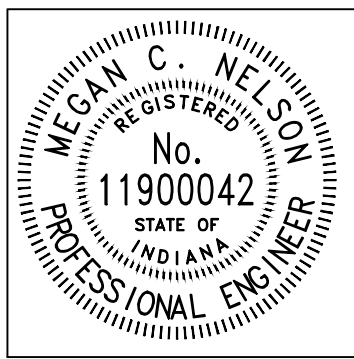

RECOMMENDED FOR APPROVAL		08/11/2025	
		DATE	
DESIGNED:	MCN	DRAWN:	AJG
CHECKED:	JAH	CHECKED:	JAH

WESTFIELD WASHINGTON SCHOOLS	HORIZONTAL SCALE		BRIDGE FILE	
	1"=5'		N/A	
CROSS SECTIONS LINE "PR-A"	VERTICAL SCALE		DESIGNATION	
	1"=5'		--	
			SHEETS	
			39	of 48
			CONTRACT	
			--	

Z:\2024\240787-CONTEXT DESIGN\TRAFFIC SIGNAL, SR 32-CENTENNIAL RD PH5 1DWG\CENTENNIAL PLAN SET\240787-CORRIDOR CENTENNIAL.DWG

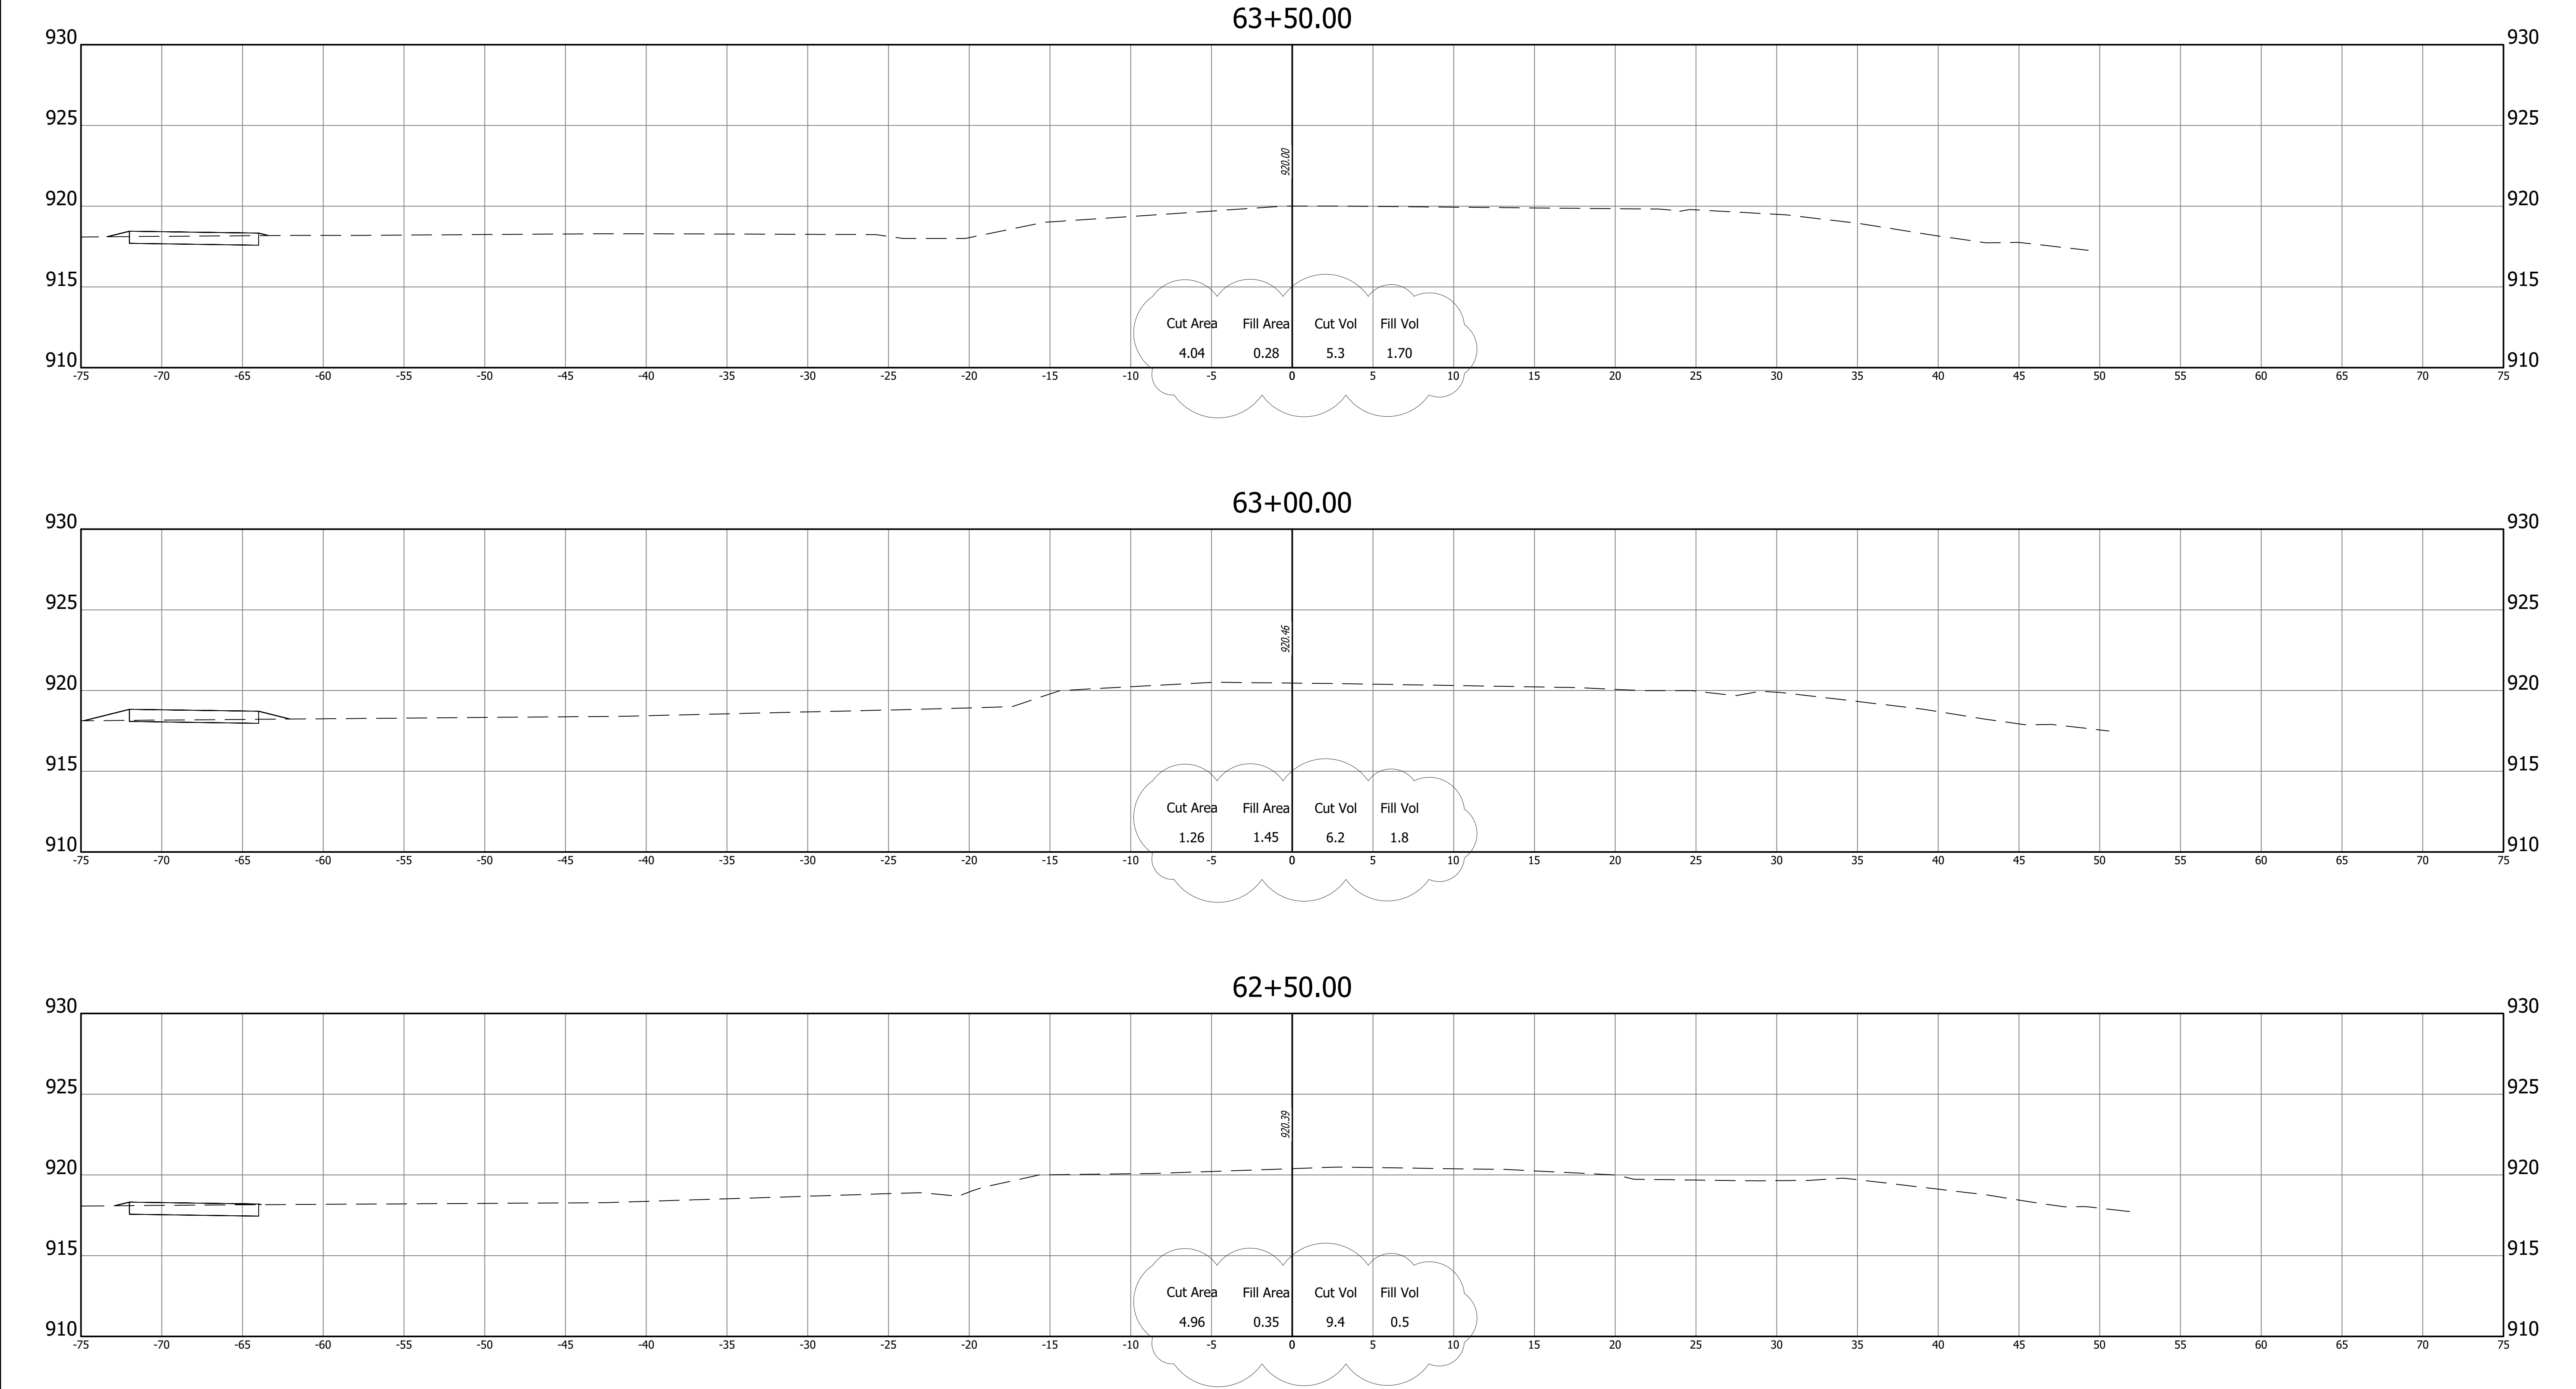


REVISIONS	
DATE	ITEM
Oct 2, 2025	Updated Earthwork



A&F ENGINEERING
Transportation & Site Engineering
Creating Order Since 1966

8365 Keystone Crossing, Suite 201, Indianapolis, IN. 46240 (317) 202-0864

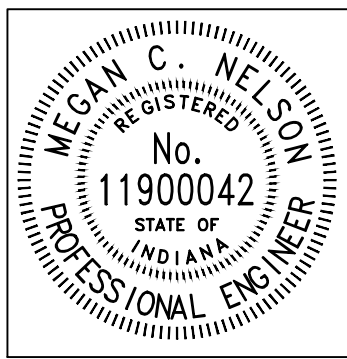


RECOMMENDED FOR APPROVAL		08/11/2025	
		DATE	
DESIGNED:	MCN	DRAWN:	AJG
CHECKED:	JAH	CHECKED:	JAH


WESTFIELD
WASHINGTON SCHOOLS

CROSS SECTIONS
LINE "PR-A"


HORIZONTAL SCALE 1"=5'	BRIDGE FILE N/A
VERTICAL SCALE 1"=5'	DESIGNATION --
SHEETS	
40	of 48
CONTRACT	
--	

Z:\2024\240787-CONTEXT DESIGN\TRAFFIC SIGNAL, SR 32-CENTENNIAL RD PH5 1D\DWG\CENTENNIAL PLAN SET\240787-CORRIDOR CENTENNIAL.DWG

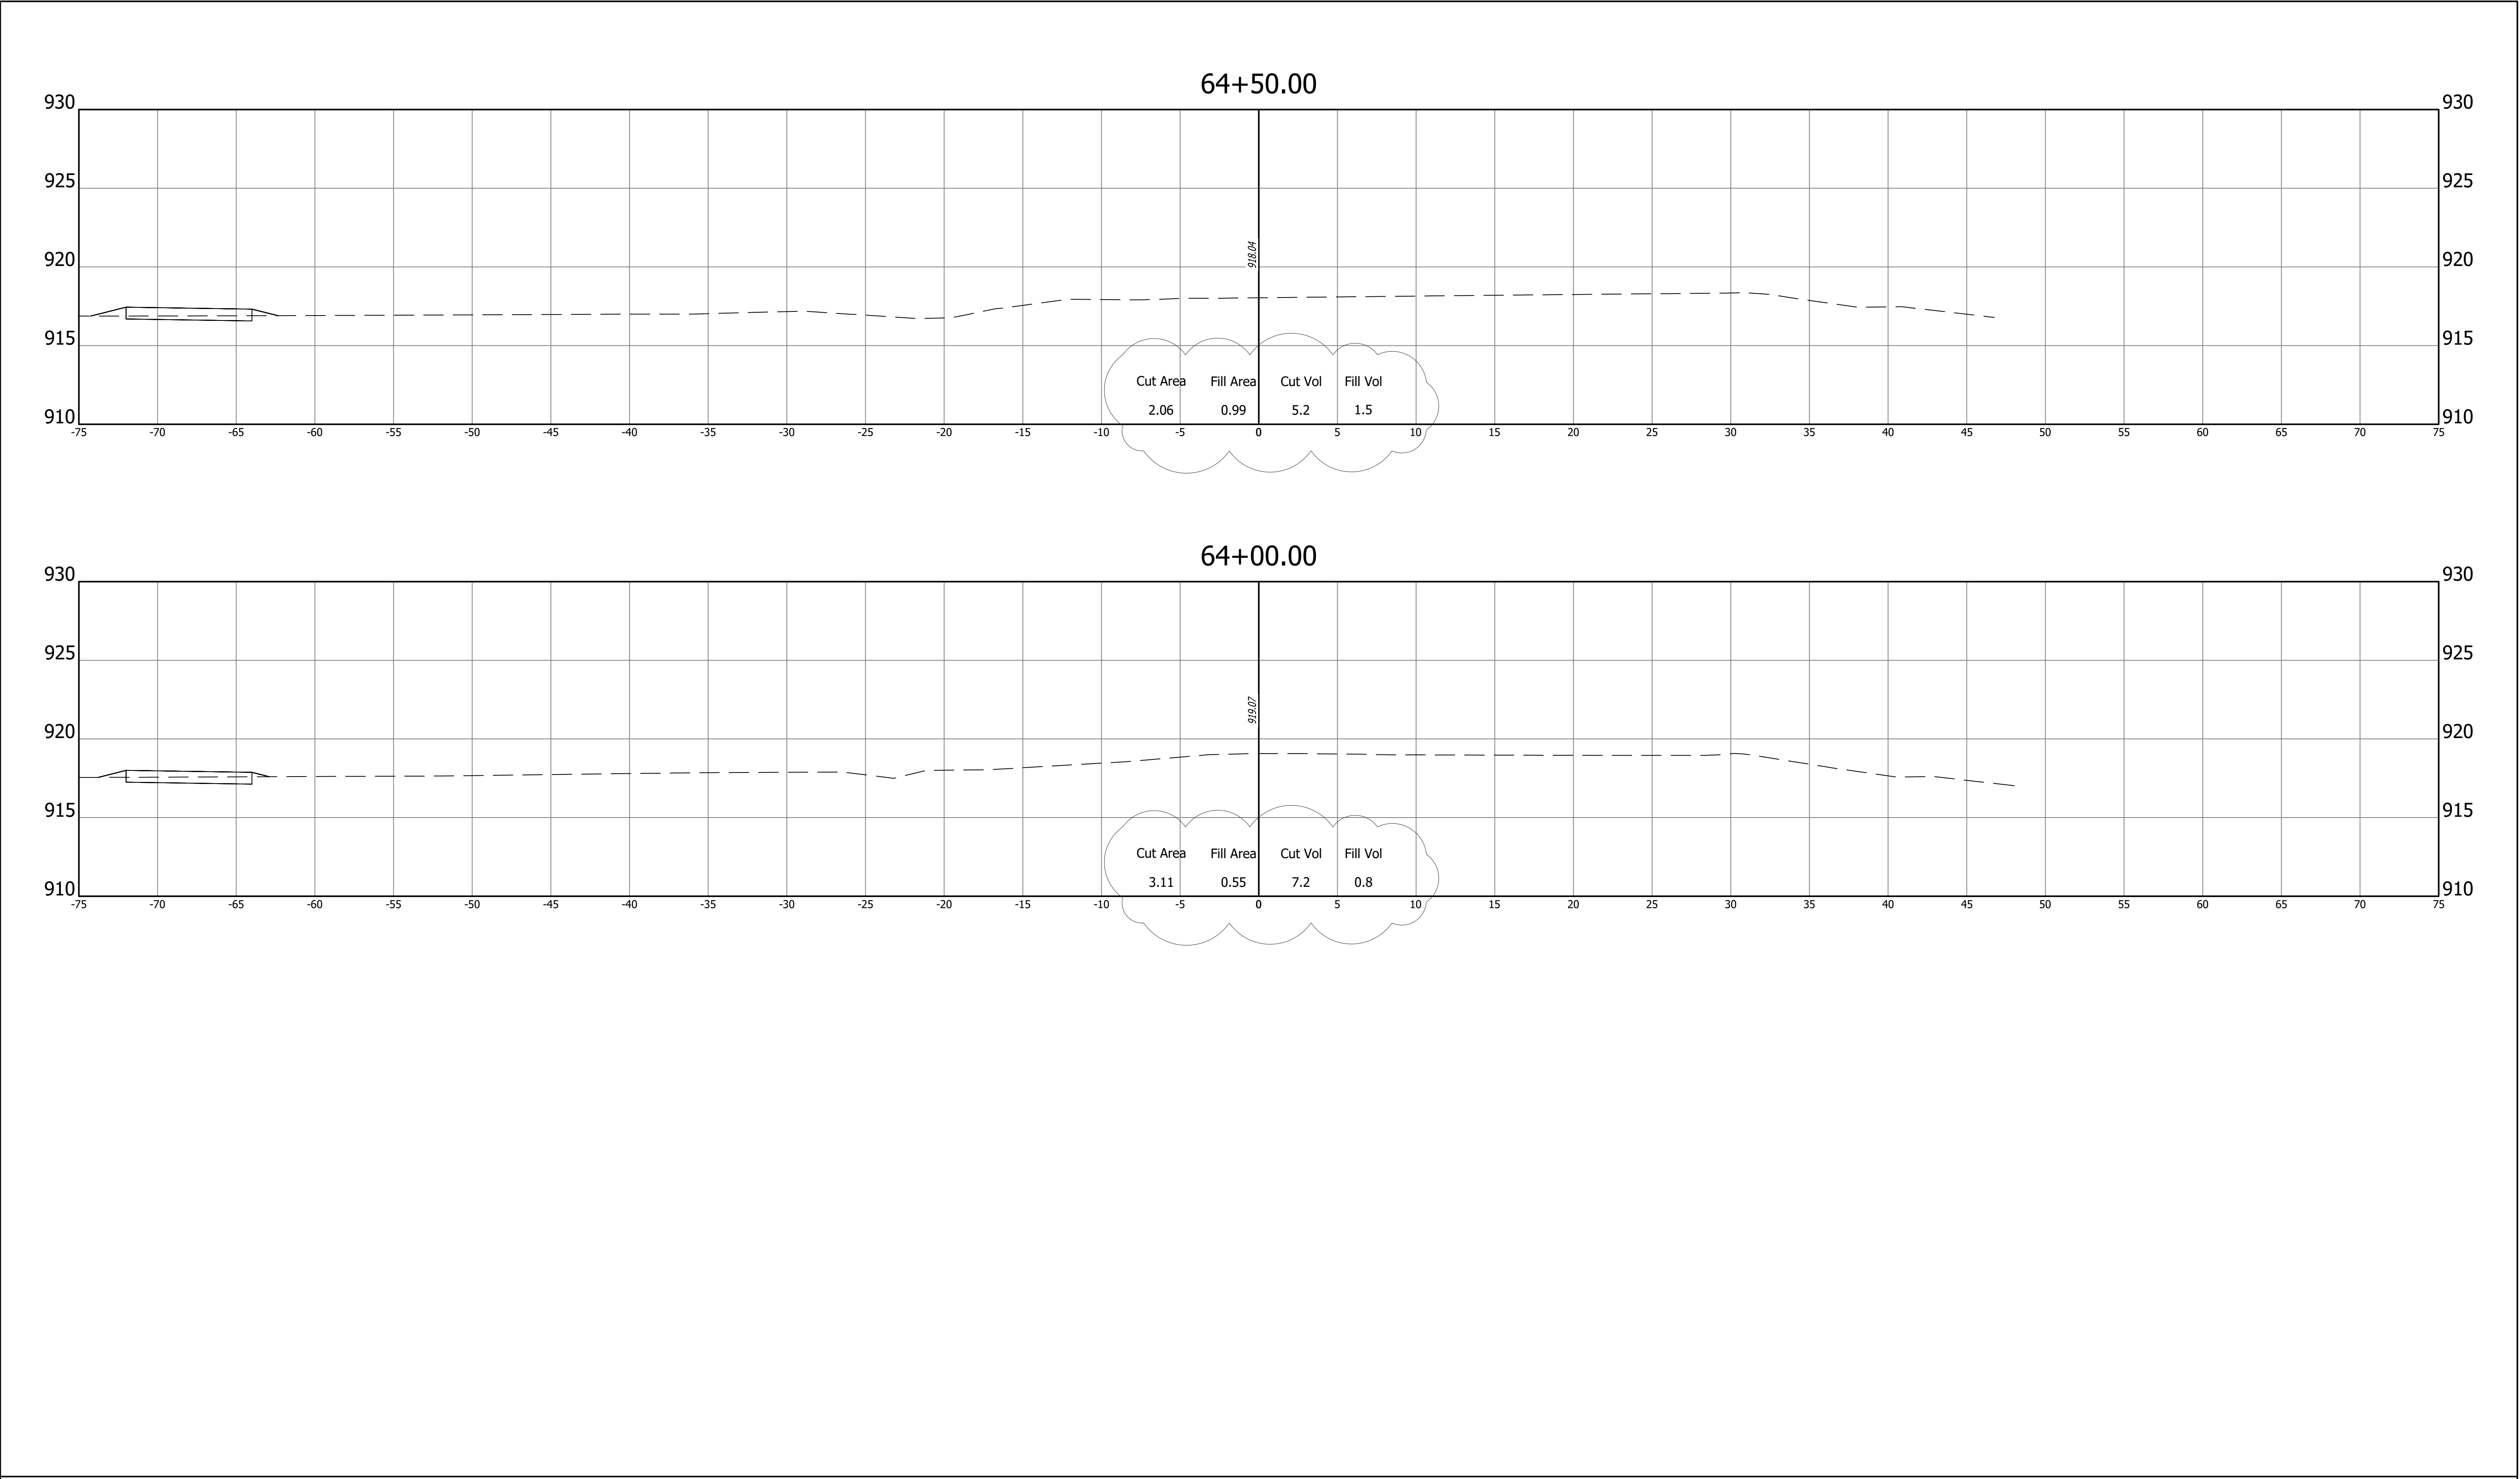

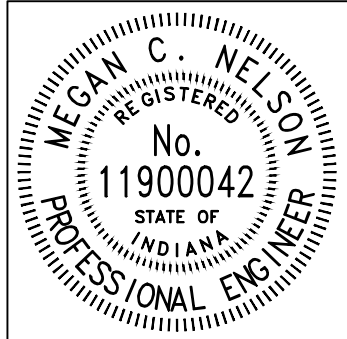REVISIONS		 A&F ENGINEERING Transportation & Site Engineering Creating Order Since 1966 8365 Keystone Crossing, Suite 201, Indianapolis, IN. 46240 (317) 202-0864		RECOMMENDED FOR APPROVAL  08/11/2025 DESIGN ENGINEER DATE		WESTFIELD WASHINGTON SCHOOLS		HORIZONTAL SCALE 1"=5'		BRIDGE FILE N/A	
DATE	ITEM							VERTICAL SCALE 1"=5'		DESIGNATION --	
Oct 2, 2025	Updated Earthwork										
				DESIGNED: MCN DRAWN: AJG		CROSS SECTIONS LINE "PR-A"		SHEETS			
				CHECKED: JAH CHECKED: JAH				41 of 48		CONTRACT	
								--			

Z:\2024\240787-CONTEXT DESIGN TRAFFIC SIGNAL SR 32-CENTENNIAL RD PHS 1.DWG\CENTENNIAL PLAN SET\240787-CORRIDOR CENTENNIAL.DWG

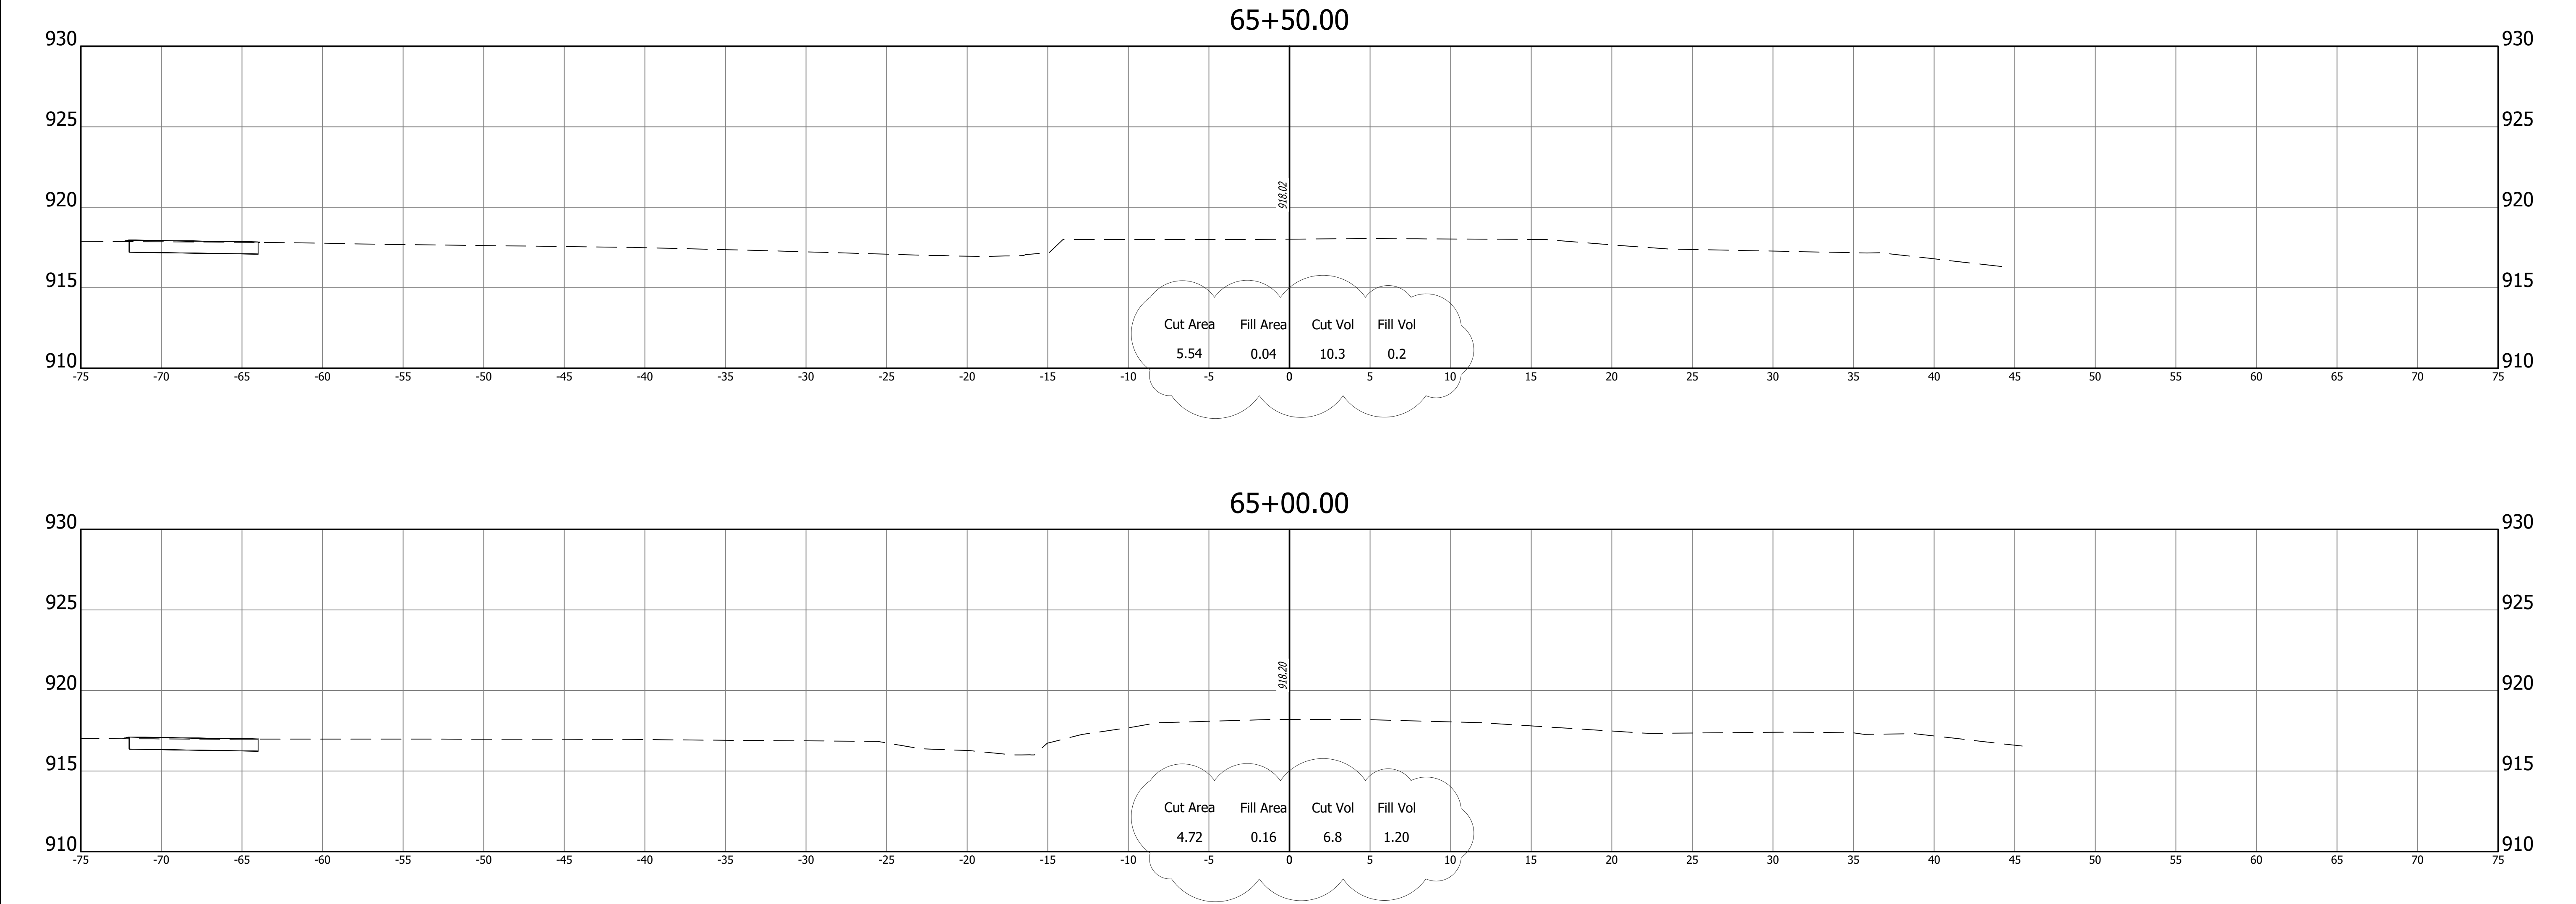

REVISIONS	
DATE	ITEM
Oct 2, 2025	Updated Earthwork




A&F ENGINEERING

Transportation & Site Engineering

Creating Order Since 1966

8365 Keystone Crossing, Suite 201, Indianapolis, IN. 46240 (317) 202-0864

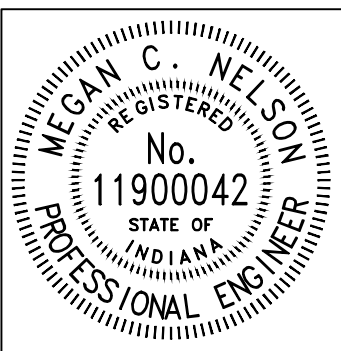

RECOMMENDED FOR APPROVAL



DESIGN ENGINEER

08/11/2025

DATE

DESIGNED:

MCN

DRAWN:

AJG

CHECKED:

JAH

CHECKED:


JAH

WESTFIELD WASHINGTON SCHOOLS

CROSS SECTIONS
LINE "PR-A"

HORIZONTAL SCALE		BRIDGE FILE	
1"=5'		N/A	
VERTICAL SCALE		DESIGNATION	
1"=5'		--	
		SHEETS	
		42	of 48
		CONTRACT	
		--	

Z:\2024\240787-CONTEXT DESIGN\TRAFFIC SIGNAL, SR 32-CENTENNIAL RD PH5 1DWG\CENTENNIAL PLAN SET\240787-CORRIDOR CENTENNIAL.DWG

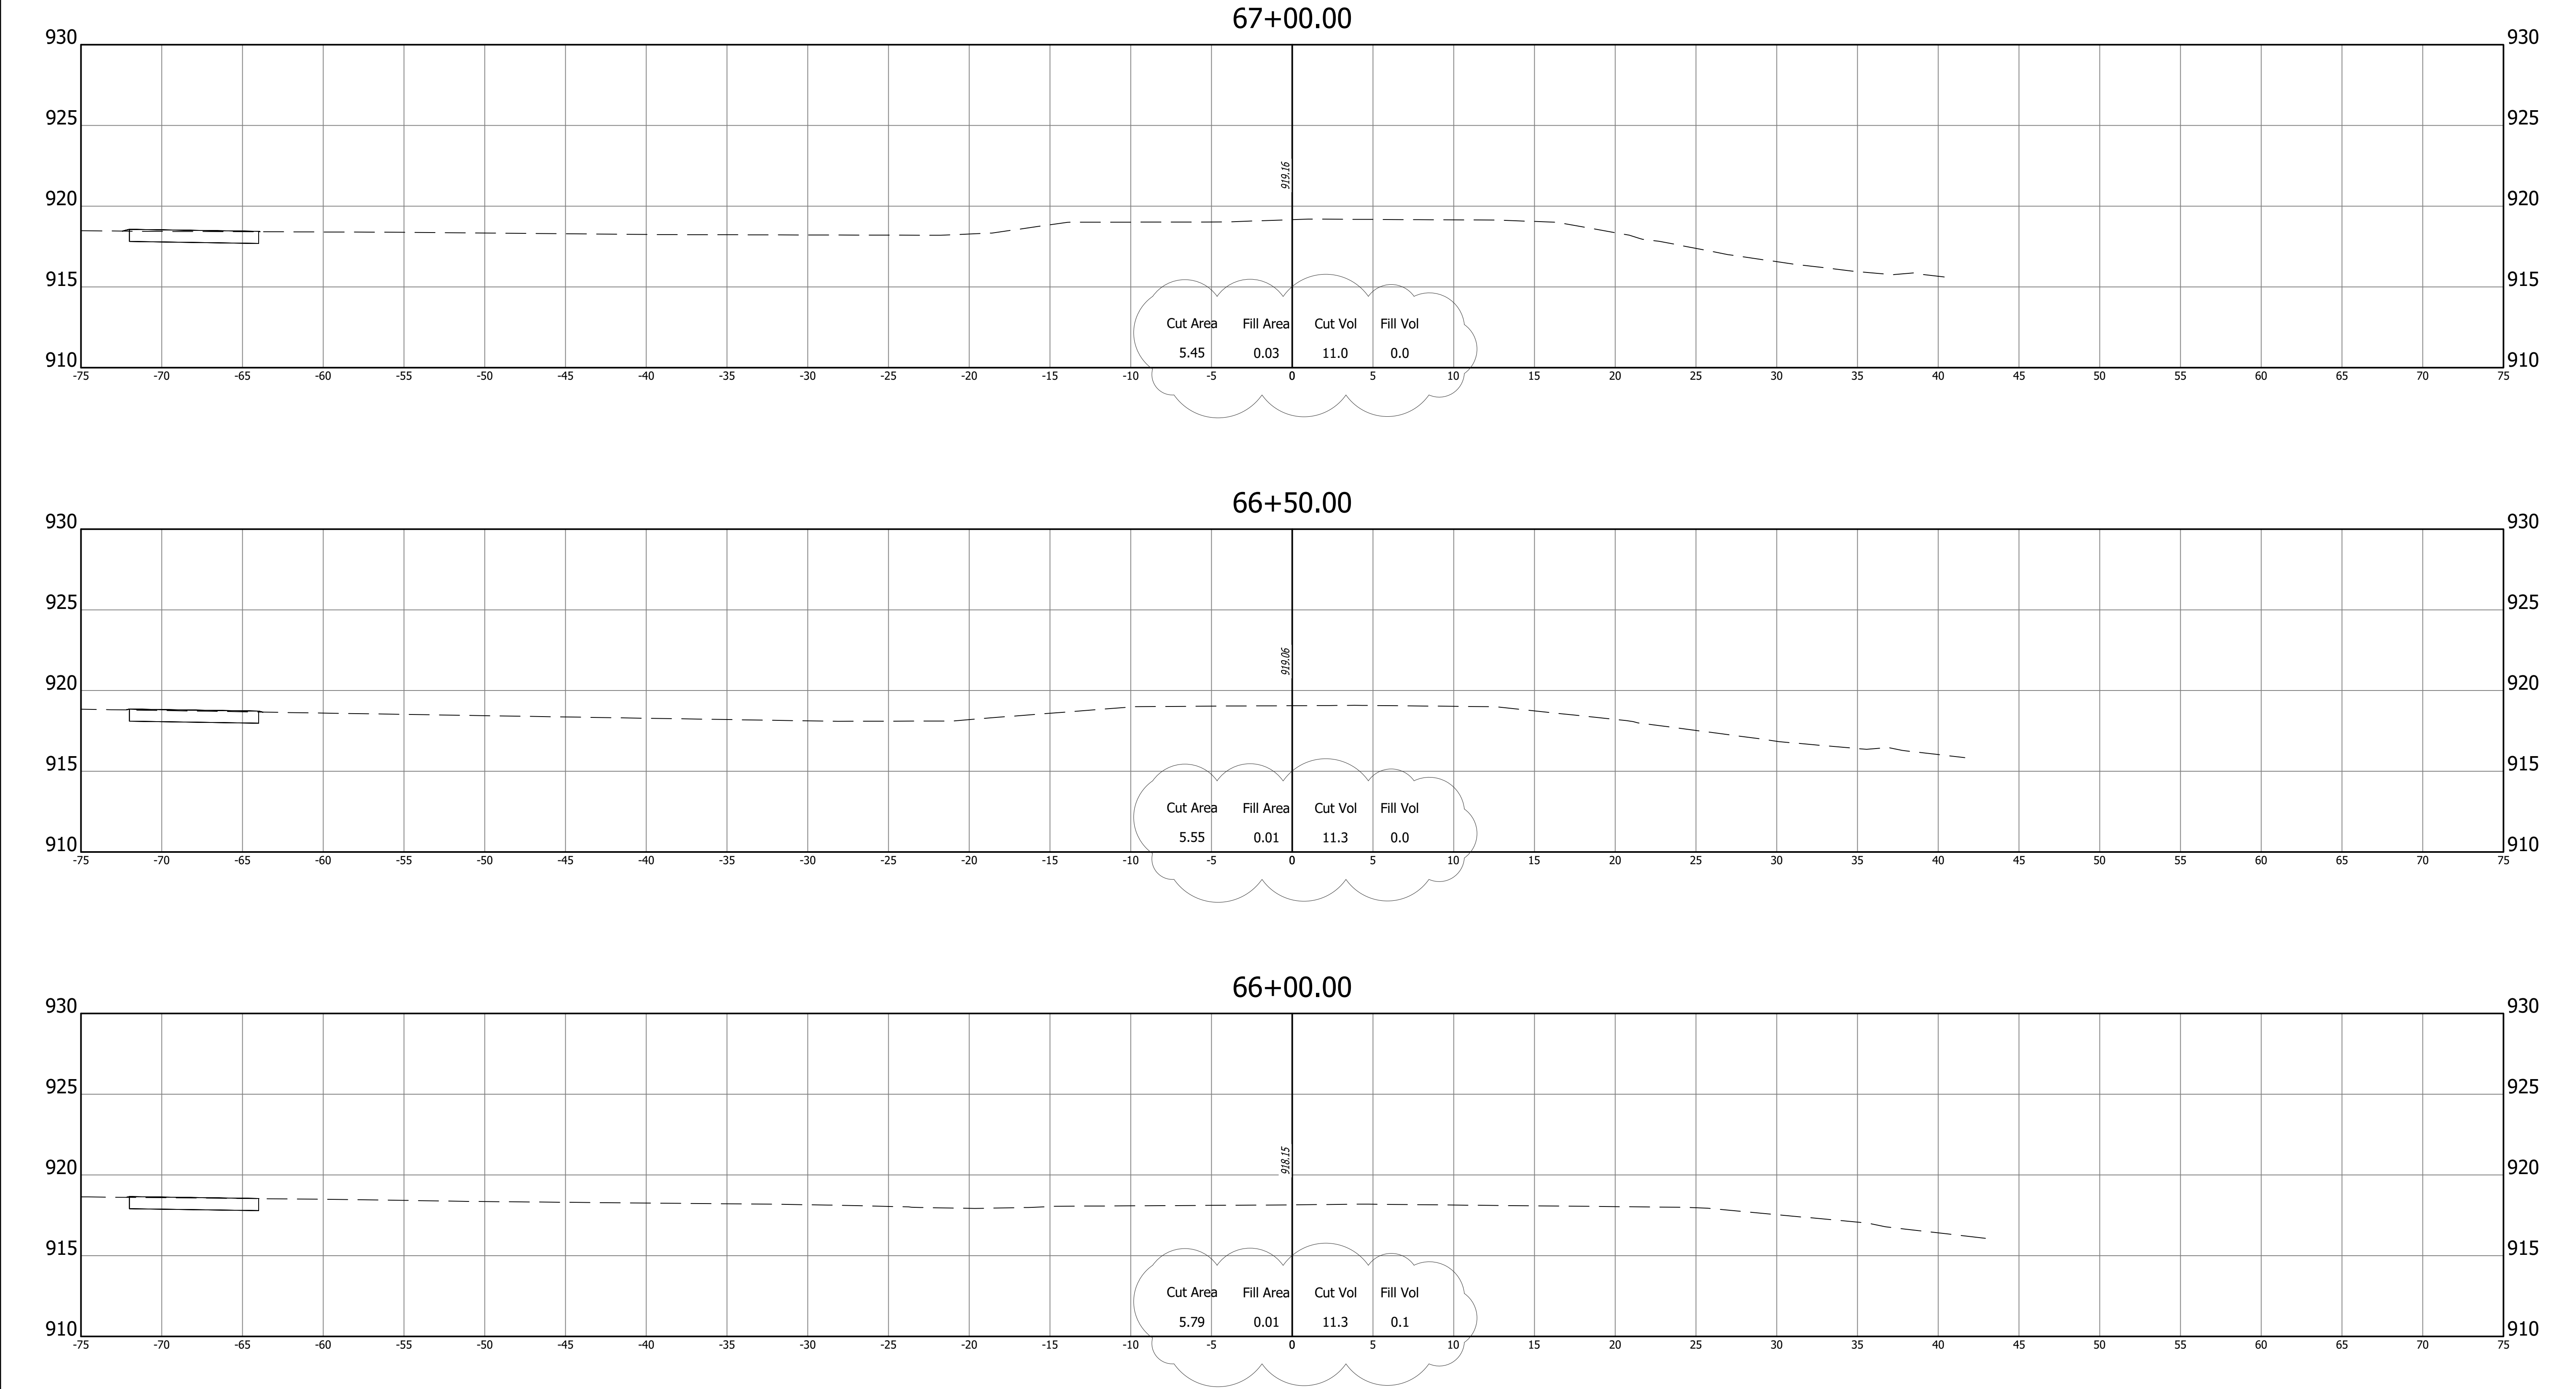


REVISIONS	
DATE	ITEM
Oct 2, 2025	Updated Earthwork



A&F ENGINEERING
Transportation & Site Engineering
Creating Order Since 1966

8365 Keystone Crossing, Suite 201, Indianapolis, IN. 46240 (317) 202-0864

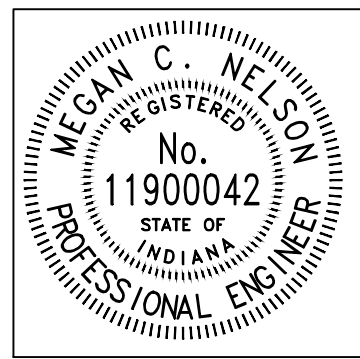


RECOMMENDED FOR APPROVAL		08/11/2025	
		DATE	
DESIGNED:	MCN	DRAWN:	AJG
CHECKED:	JAH	CHECKED:	JAH


WESTFIELD WASHINGTON SCHOOLS	
CROSS SECTIONS LINE "PR-A"	

HORIZONTAL SCALE 1"=5'	BRIDGE FILE N/A
VERTICAL SCALE 1"=5'	DESIGNATION --
SHEETS	
43	of 48
CONTRACT	
--	


Z:\2024\240787-CONTEXT DESIGN\TRAFFIC SIGNAL, SR 32-CENTENNIAL RD PH5 1D\DWG\CENTENNIAL PLAN SET\240787-CORRIDOR CENTENNIAL.DWG

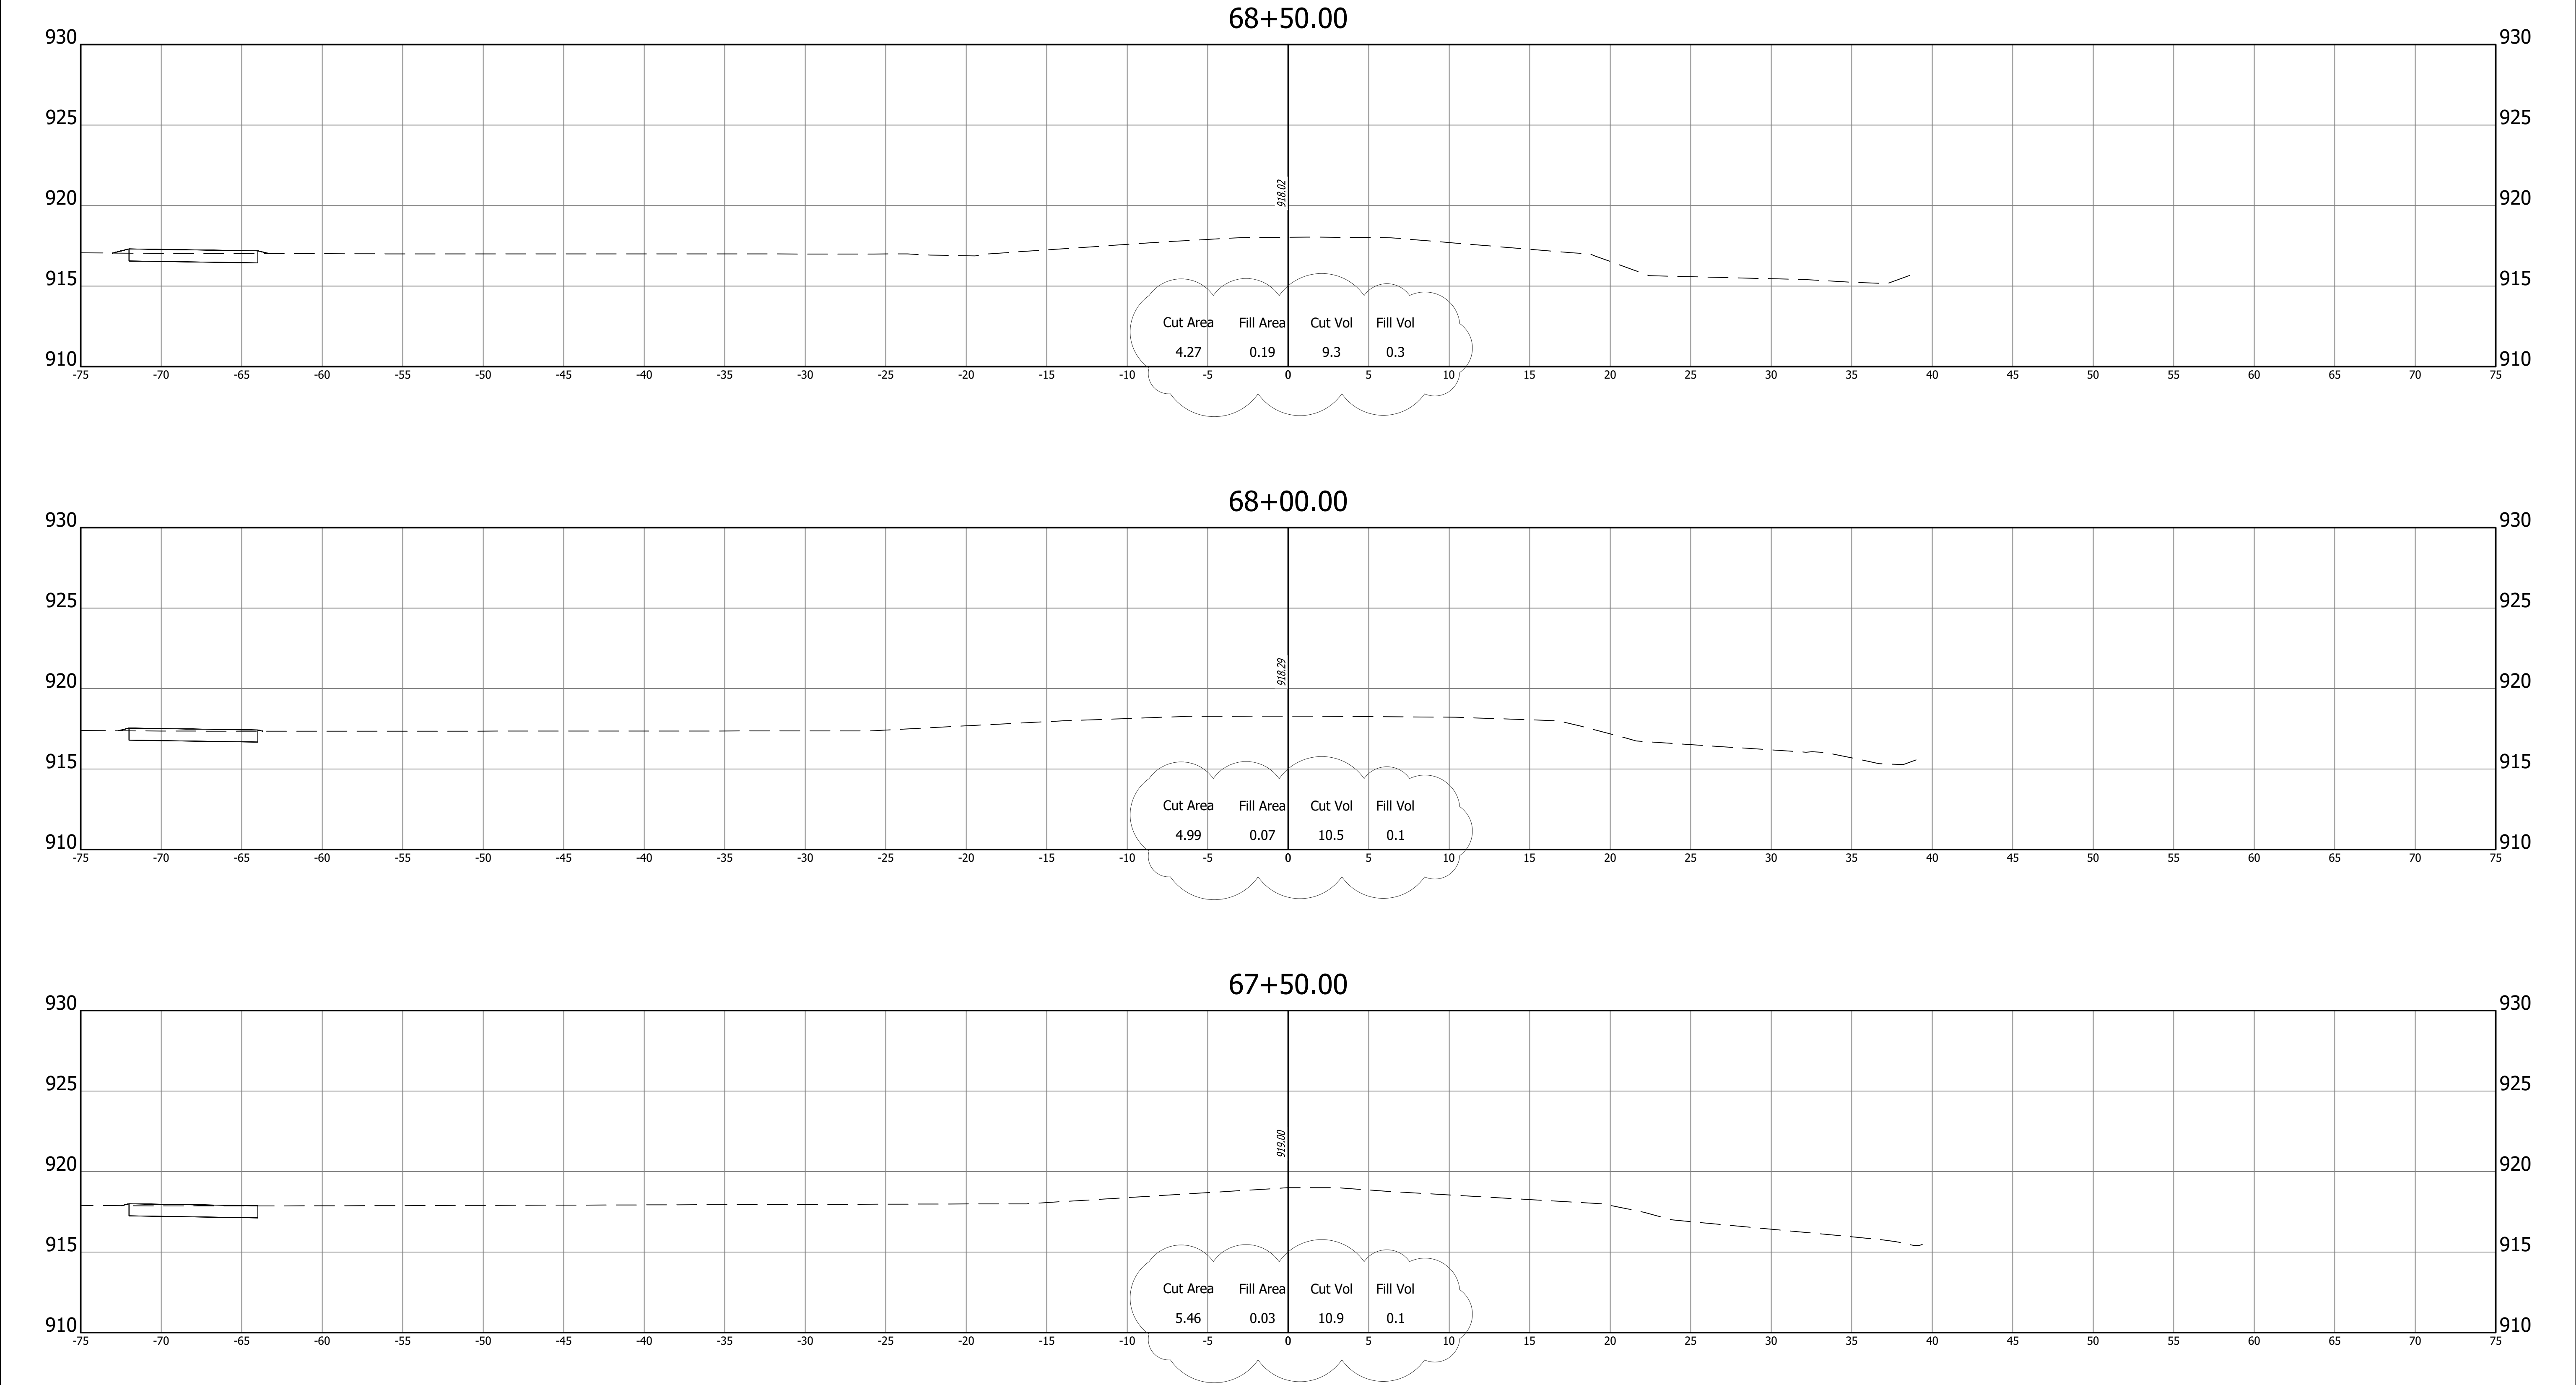

REVISIONS	
DATE	ITEM
Oct 2, 2025	Updated Earthwork

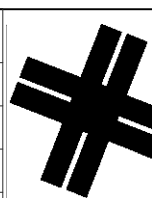

A&F ENGINEERING
Transportation & Site Engineering
Creating Order Since 1966
8365 Keystone Crossing, Suite 201, Indianapolis, IN. 46240 (317) 202-0864

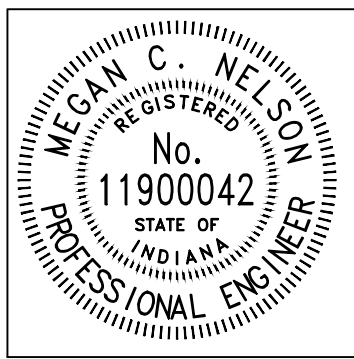


RECOMMENDED FOR APPROVAL		08/11/2025	
		DATE	
DESIGNED:	MCN	DRAWN:	AJG
CHECKED:	JAH	CHECKED:	JAH

WESTFIELD
WASHINGTON SCHOOLS


CROSS SECTIONS
LINE "PR-A"

HORIZONTAL SCALE	BRIDGE FILE		
1"=5'	N/A		
VERTICAL SCALE	DESIGNATION		
1"=5'	--		
	SHEETS		
	44	of	48
	CONTRACT		
	--		


Z:\2024\240787-CONTEXT DESIGN TRAFFIC SIGNAL, SR 32-CENTENNIAL RD PH5 1D.WG(CENTENNIAL PLAN SET)240787-CORRIDOR CENTENNIAL.DWG

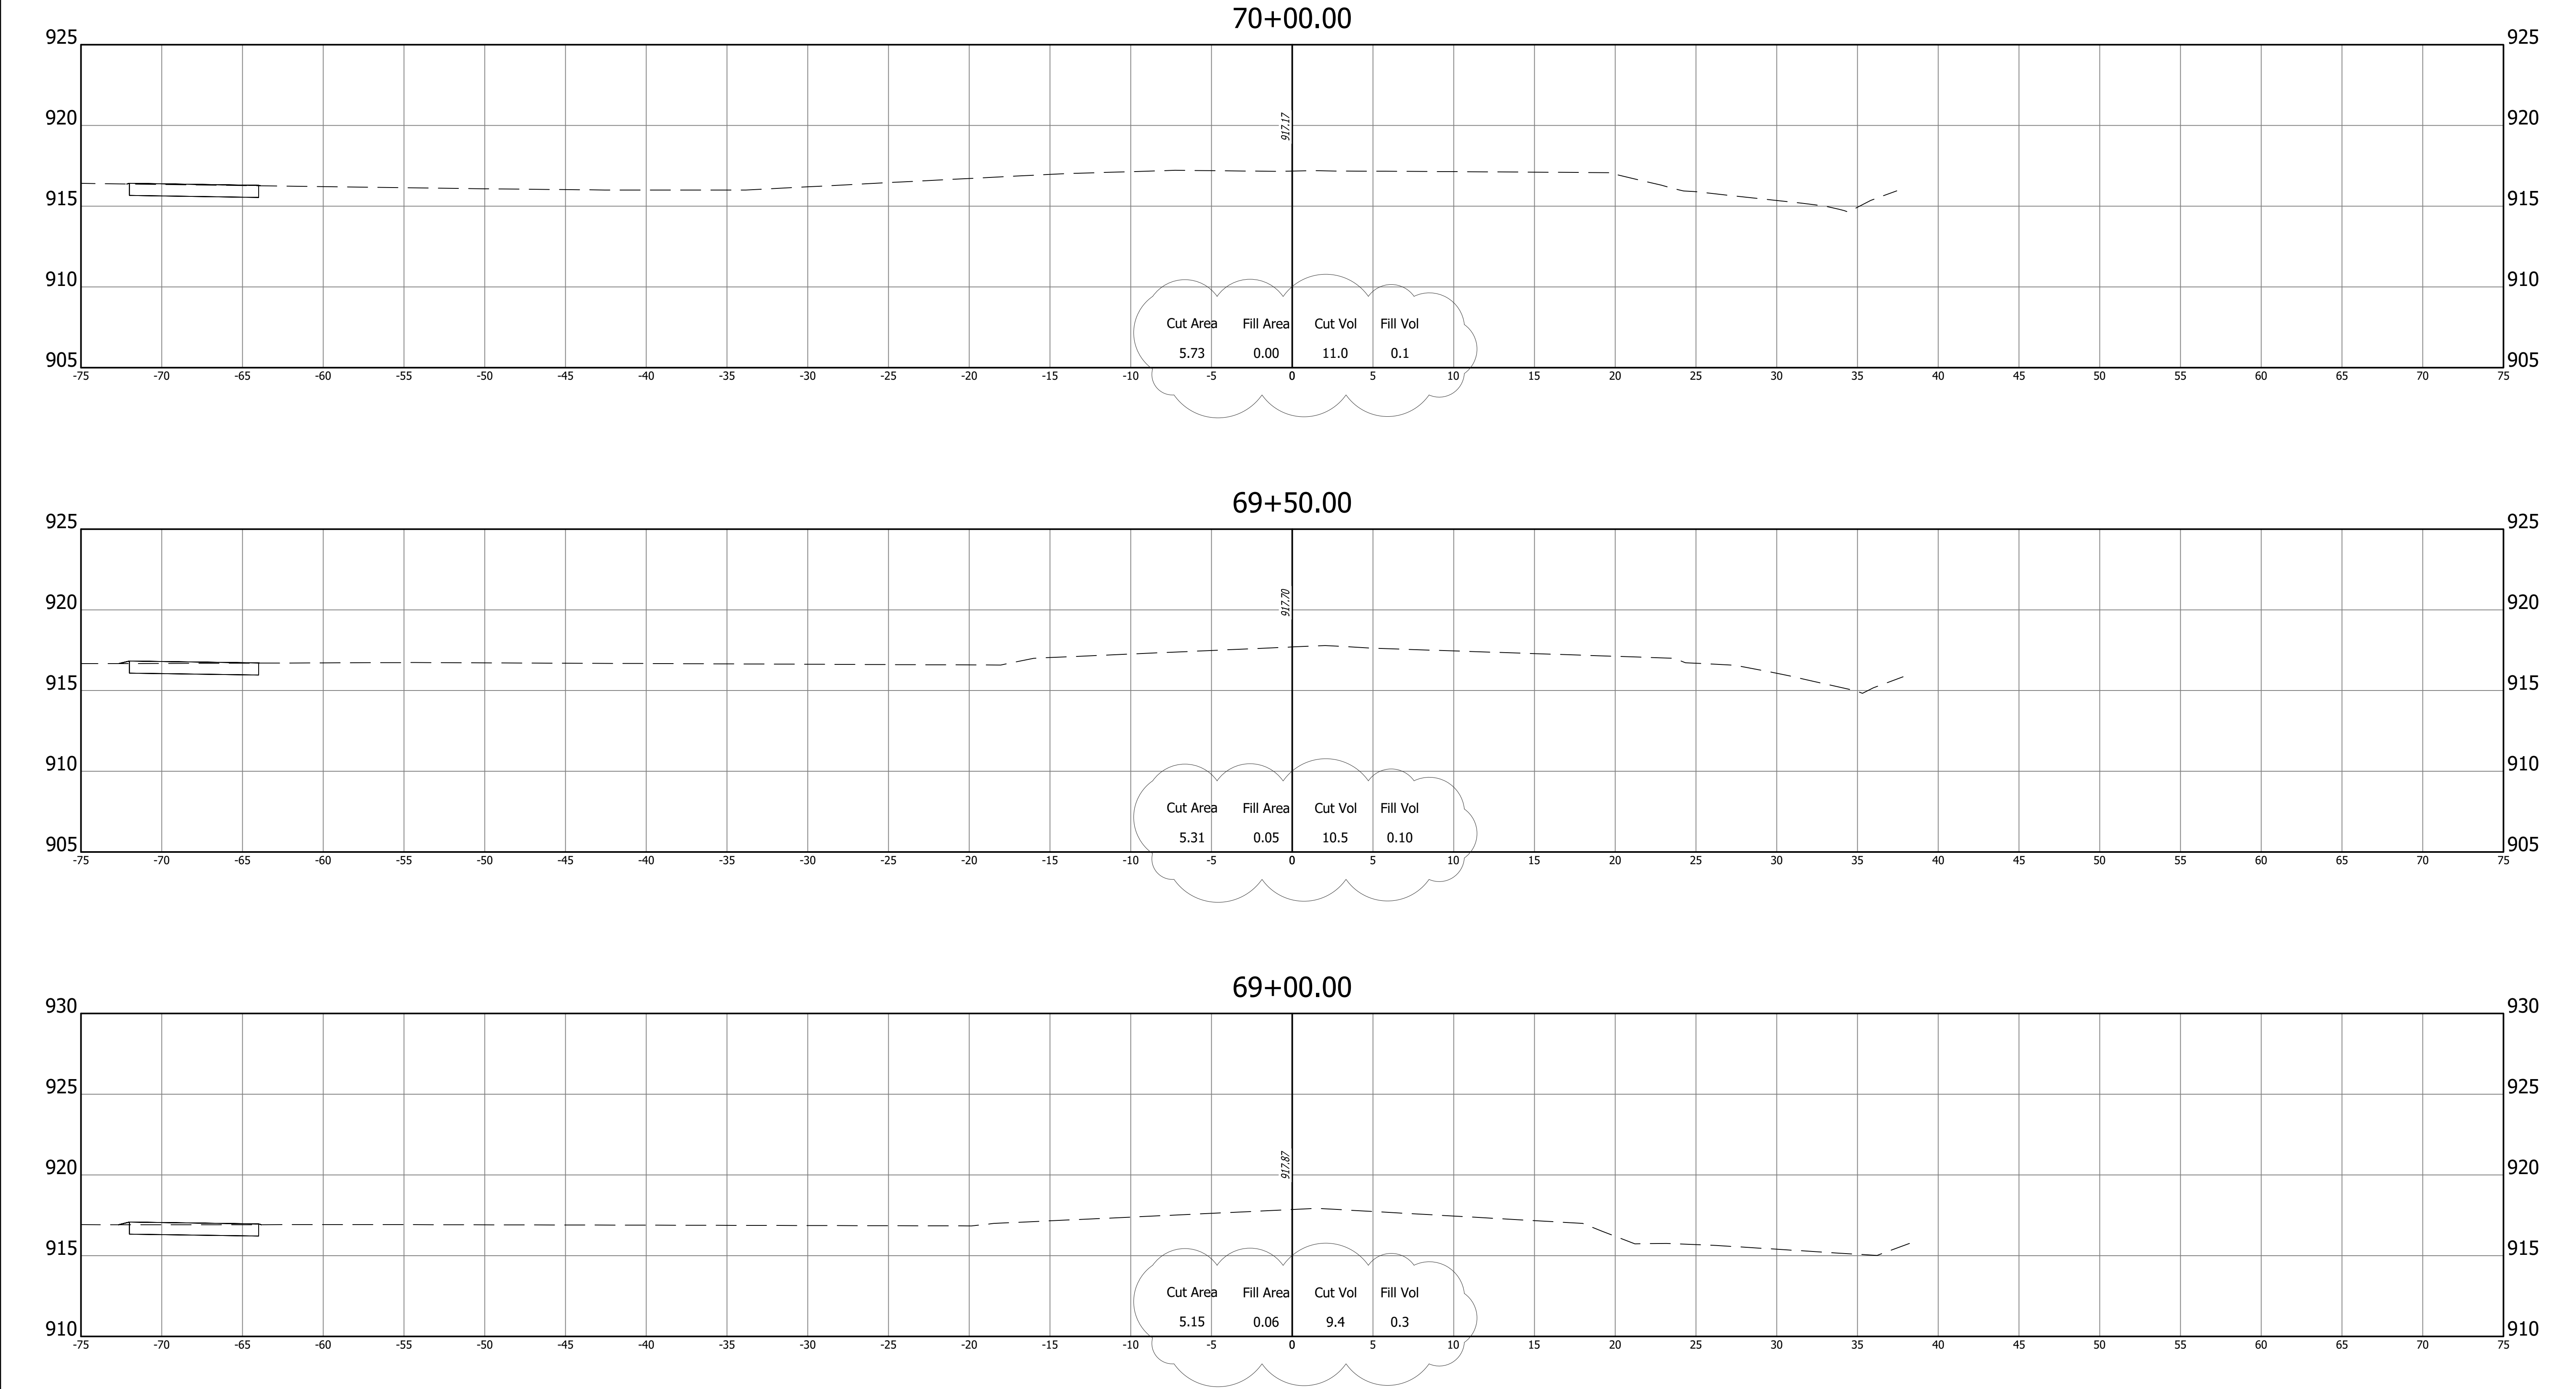

REVISIONS	
DATE	ITEM
Oct 2, 2025	Updated Earthwork

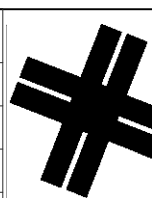

A&F ENGINEERING
Transportation & Site Engineering
Creating Order Since 1966
8365 Keystone Crossing, Suite 201, Indianapolis, IN. 46240 (317) 202-0864

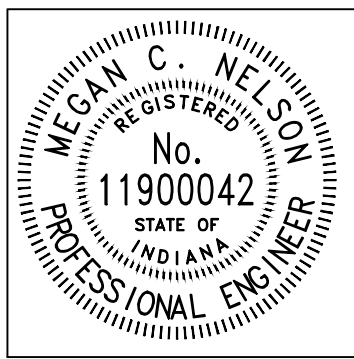


RECOMMENDED FOR APPROVAL		08/11/2025	
		DATE	
DESIGNED:	MCN	DRAWN:	AJG
CHECKED:	JAH	CHECKED:	JAH

WESTFIELD
WASHINGTON SCHOOLS


CROSS SECTIONS
LINE "PR-A"

HORIZONTAL SCALE 1"=5'	BRIDGE FILE N/A
VERTICAL SCALE 1"=5'	DESIGNATION --
SHEETS	
45	of 48
CONTRACT	
--	

Z:\2024\240787-CONTEXT DESIGN TRAFFIC SIGNAL, SR 32-CENTENNIAL RD PH5 1.DWG\CENTENNIAL PLAN SET\240787-CORRIDOR CENTENNIAL.DWG

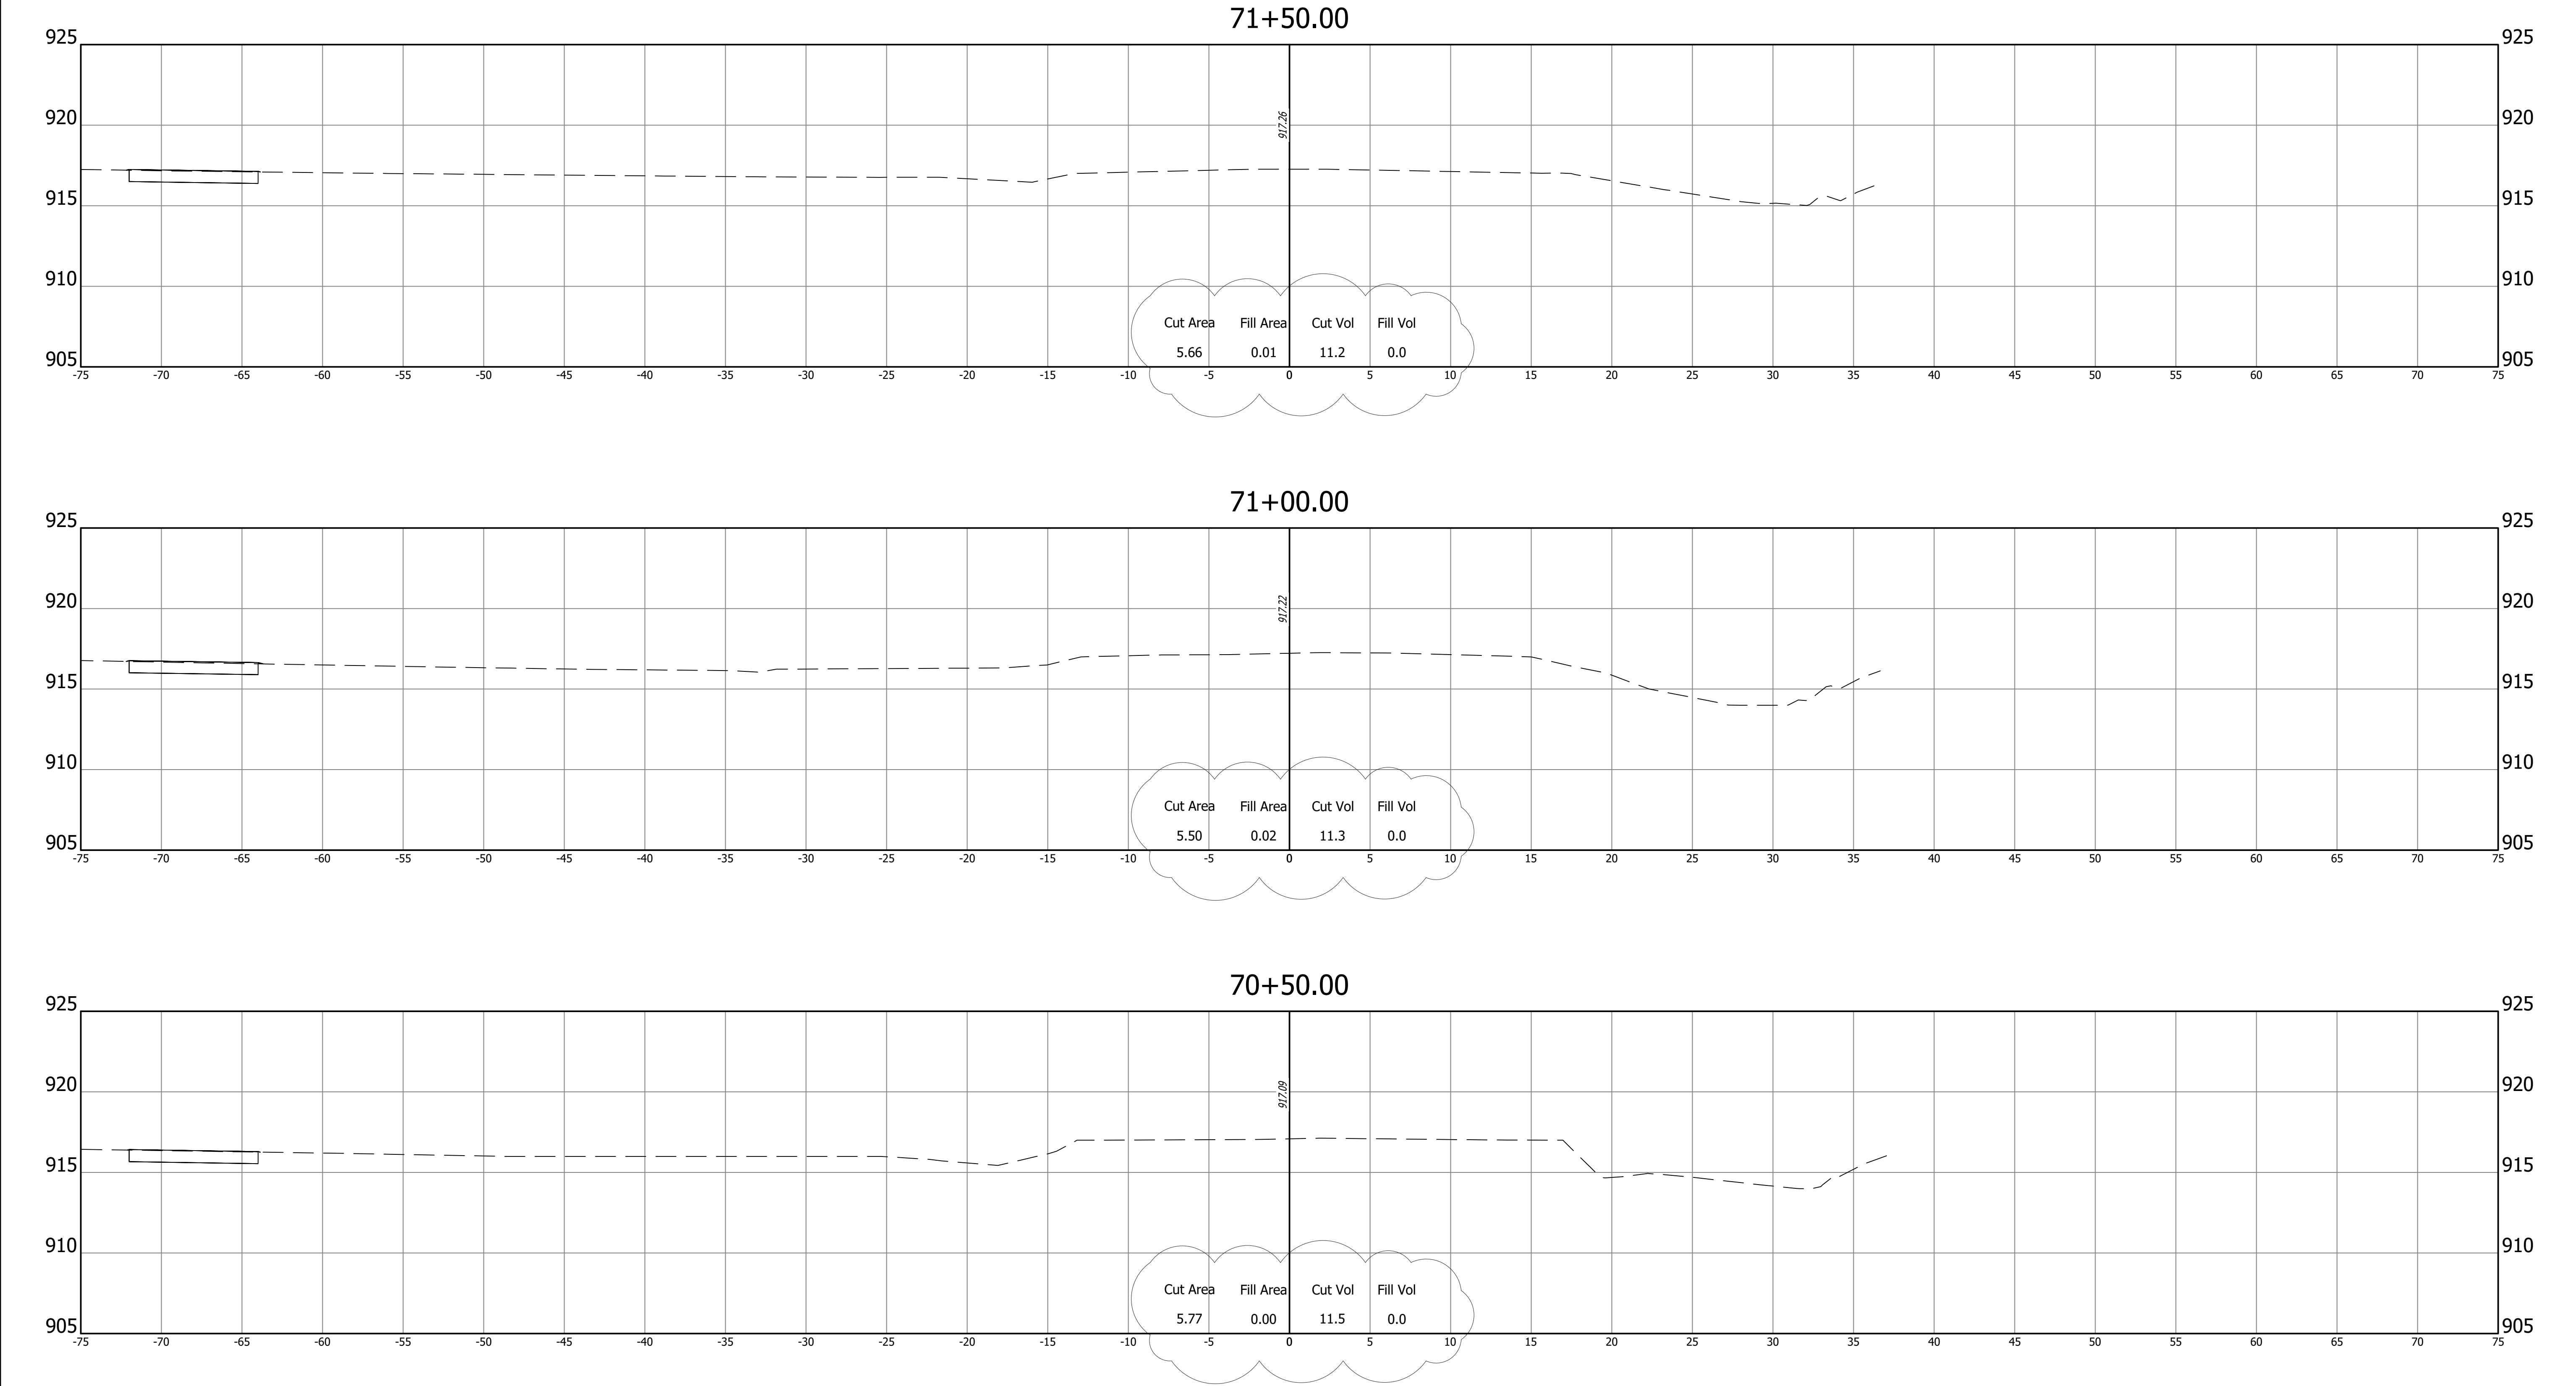

REVISIONS	
DATE	ITEM
Oct 2, 2025	Updated Earthwork

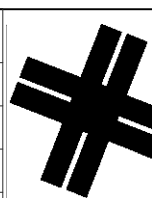


A&F ENGINEERING

Transportation & Site Engineering

Creating Order Since 1966

8365 Keystone Crossing, Suite 201, Indianapolis, IN. 46240 (317) 202-0864

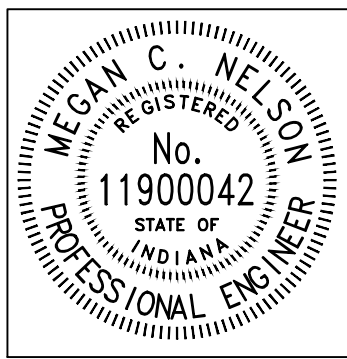


RECOMMENDED FOR APPROVAL		08/11/2025	
		DATE	
DESIGNED:	MCN	DRAWN:	AJG
CHECKED:	JAH	CHECKED:	JAH

WESTFIELD
WASHINGTON SCHOOLS

CROSS SECTIONS
LINE "PR-A"

HORIZONTAL SCALE 1"=5'	BRIDGE FILE N/A	
VERTICAL SCALE 1"=5'	DESIGNATION --	
	SHEETS	
	46	of 48
	CONTRACT	
	--	

Z:\2024\240787-CONTEXT DESIGN\TRAFFIC SIGNAL, SR 32-CENTENNIAL RD PH5 1\DWG\CENTENNIAL PLAN SET\240787-CORRIDOR CENTENNIAL.DWG

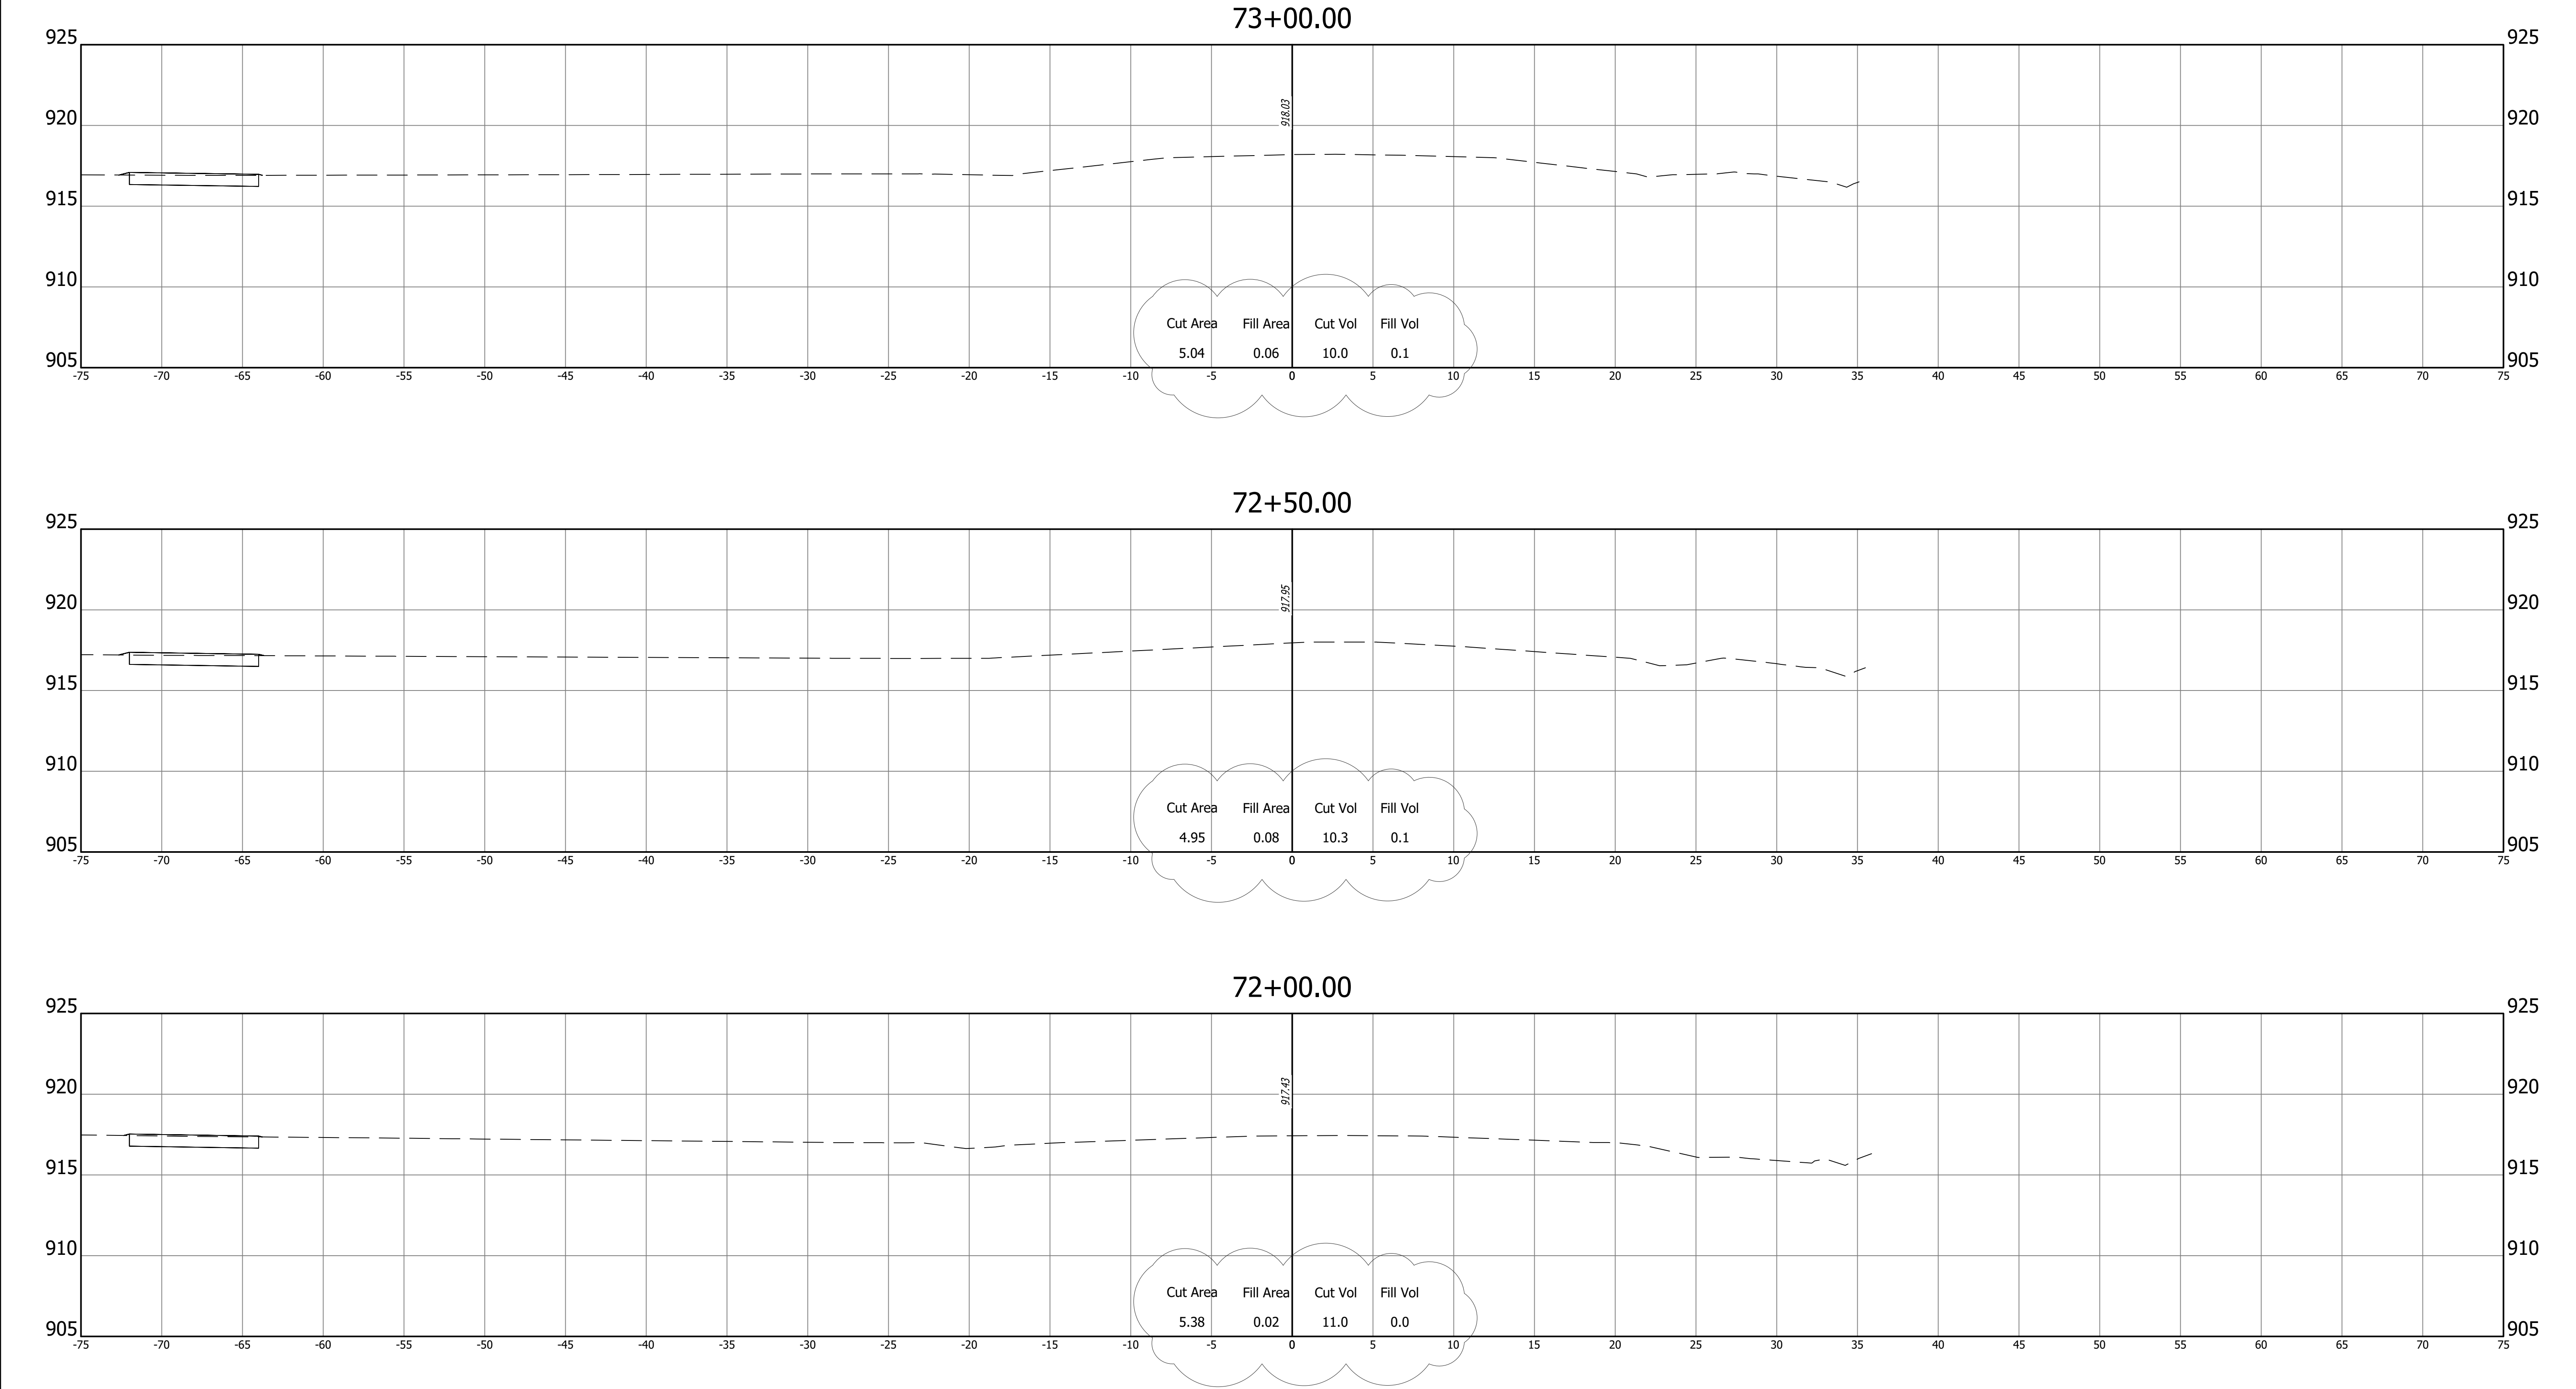


REVISIONS	
DATE	ITEM
Oct 2, 2025	Updated Earthwork

A&F ENGINEERING

Transportation & Site Engineering

Creating Order Since 1966

8365 Keystone Crossing, Suite 201, Indianapolis, IN. 46240 (317) 202-0864

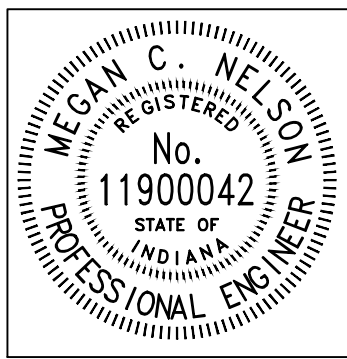



RECOMMENDED FOR APPROVAL		08/11/2025	
<i>Megan C. Nelson</i>		DATE	
DESIGNED: MCN		DRAWN: AJG	
CHECKED: JAH		CHECKED: JAH	

WESTFIELD
WASHINGTON SCHOOLS

CROSS SECTIONS
LINE "PR-A"

HORIZONTAL SCALE 1"=5'	BRIDGE FILE N/A	
VERTICAL SCALE 1"=5'	DESIGNATION --	
	SHEETS	
	47	of 48
	CONTRACT	
	--	

Z:\2024\24078T-CONTEXT DESIGN. TRAFFIC SIGNAL. SR 32-CENTENNIAL RD PHS 1\DWG\CENTENNIAL PLAN SET\24078T-CORRIDOR CENTENNIAL.DWG

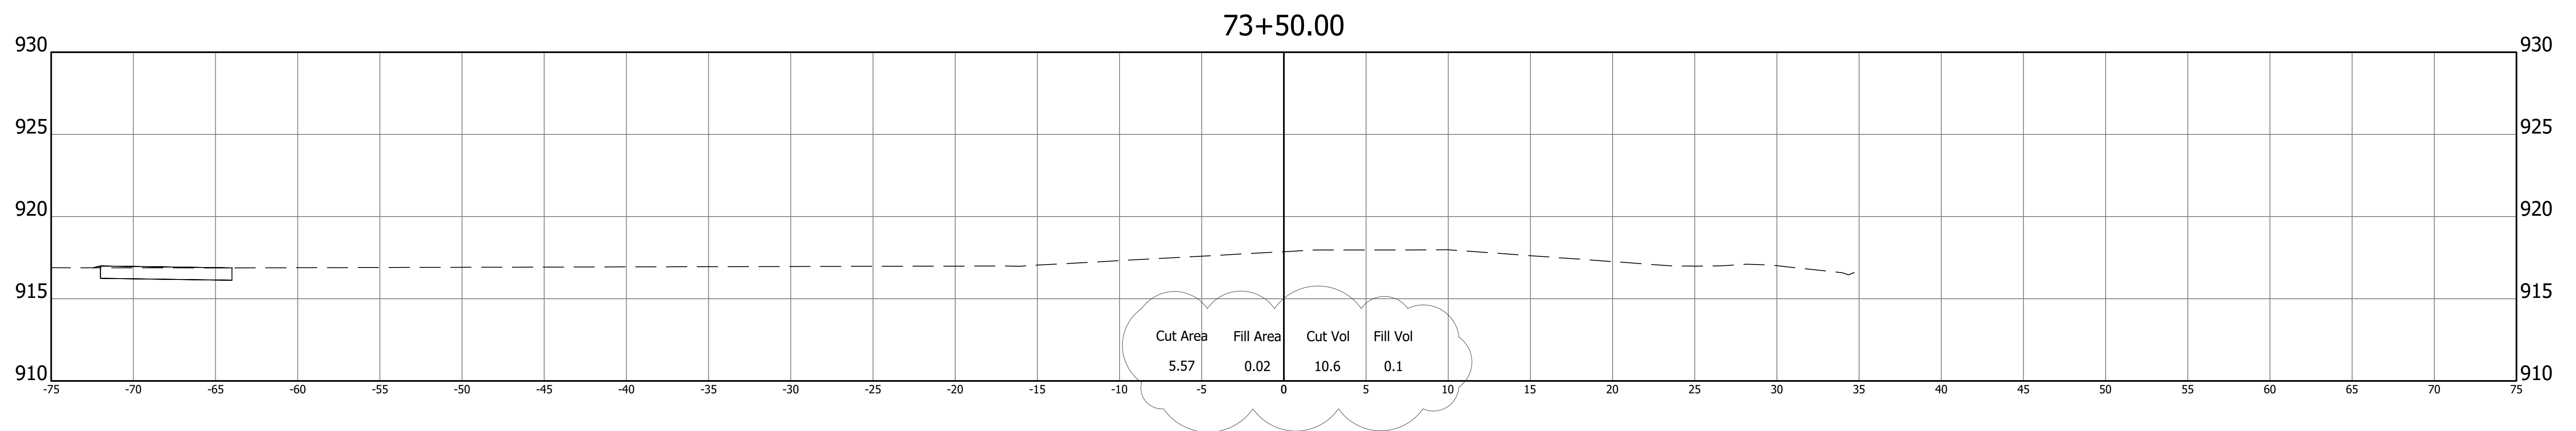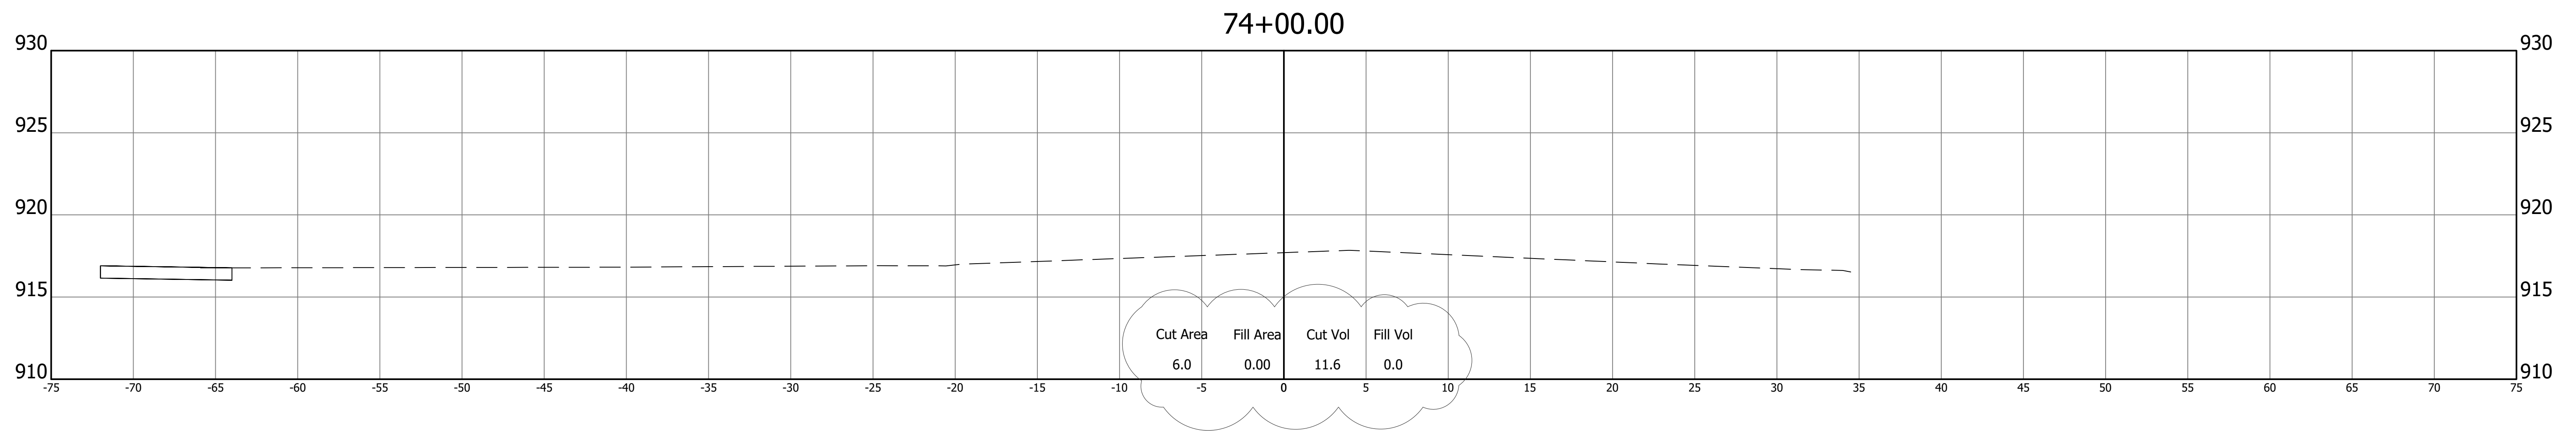

REVISIONS		A&F ENGINEERING Transportation & Site Engineering Creating Order Since 1966 8365 Keystone Crossing, Suite 201, Indianapolis, IN. 46240 (317) 202-0864	MEGAN C. NELSON REGISTERED No. 11900042 STATE OF INDIANA PROFESSIONAL ENGINEER	RECOMMENDED FOR APPROVAL Megan C. Nelson ENGINEER 08/11/2025 DATE		WESTFIELD WASHINGTON SCHOOLS		HORIZONTAL SCALE 1"=5'		BRIDGE FILE N/A	
DATE	ITEM			DESIGNED: MCN		DRAWN: AJG		VERTICAL SCALE 1"=5'		DESIGNATION --	
Oct 2, 2025	Updated Earthwork			CHECKED: JAH		CHECKED: JAH					
					CROSS SECTIONS LINE "PR-A"				SHEETS 48 of 48		
									CONTRACT --		



WESTFIELD WASHINGTON NEW MIDDLE SCHOOL WEST PROJECT
BID PACKAGE 05, BID ITEM 32 CENTENNIAL ROAD RECONSTRUCTION WORK
PRE-BID MEETING SIGN-IN SHEET
A&F ENGINEERING
HAGERMAN INC., CMc

Wednesday, October 1st, 2025 @ 11:00 AM
19500 Tomlinson Road, Westfield, IN 46074

PLEASE PRINT

Matt Alexander	Rieth-Riley	812-718-7594
SHAWN WALKER	MILESTONE	765-652-2900
Matt Schaaf	Crider+Crider	317-414-5816
Lynette Hart	CSO	
Kelly Kottlowski	CSO	
JEFF HILL	A&F ENGINEERING	317-202-0864
Megan Nelson	A&F Engineering	317-202-0864
BRIAN KELLY	HWS	317-719-2545
Greg Hunt	WWS	(219) 851-8387
Mike Holtkamp	Hagerman Inc	
Michael Uhrig	Hagerman	
Jeremy J. Hebenstreit	Hagerman	