

ADDENDUM NO. 1

**FORT WAYNE-ALLEN COUNTY AIRPORT AUTHORITY
FORT WAYNE INTERNATIONAL AIRPORT
SELF SERVE FUEL FARM**

In accordance with the FAA General Provisions, Subsection 20-15, Discrepancies and Omissions, the following revisions to the Plans and Specifications shall become a part of the Contract Documents and each bidder shall acknowledge receipt thereof on page ITEMIZED PROPOSAL P-3 of the Proposal Forms.

CONTRACT DRAWINGS:

ITEM 1: **REMOVE** in its entirety the following plan sheets and **REPLACE** with the Sheets attached within Attachment A: Sheets EP103 and EP503.

RESPONSE TO BIDDERS' QUESTIONS – 1

**FORT WAYNE-ALLEN COUNTY AIRPORT AUTHORITY
FORT WAYNE INTERNATIONAL AIRPORT
SELF SERVE FUEL FARM**

GENERAL

ITEM 1: Questions that have been submitted by interested parties, and the responses to those questions, in no specific order.

Question 1: Will the bidders need to carry the cost of the proposed transformer in their bid or will the transformer invoice from the City go direct to FWA?

Response to Question 1: Bidders will need to carry this cost in their bid under Allowance ALG-1.

Question 2: What is the anticipated construction start date?



Response to Question 2: June 17th, 2026

Question 3: Can I use the Drawings & project manual I had previously purchased for this re-bid?



Response to Question 3: Please use the updated project manual provided with the re-bid.

ATTACHMENT A

 
May 15, 2024 - 9:11am
 C:\Users\wbarley\OneDrive\Documents\Temp\AP\wshh_044\BL9.001.001_EP503.dwg

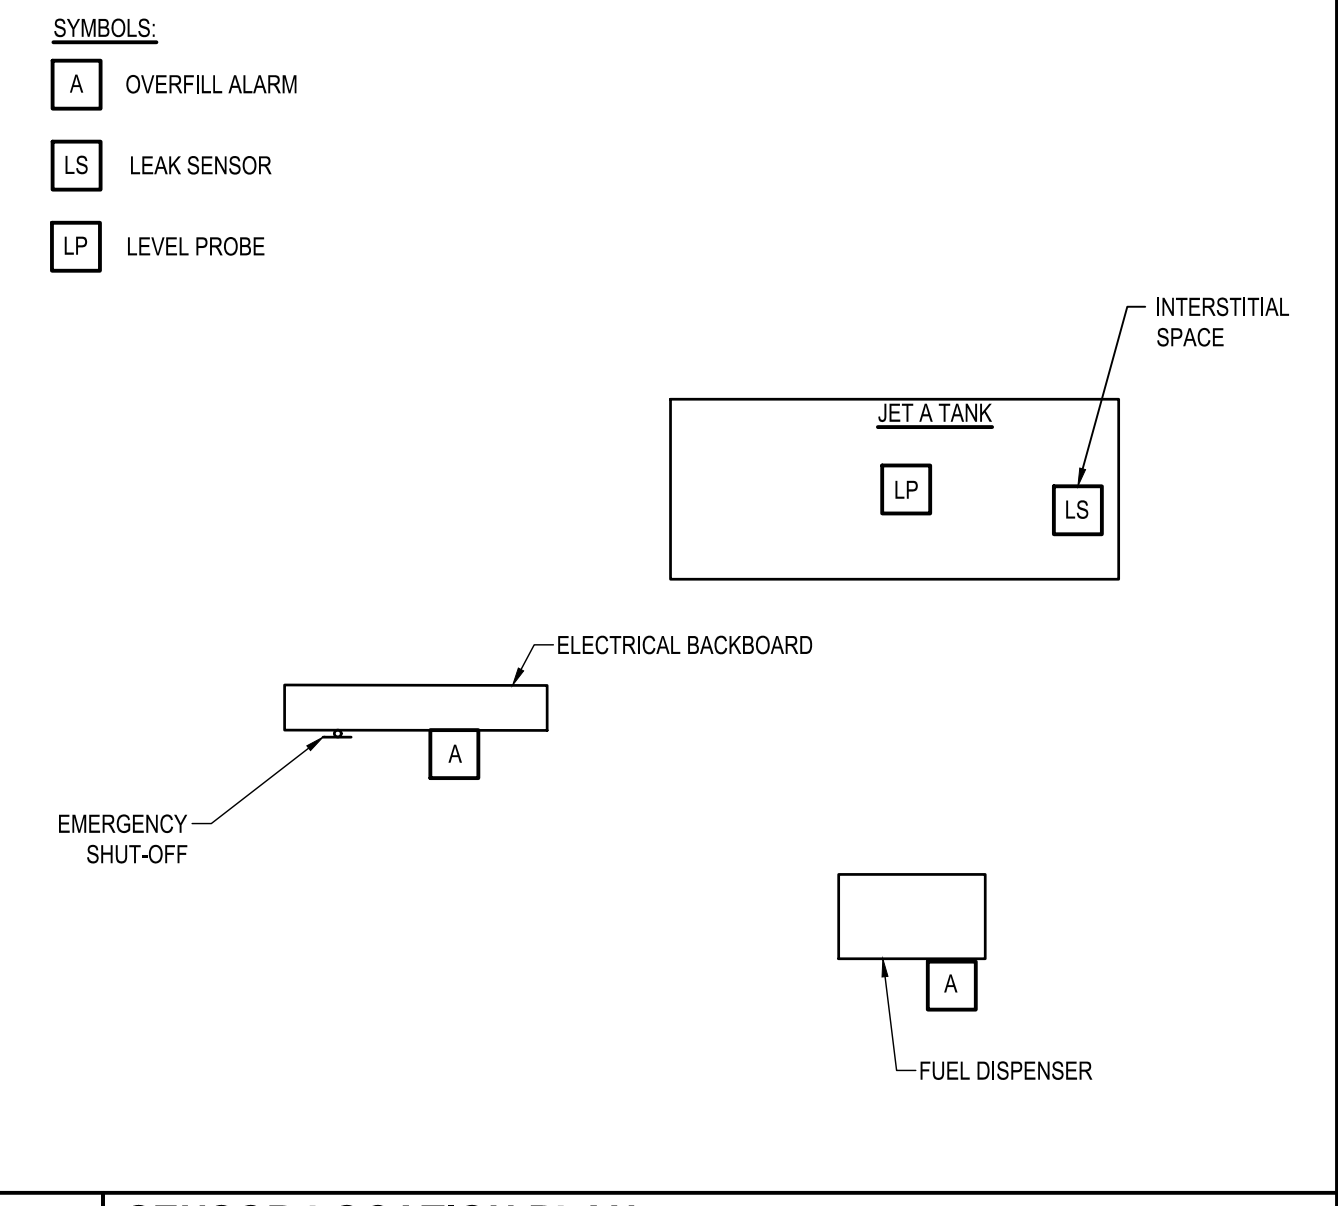

 
C4 SENSOR LOCATION PLAN
SCALE: 3/4" = 1'-0"

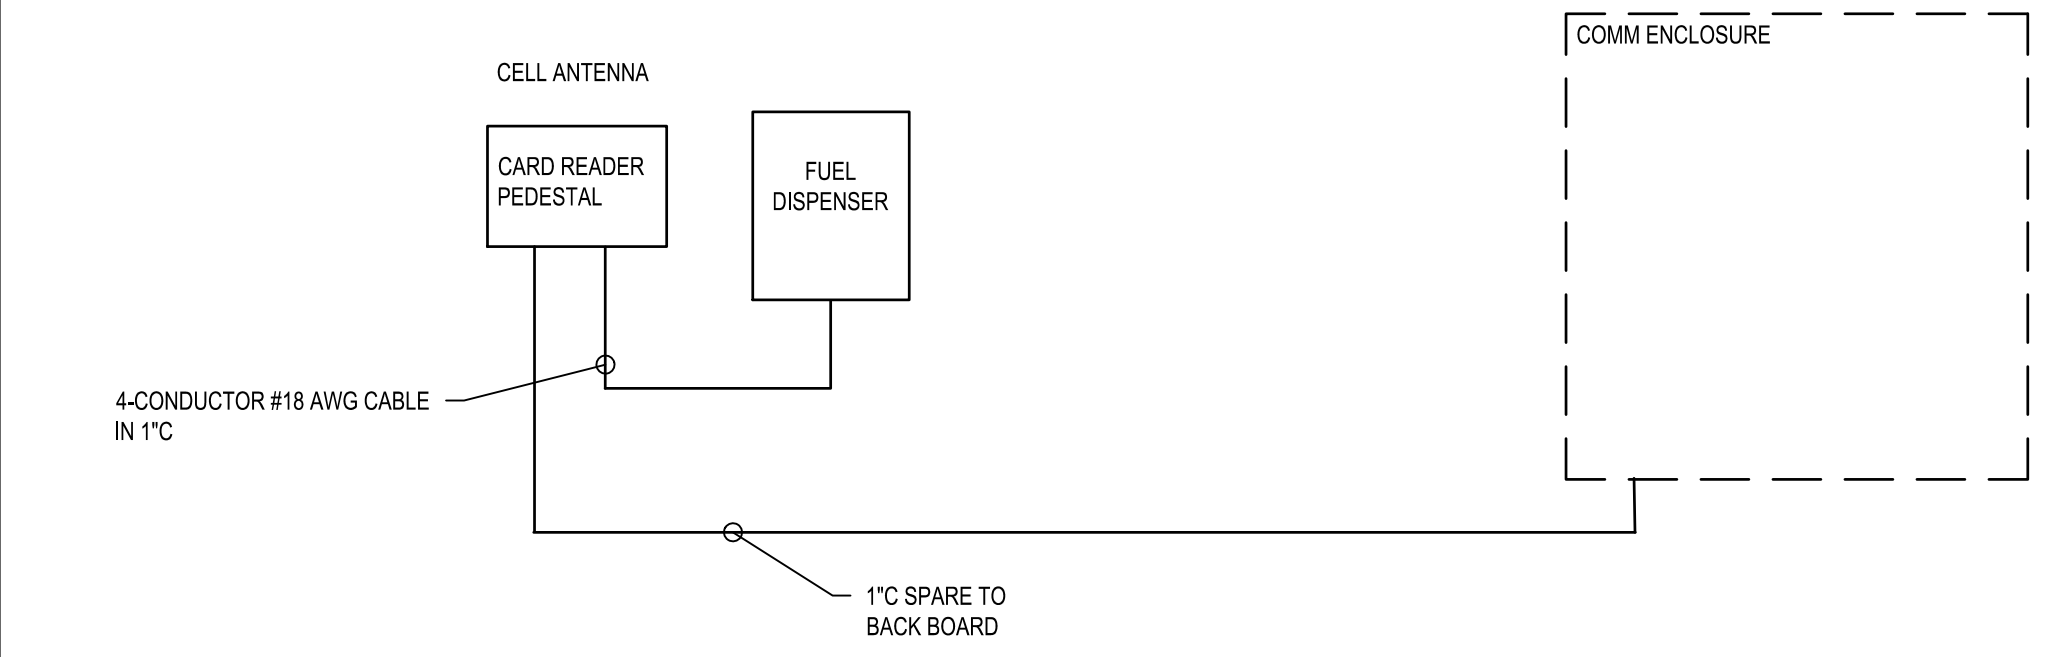


B3 FUEL MANAGEMENT SYSTEM ONE LINE
SCALE: NOT TO SCALE

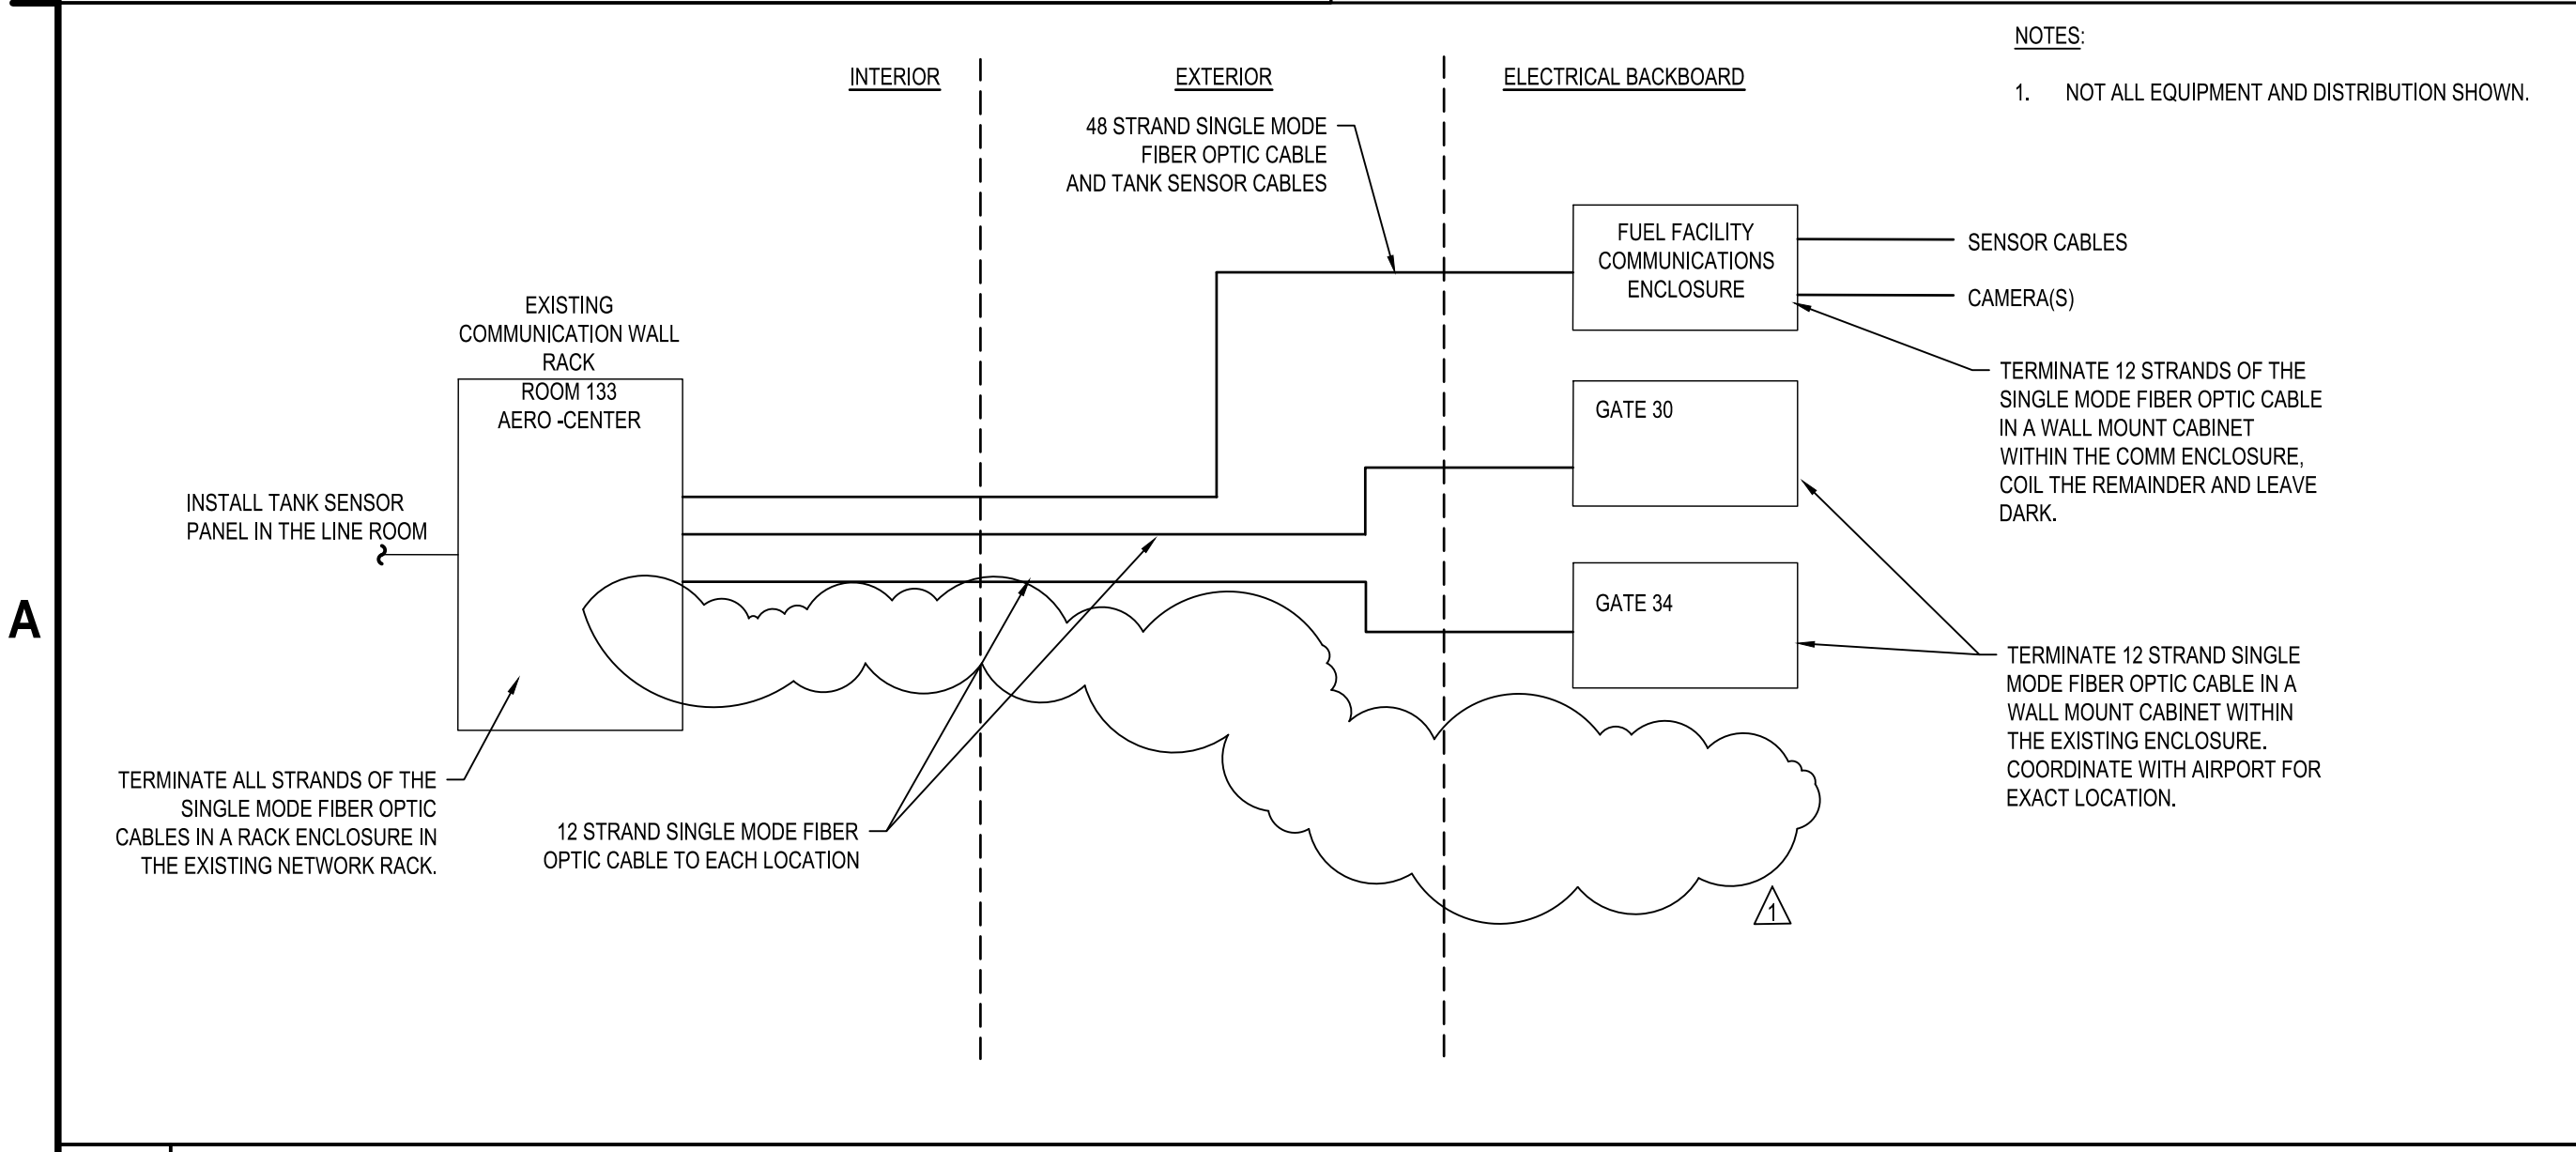

A1 PROPOSED COMMUNICATIONS ONE-LINE DIAGRAM
SCALE: NOT TO SCALE

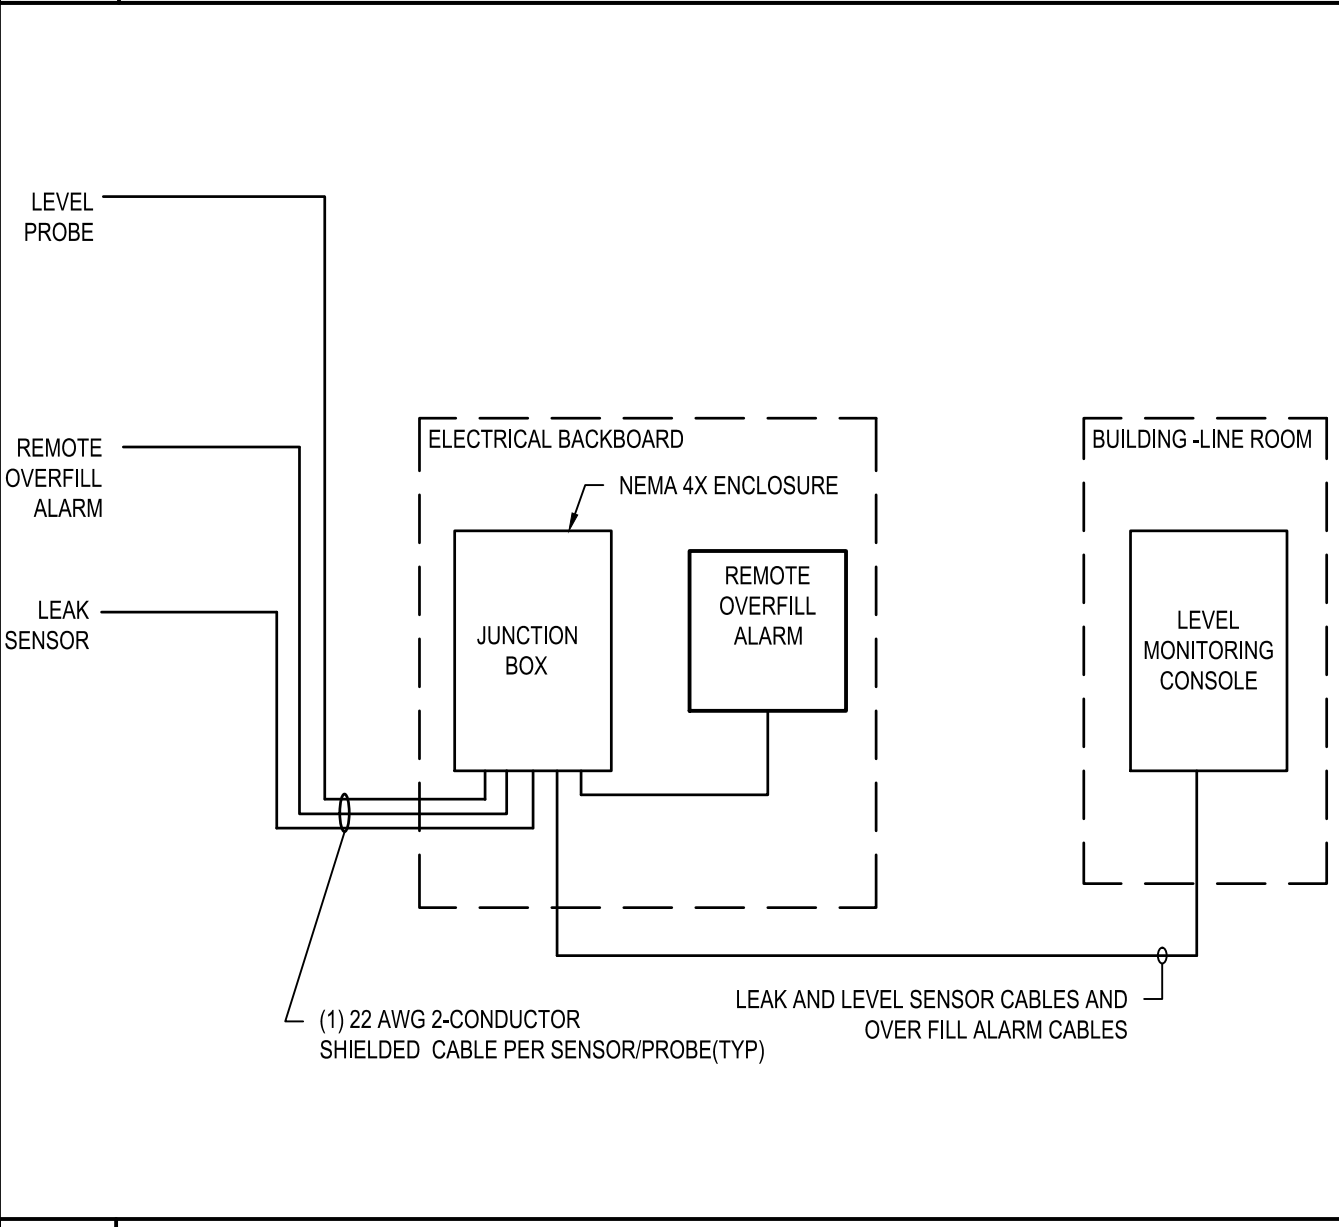


A3 SENSOR SYSTEM ONE LINE
SCALE: NOT TO SCALE

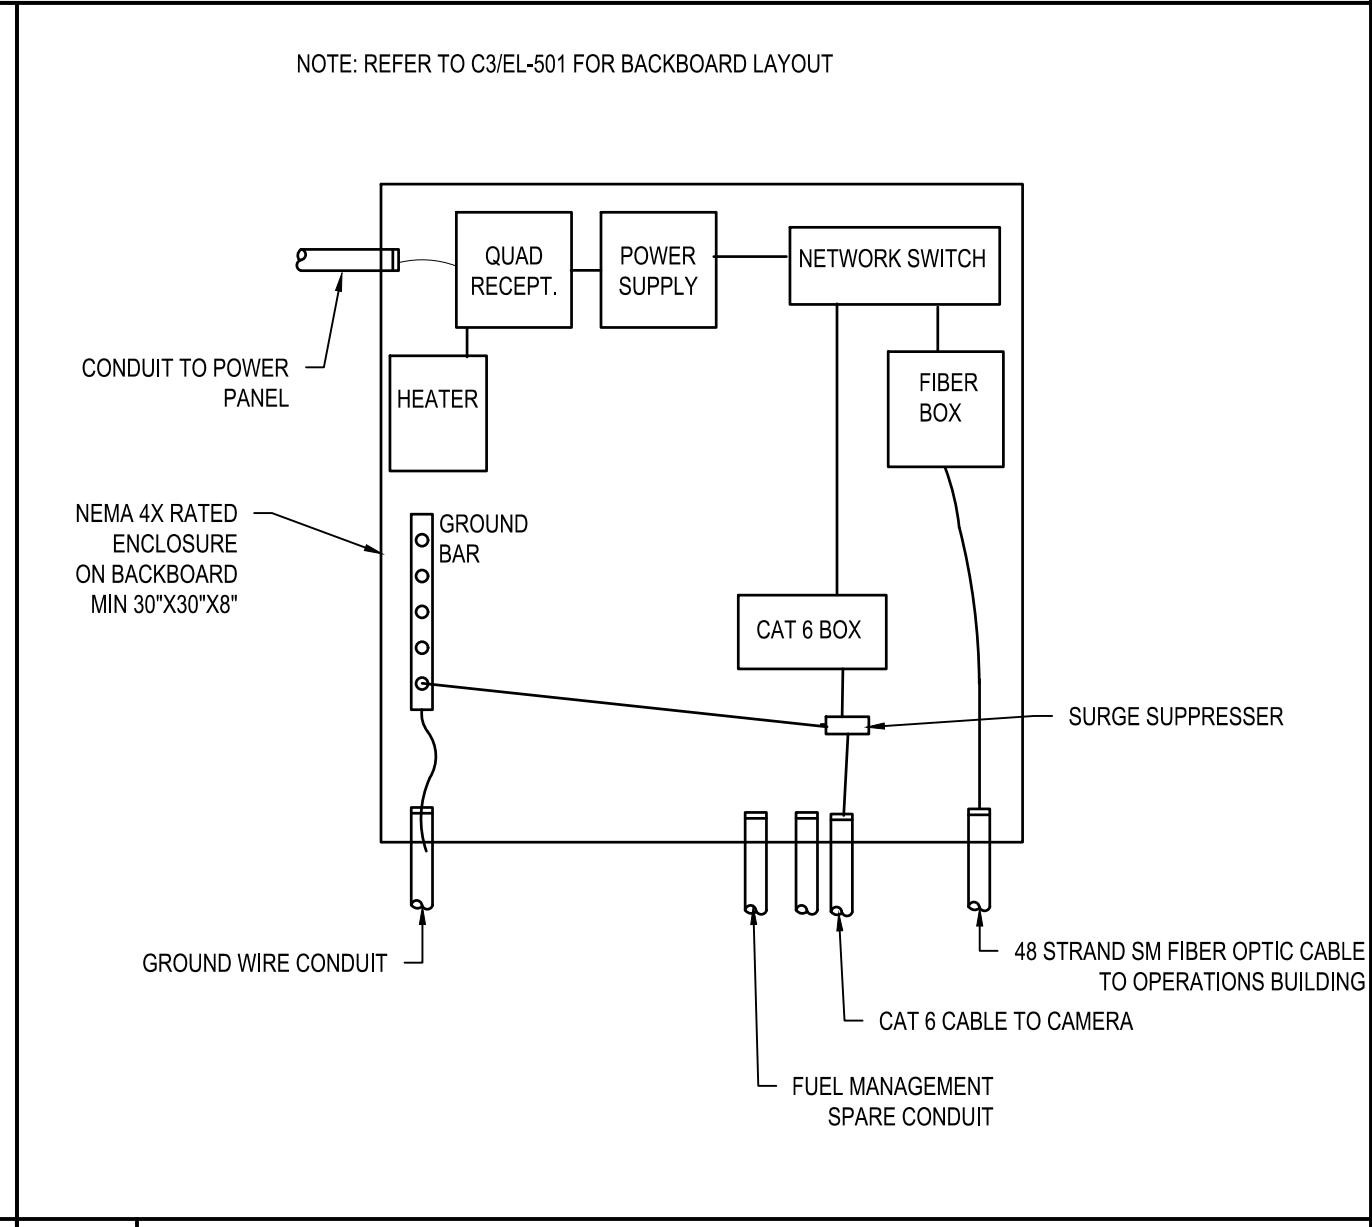

A4 COMM ENCLOSURE DETAIL
SCALE: NOT TO SCALE



C&S Engineers, Inc.
 38777 Six Mile Road, Suite 202
 Livonia, Michigan 48152
 Phone: 734-953-2571
 Fax: 734-206-7973
 www.cscos.com

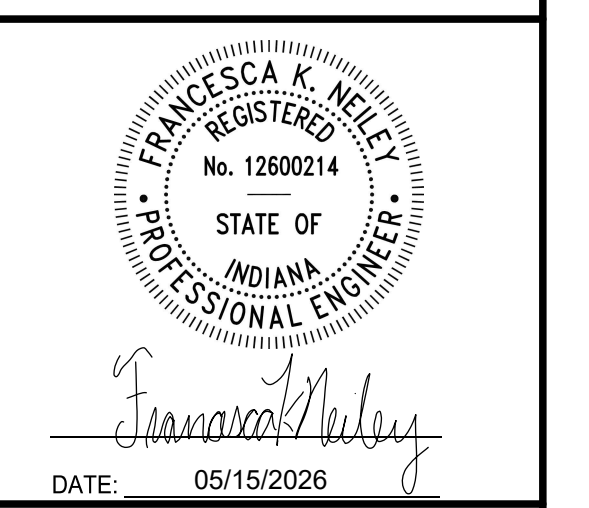

**FWA SELF SERVE FUEL FARM
 FORT WAYNE-ALLEN COUNTY
 AIRPORT AUTHORITY
 ALLEN COUNTY, INDIANA**


MARK	DATE	DESCRIPTION
▲	05/15/26	ADDENDUM 1
REVISIONS		
PROJECT NO: BL9.001.001		
DATE: APRIL 2026		
DRAWN BY: W.BARLEY		
DESIGNED BY: W.BARLEY		
CHECKED BY: S.SHOVA		
CONTRACTOR SHALL VERIFY ALL CONDITIONS ON JOB SITE & NOTIFY THE OWNER OF ANY VARIATIONS FROM DIMENSIONS SHOWN ON THESE DRAWINGS BEFORE PROCEEDING WITH ANY CONSTRUCTION.		

ELECTRICAL DETAILS




REFER TO A1/EP102

 B1 PLAN
SCALE: 1" = 60'




B4 SHEET NOTES
SCALE: NOT TO SCALE

1. ALL CONDUIT AT FUEL FACILITY SHALL BE 1" RGS UNLESS OTHERWISE NOTED.
2. PROVIDE TWO -3 CELL FABRIC TYPE INNERDUCT IN 4" UNDERGROUND CONDUIT AND ONE -3 CELL IN 2" UNDERGROUND CONDUIT.

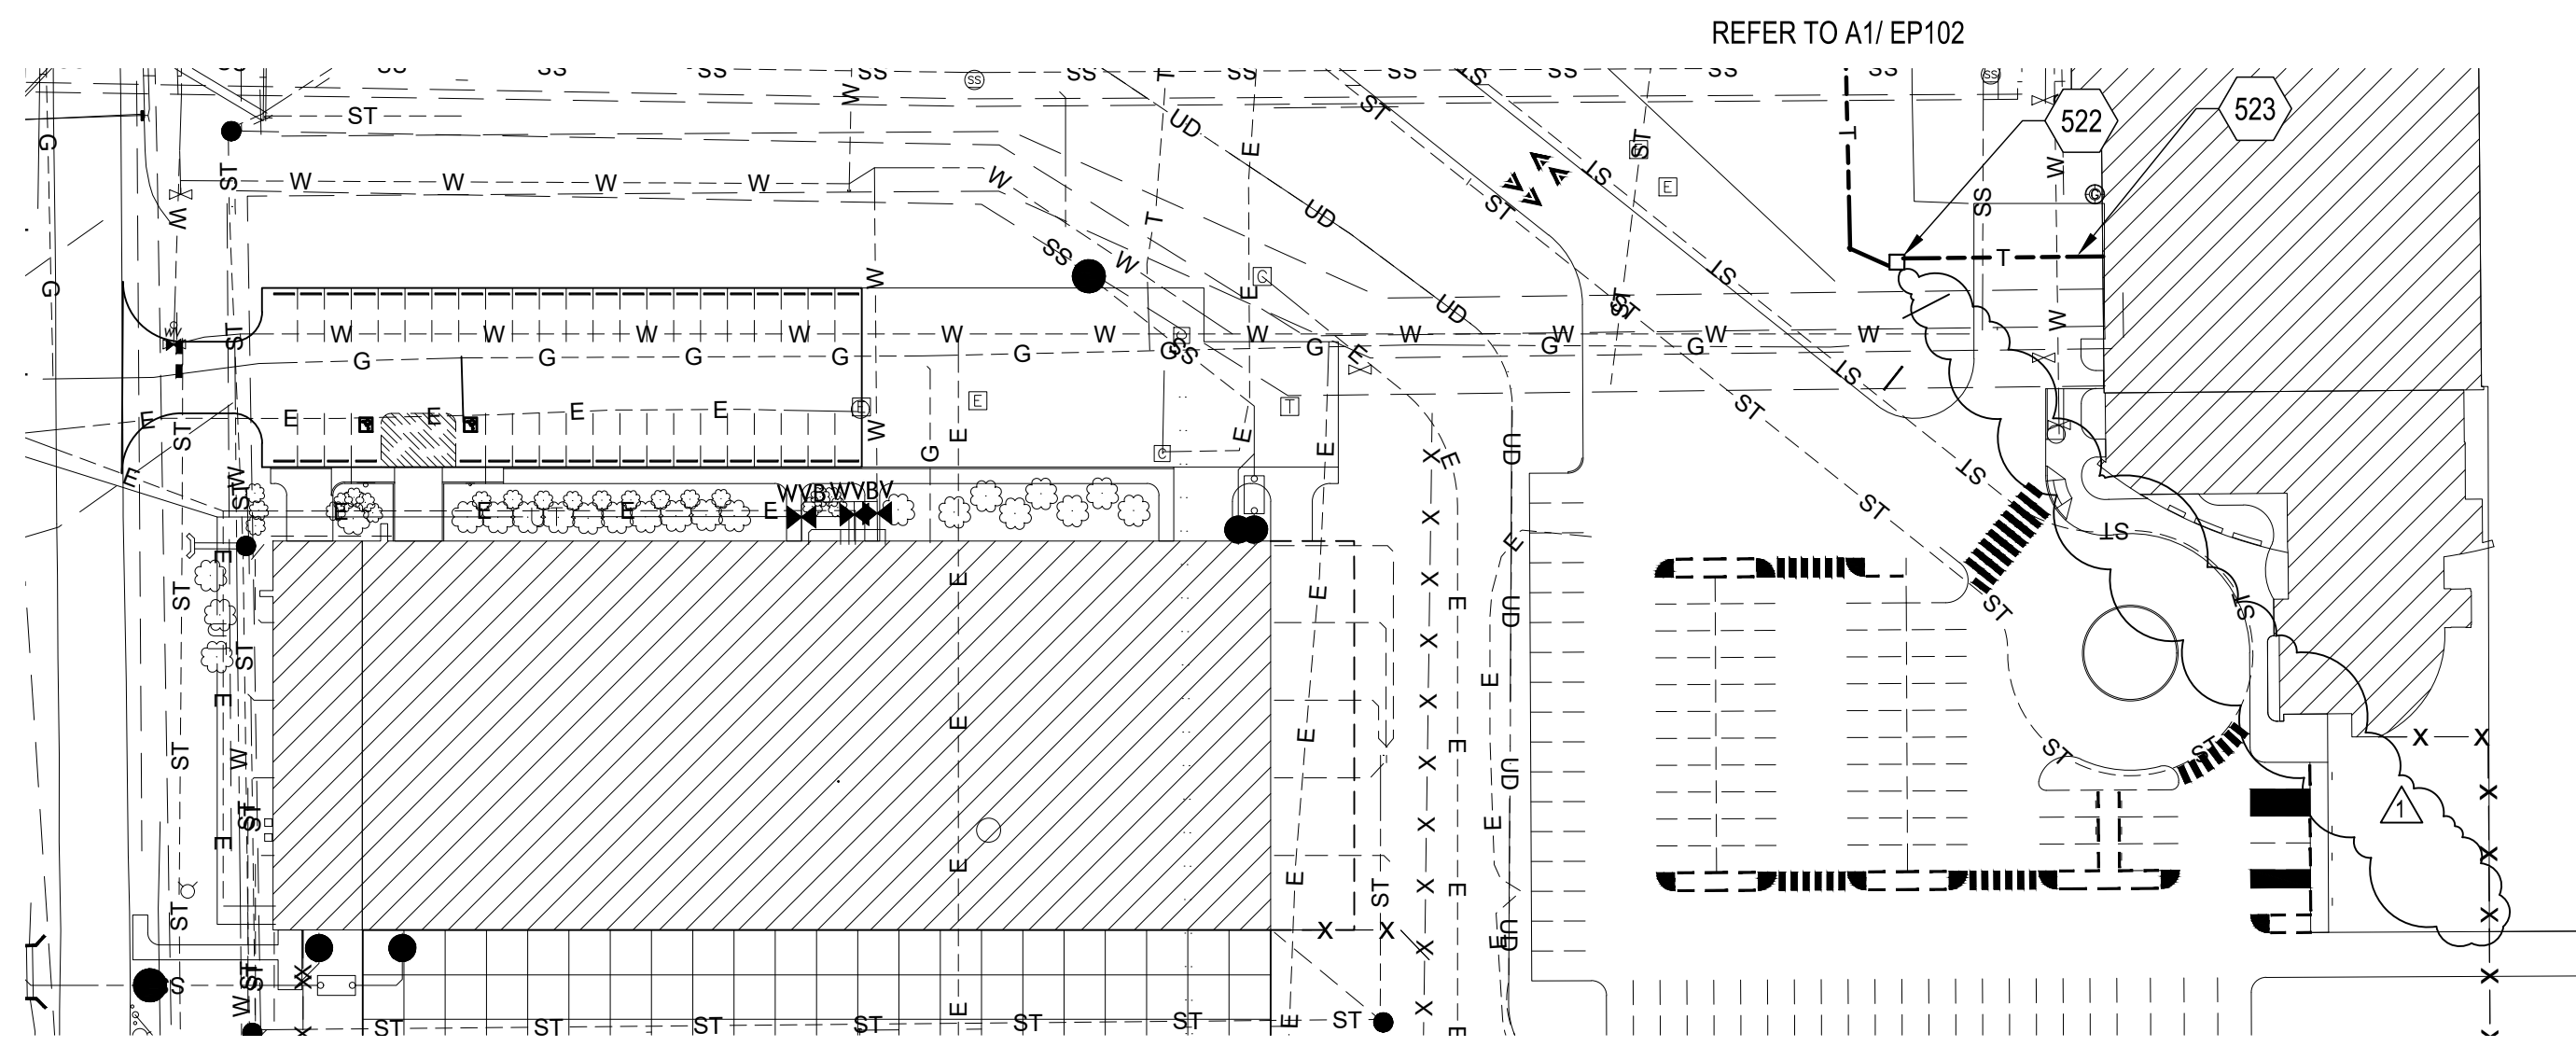

REFER TO A1/EP102

 
A1 PLAN
SCALE: 1" = 60'



A4 KEYED NOTES
SCALE: NOT TO SCALE



C&S Engineers, Inc.
38777 Six Mile Road, Suite 202
Livonia, Michigan 48152
Phone: 734-953-2571
Fax: 734-206-7973
www.cscos.com

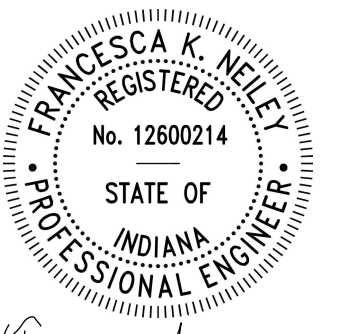

Francisca Kelley
DATE: 05/15/2026



**FWA SELF SERVE FUEL FARM
FORT WAYNE-ALLEN COUNTY
AIRPORT AUTHORITY
ALLEN COUNTY, INDIANA**

MARK	DATE	DESCRIPTION
▲	05/15/26	ADDENDUM 1
REVISIONS		
PROJECT NO: BL9.001.001		
DATE: APRIL 2026		
DRAWN BY: W.BARLEY		
DESIGNED BY: W.BARLEY		
CHECKED BY: S.SHOVA		
CONTRACTOR SHALL VERIFY ALL CONDITIONS ON JOB SITE & NOTIFY THE OWNER OF ANY VARIATIONS FROM DIMENSIONS SHOWN ON THESE DRAWINGS BEFORE PROCEEDING WITH ANY CONSTRUCTION.		

**ELECTRICAL
PROPOSED PLAN**

EP103

SHEET NO. 25 OF 28